




ISO VIEW
SCALE: NONE

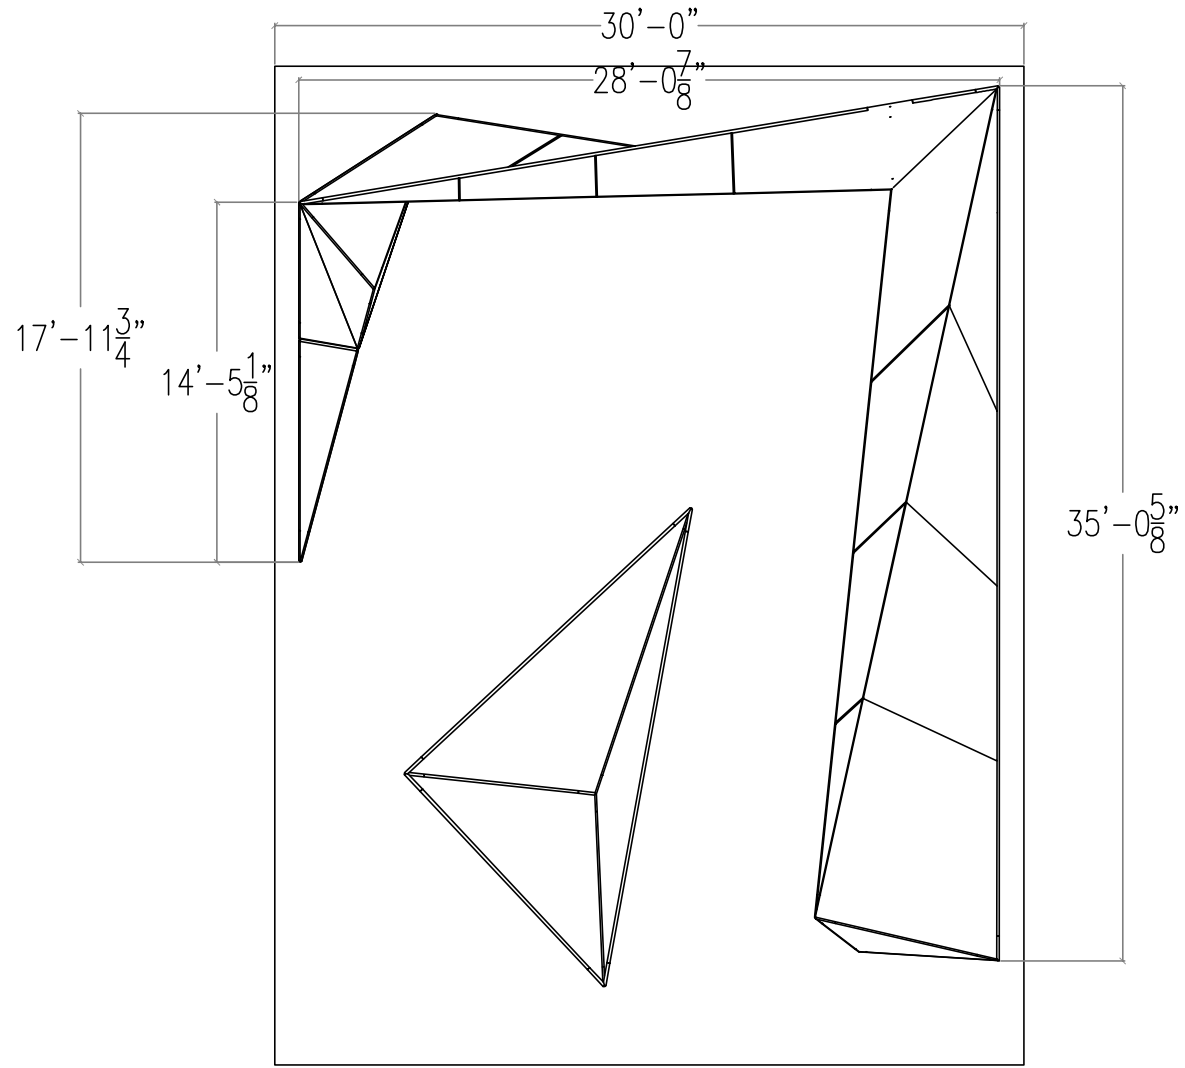

PLAN VIEW
SCALE: 1/8"=1'-0"

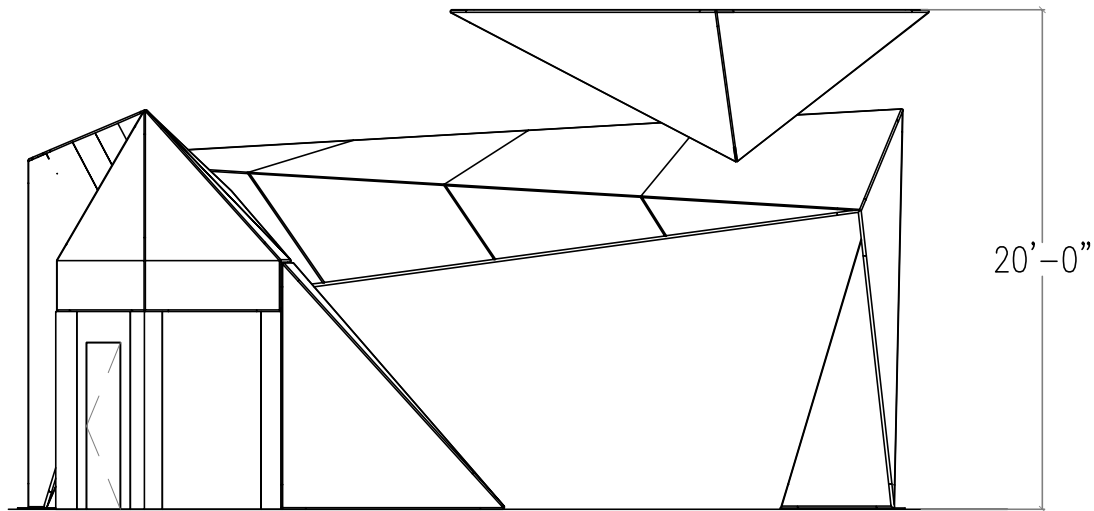


SIDE VIEW
SCALE: 1/8"=1'-0"

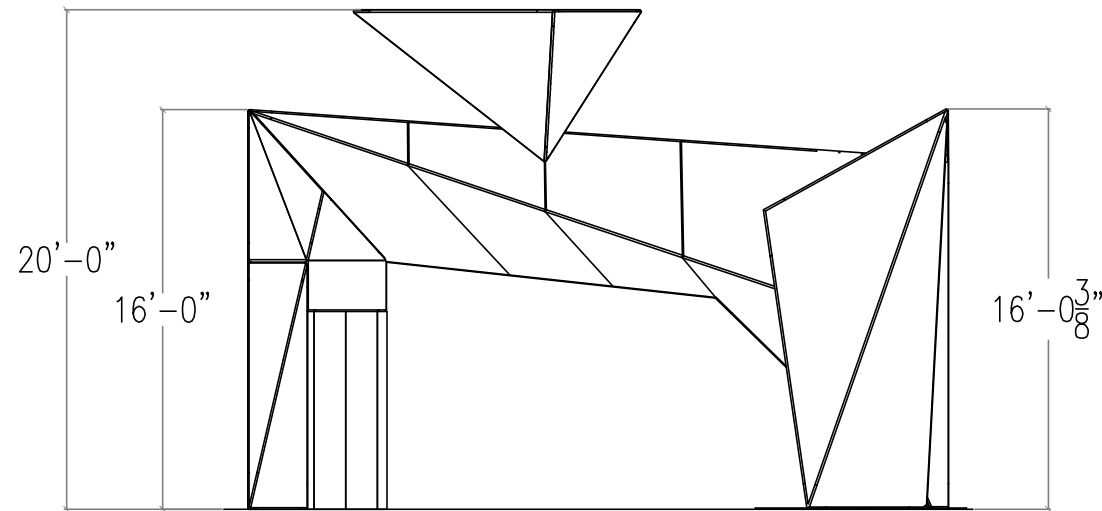



FRONT VIEW
SCALE: 1/8"=1'-0"

--	--	--	--

ISO VIEW
SCALE: NONE

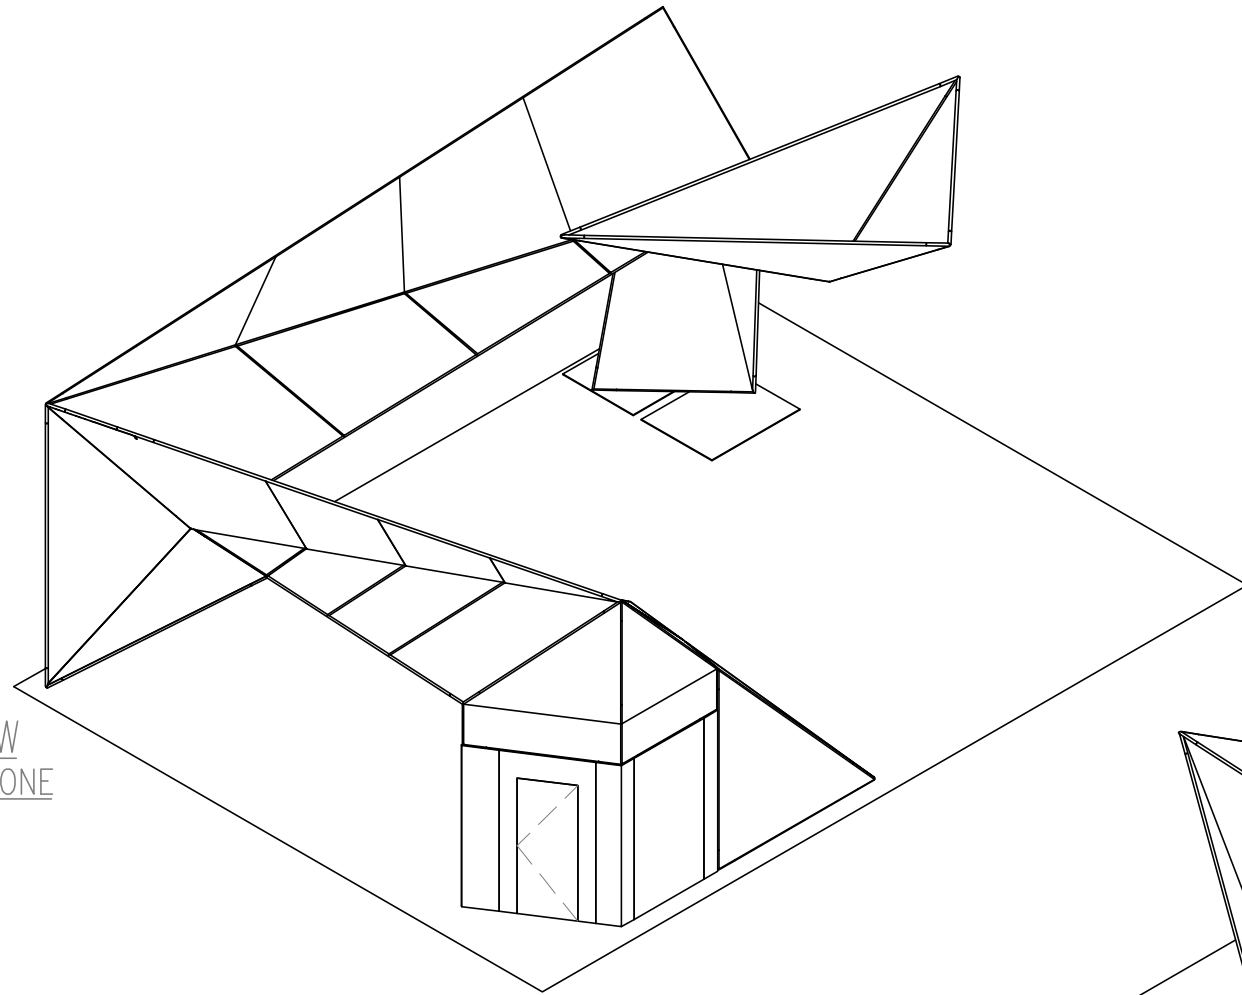

ISO VIEW
SCALE: NONE

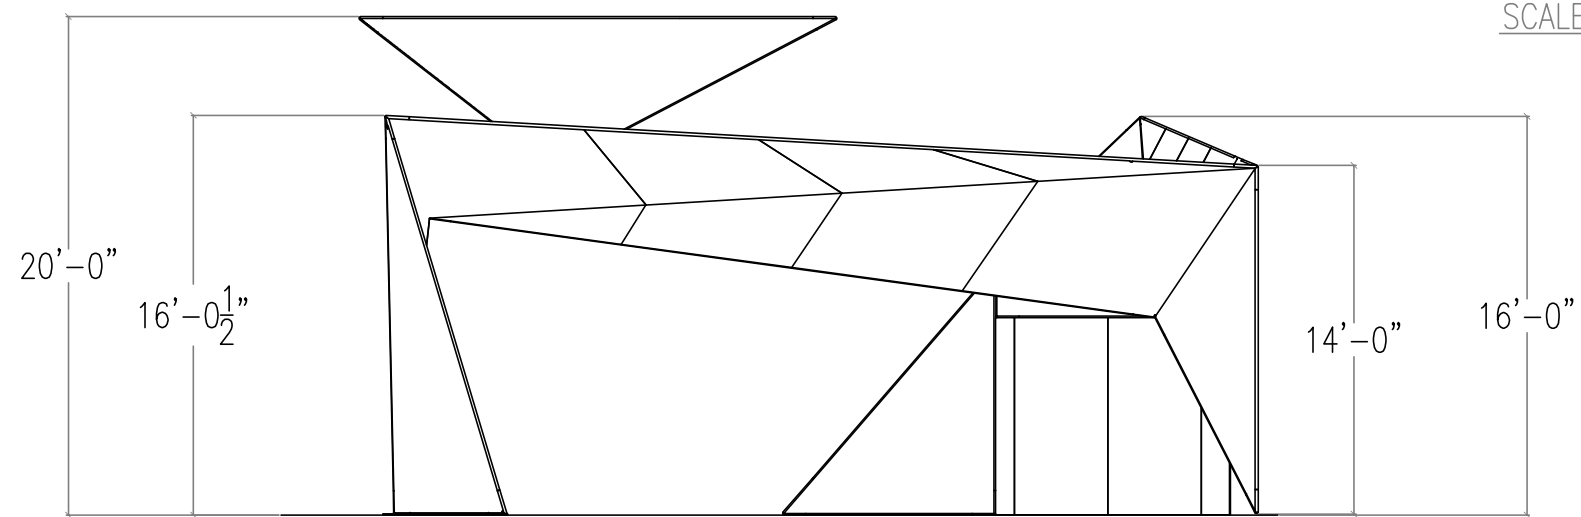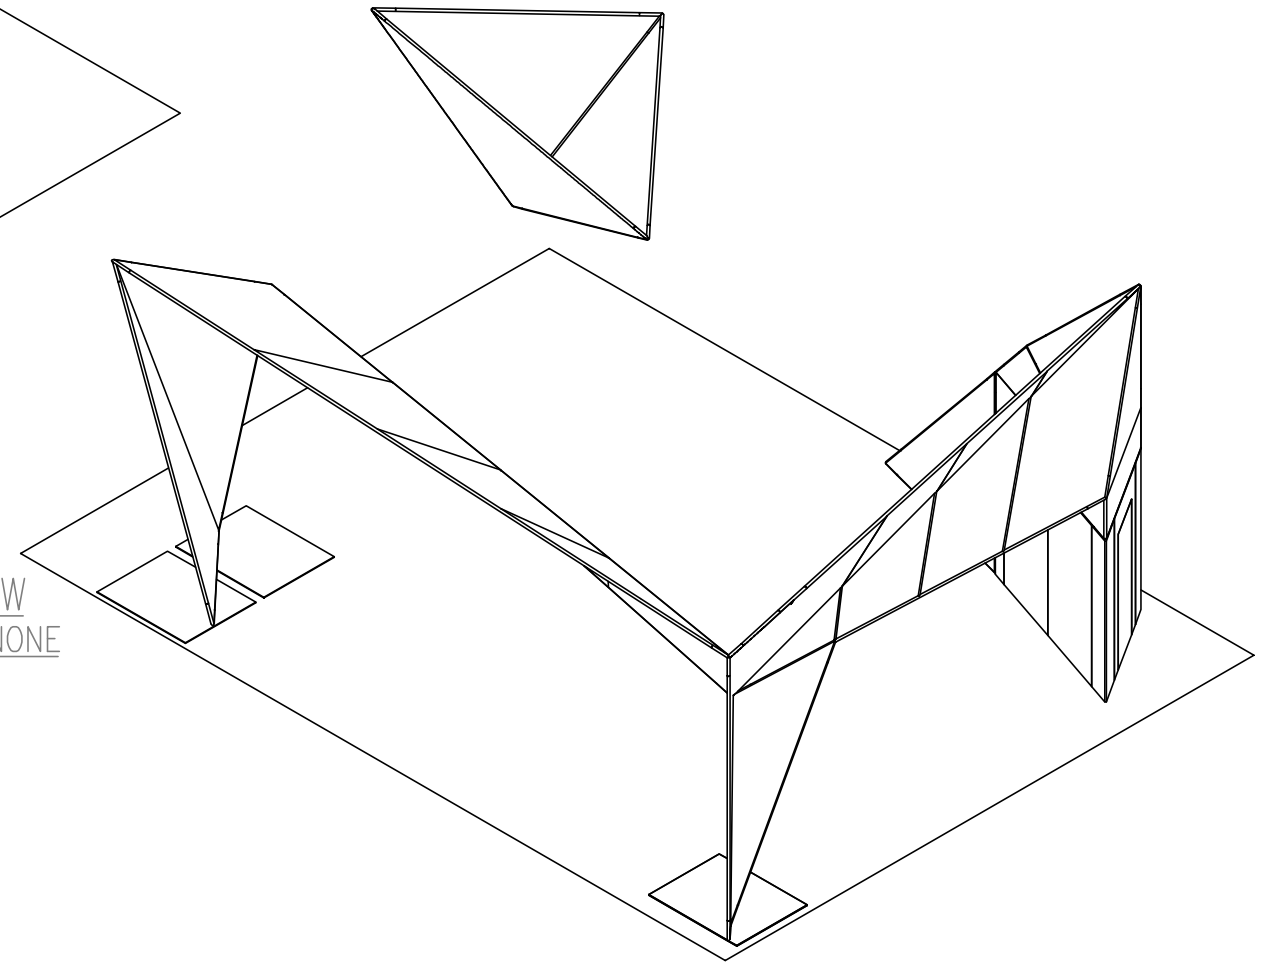


SIDE VIEW
SCALE: 1/8"=1'-0"

BOOTH #1511

30'-0"

BOOTH #1405

BOOTH #1705

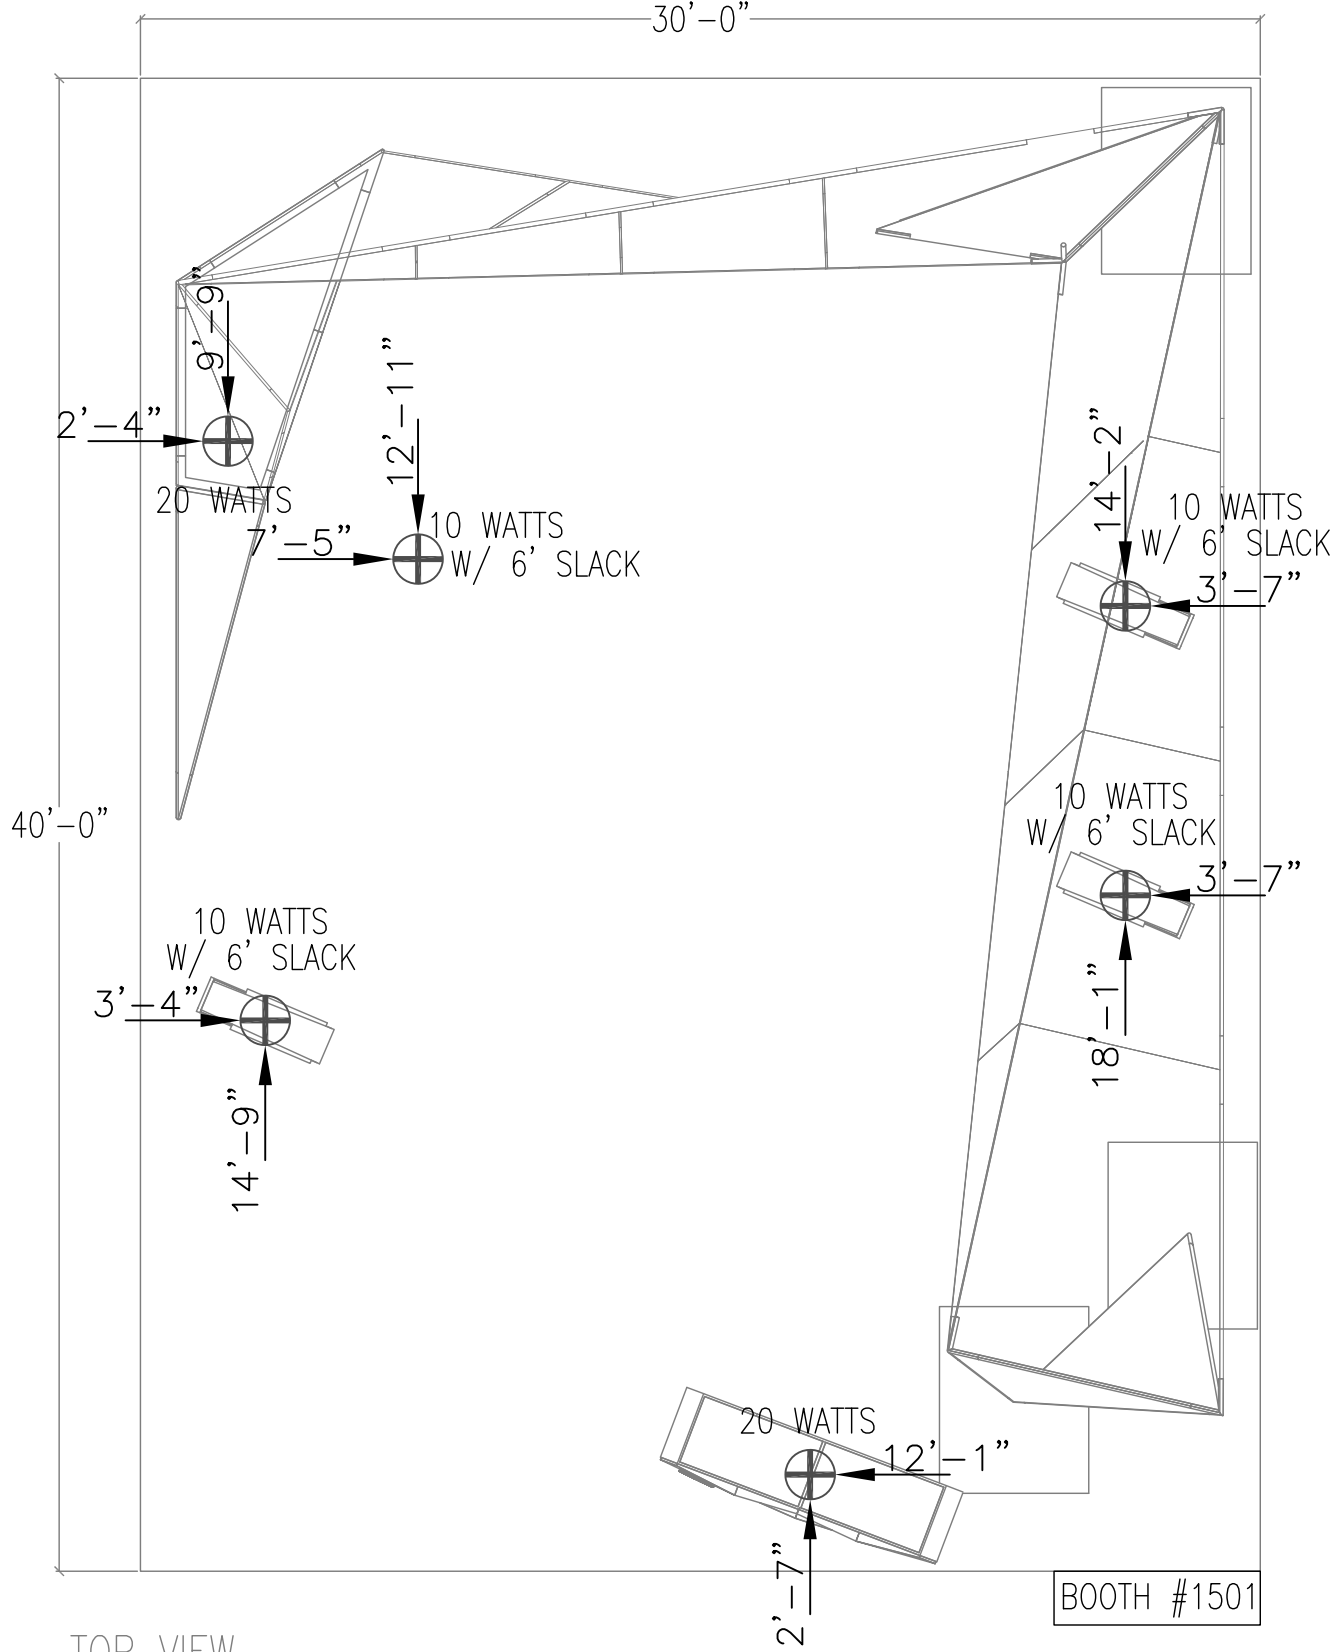


BOOTH #1401

BOOTH #1701


TOP VIEW
SCALE: 3/16=1"-0"

ELECTRICAL PLAN
(4) 10 WATTS
(2) 20 WATTS

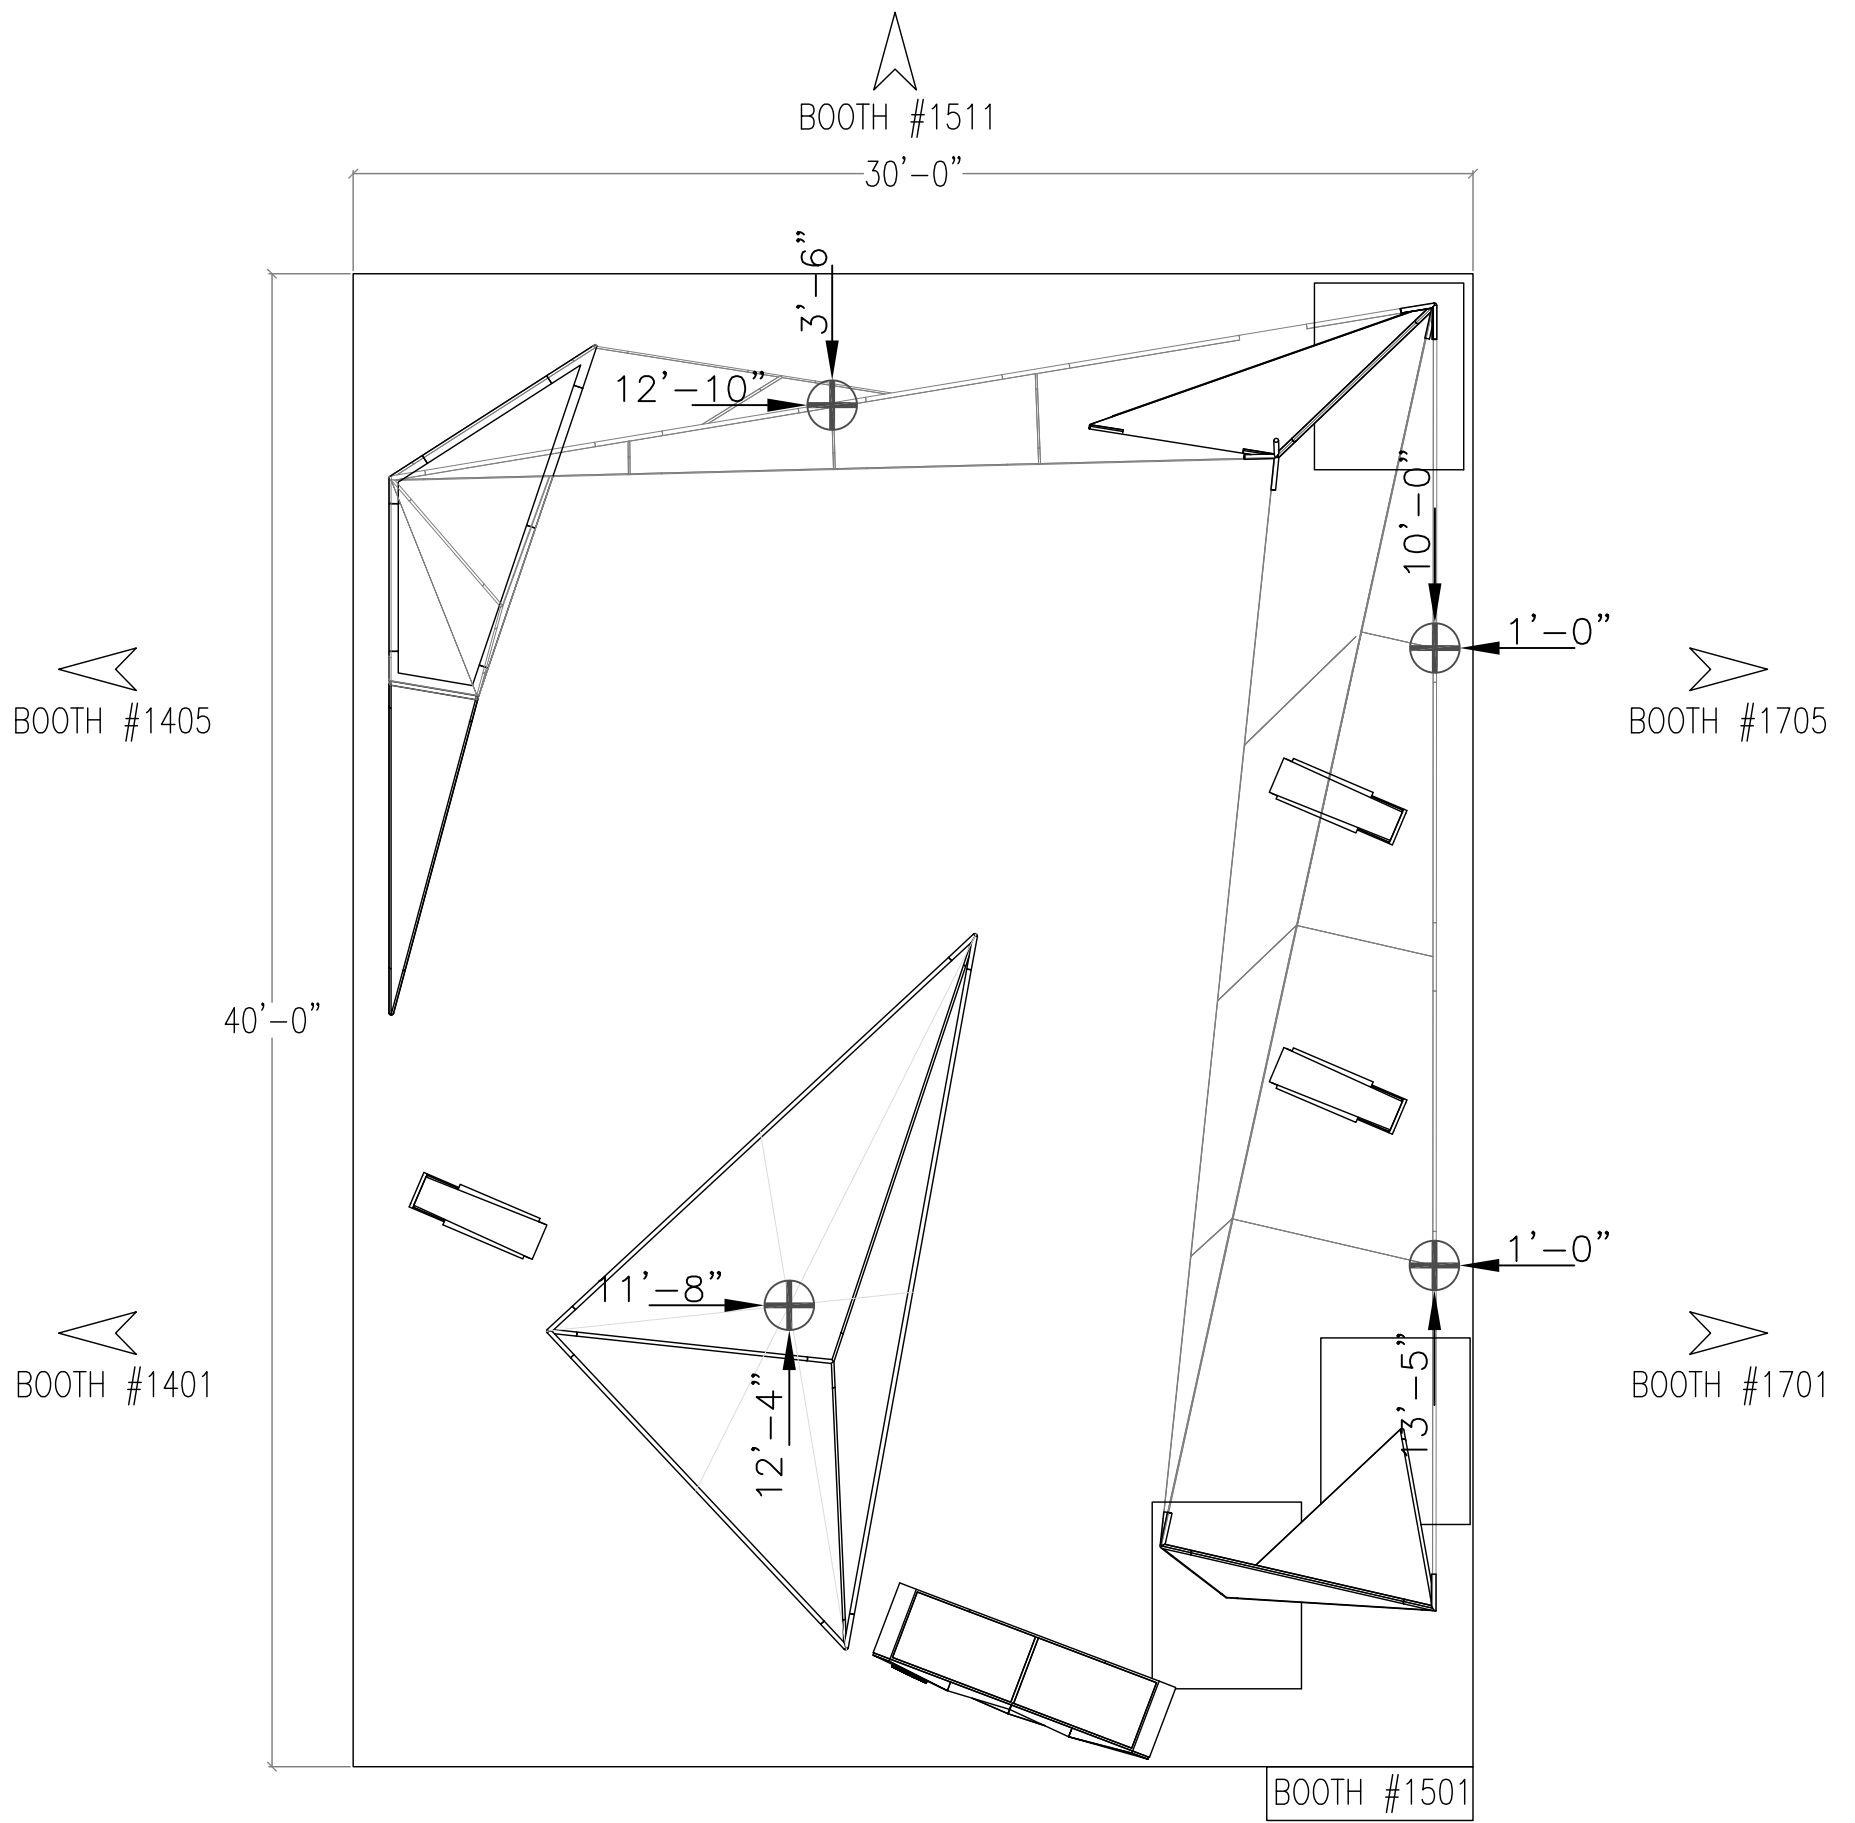



TOP VIEW
SCALE: 3/16=1"-0"

ENTRANCE

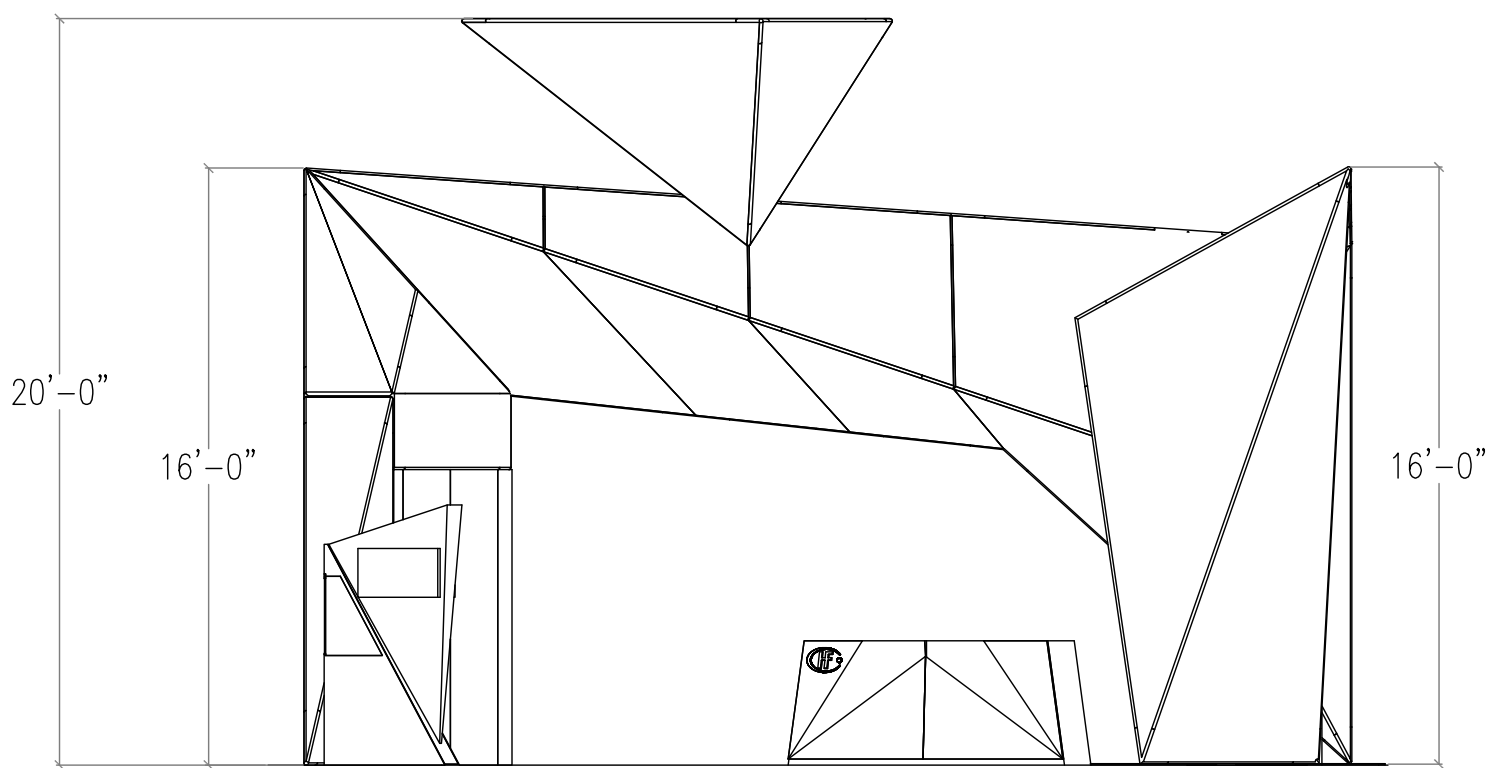


FRONT VIEW
SCALE: 3/16=1"-0"

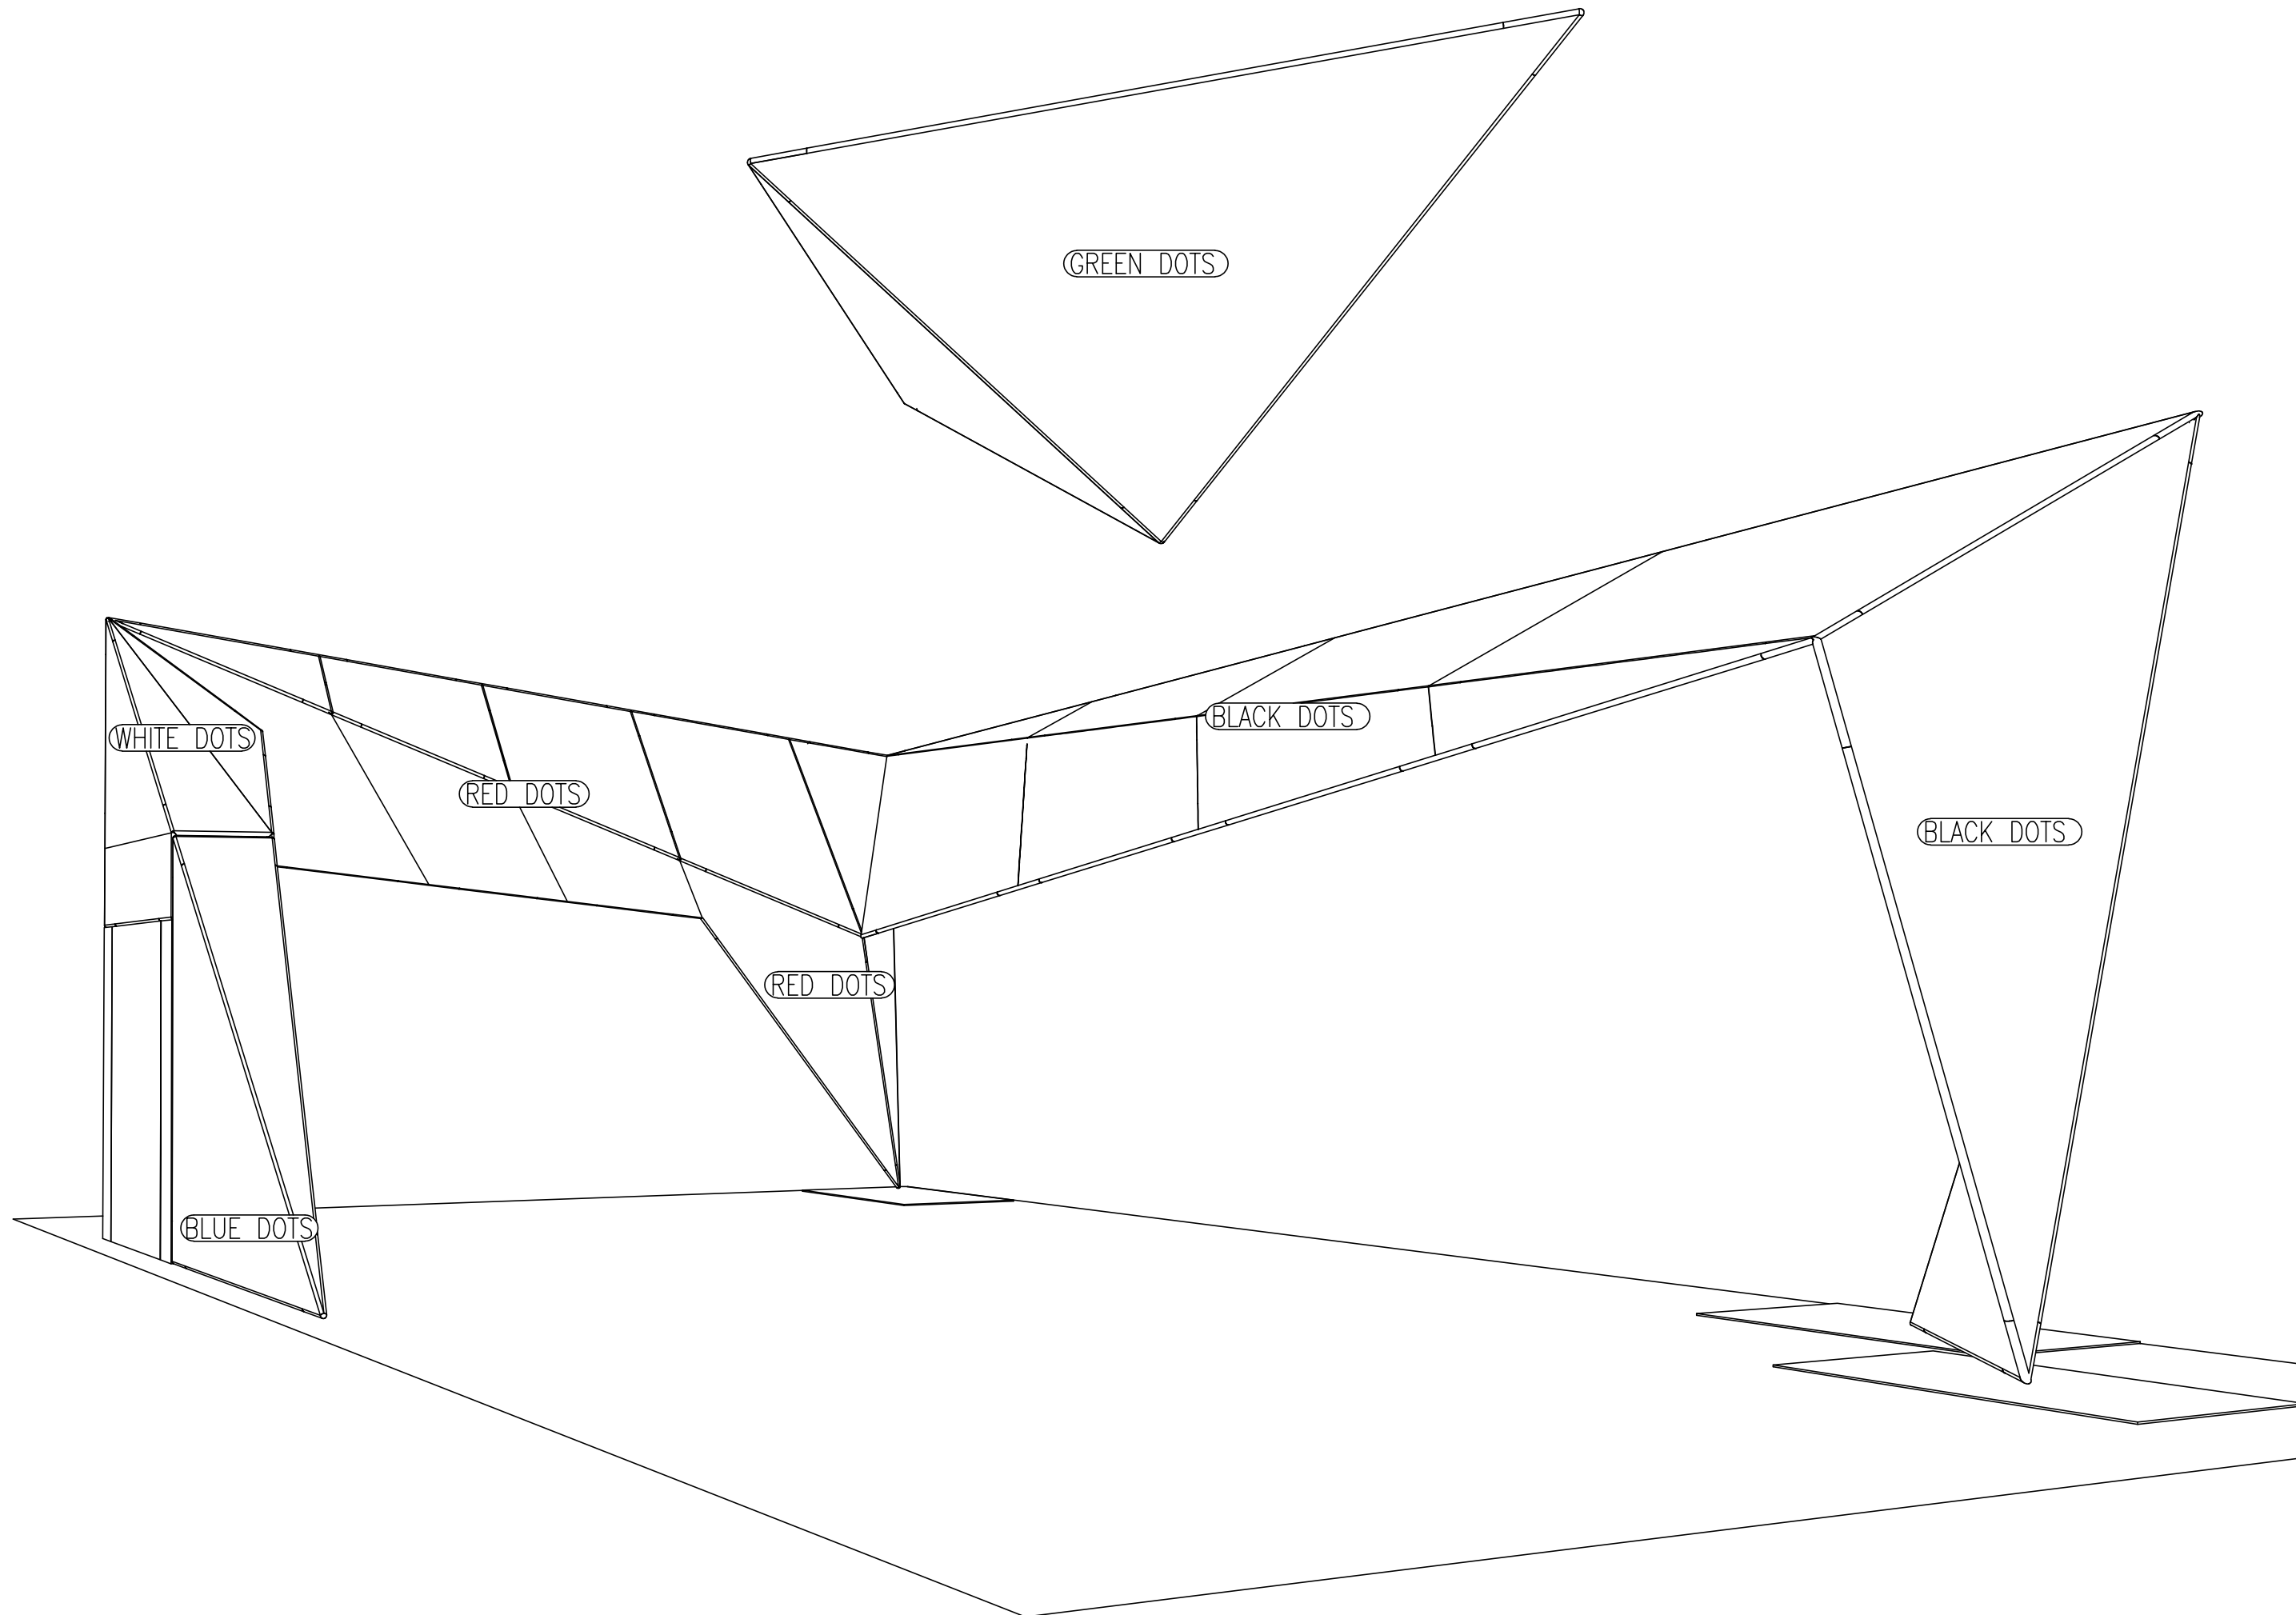

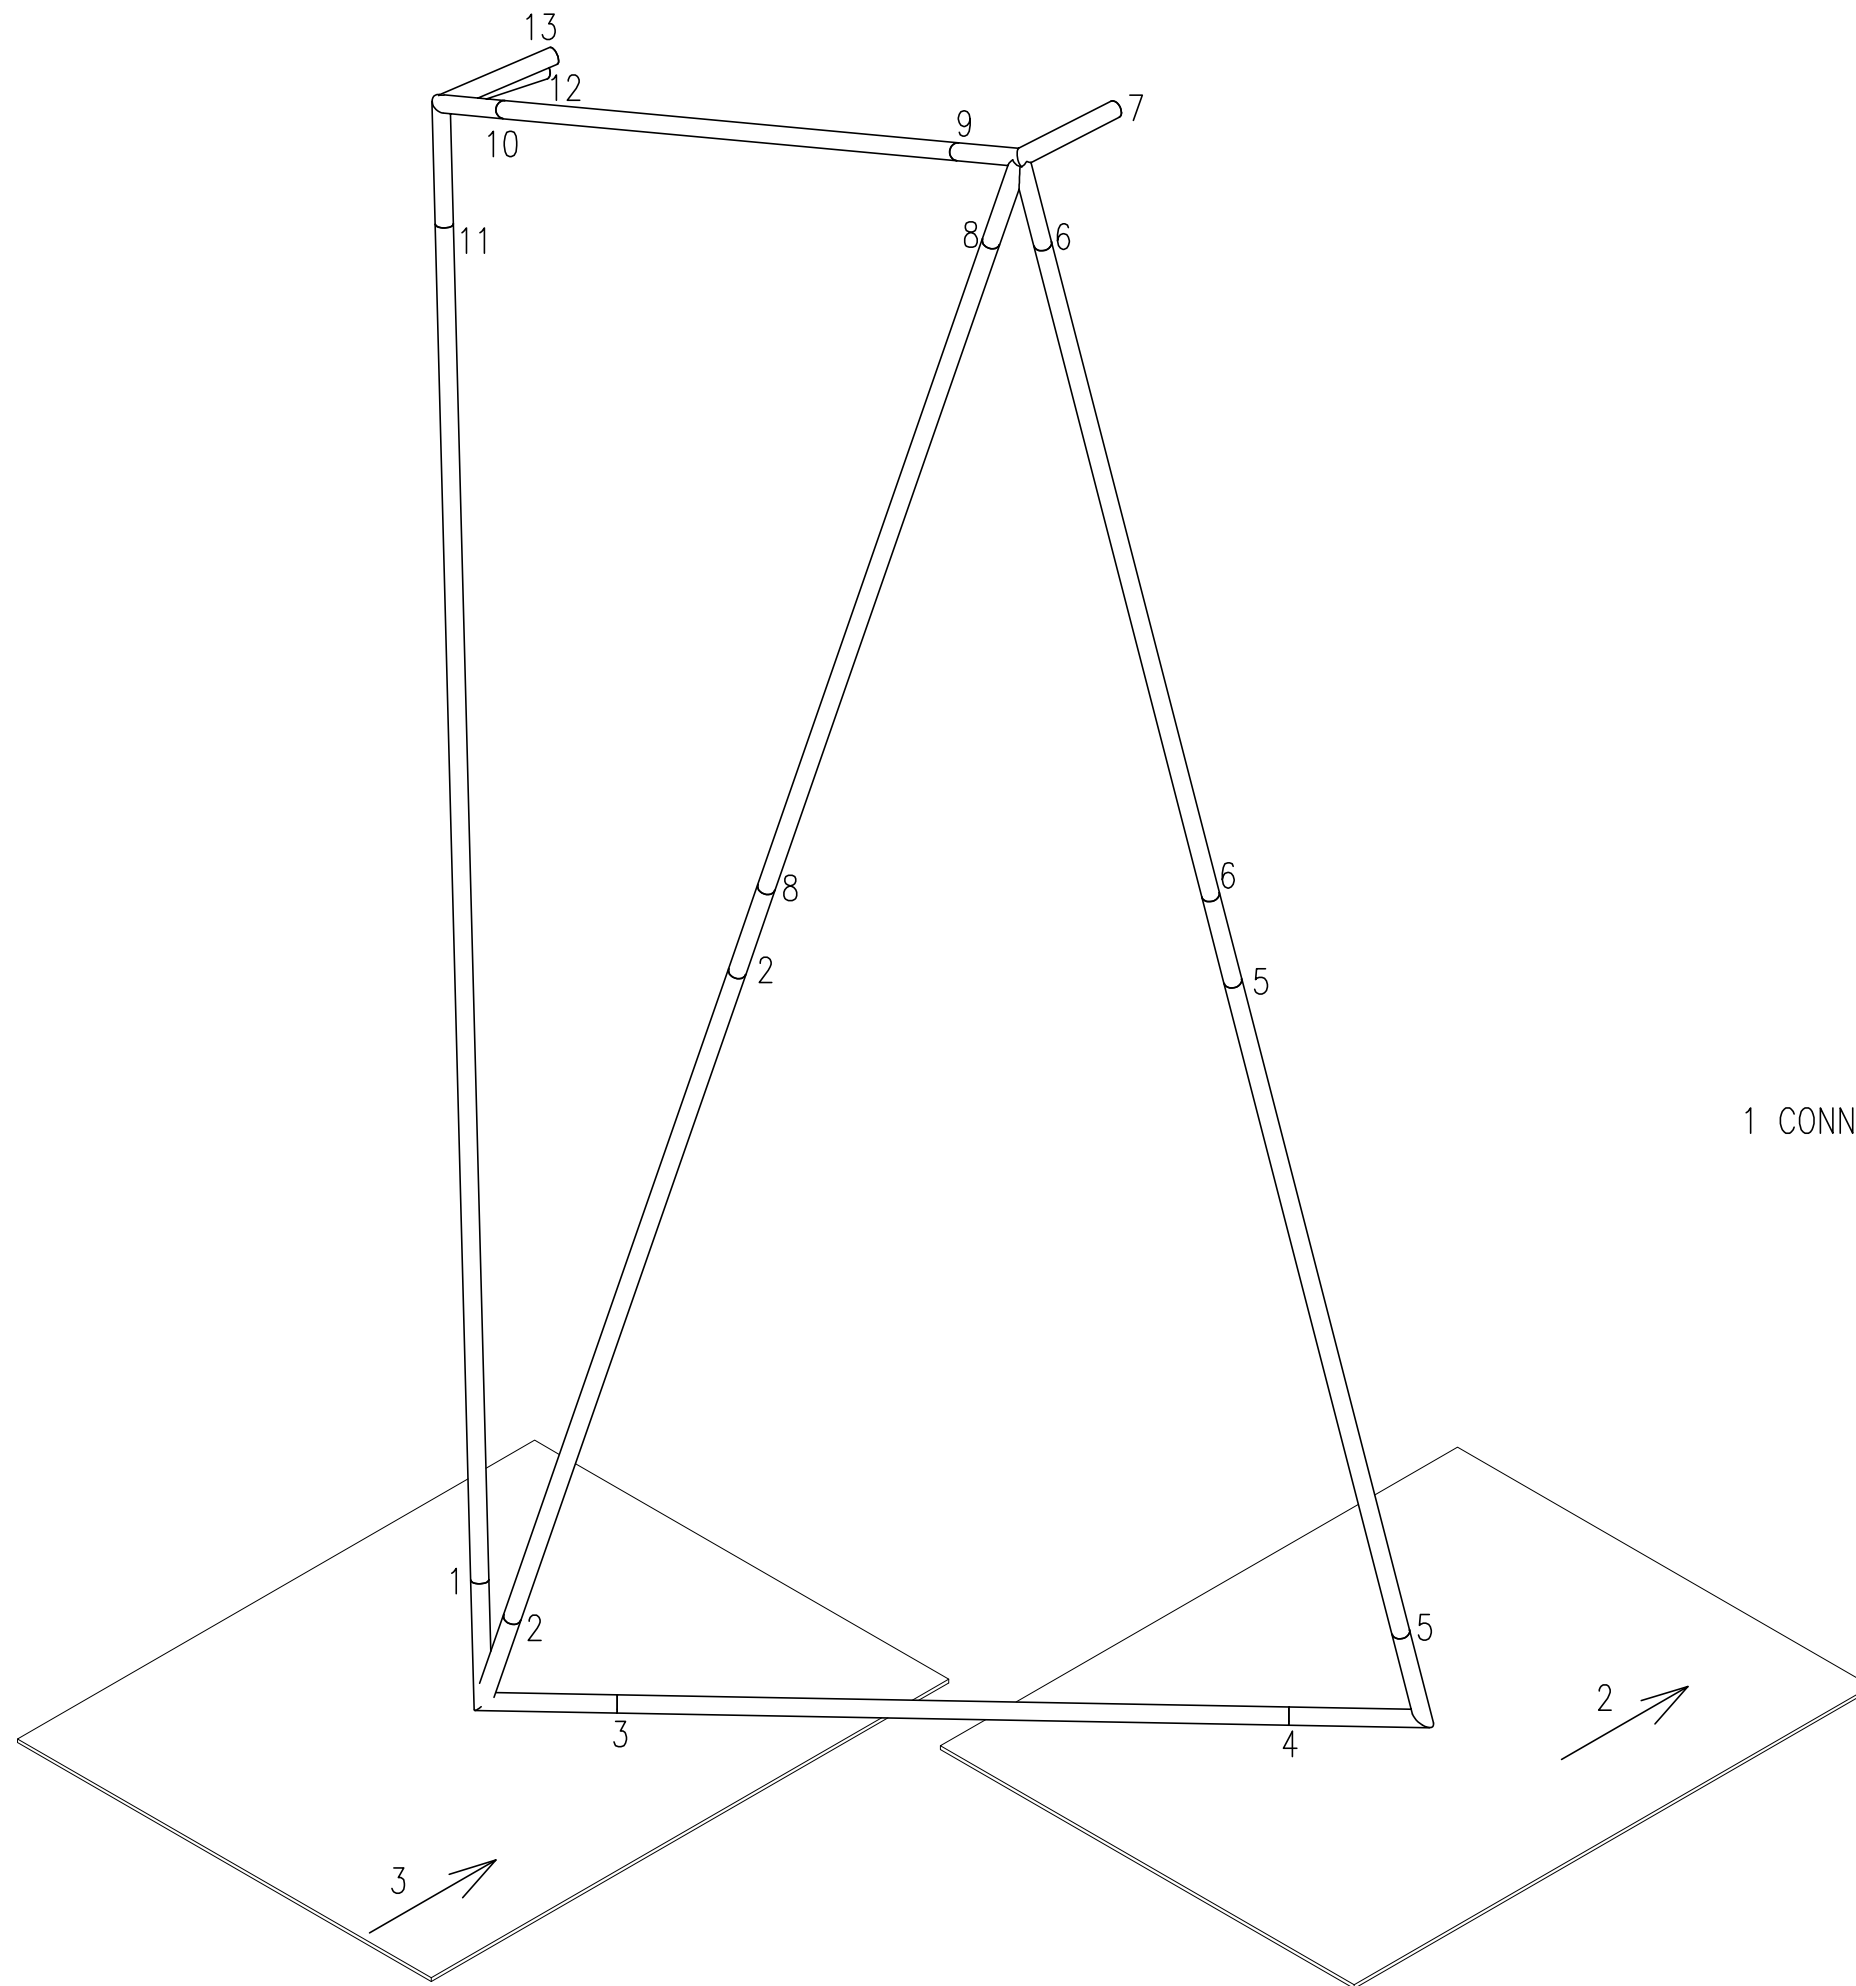

ALIKE NUMBERS CONNECT
 1 CONNECTS TO 1, 2 TO 2,3 TO 3,...N TO N


BLACK DOTS

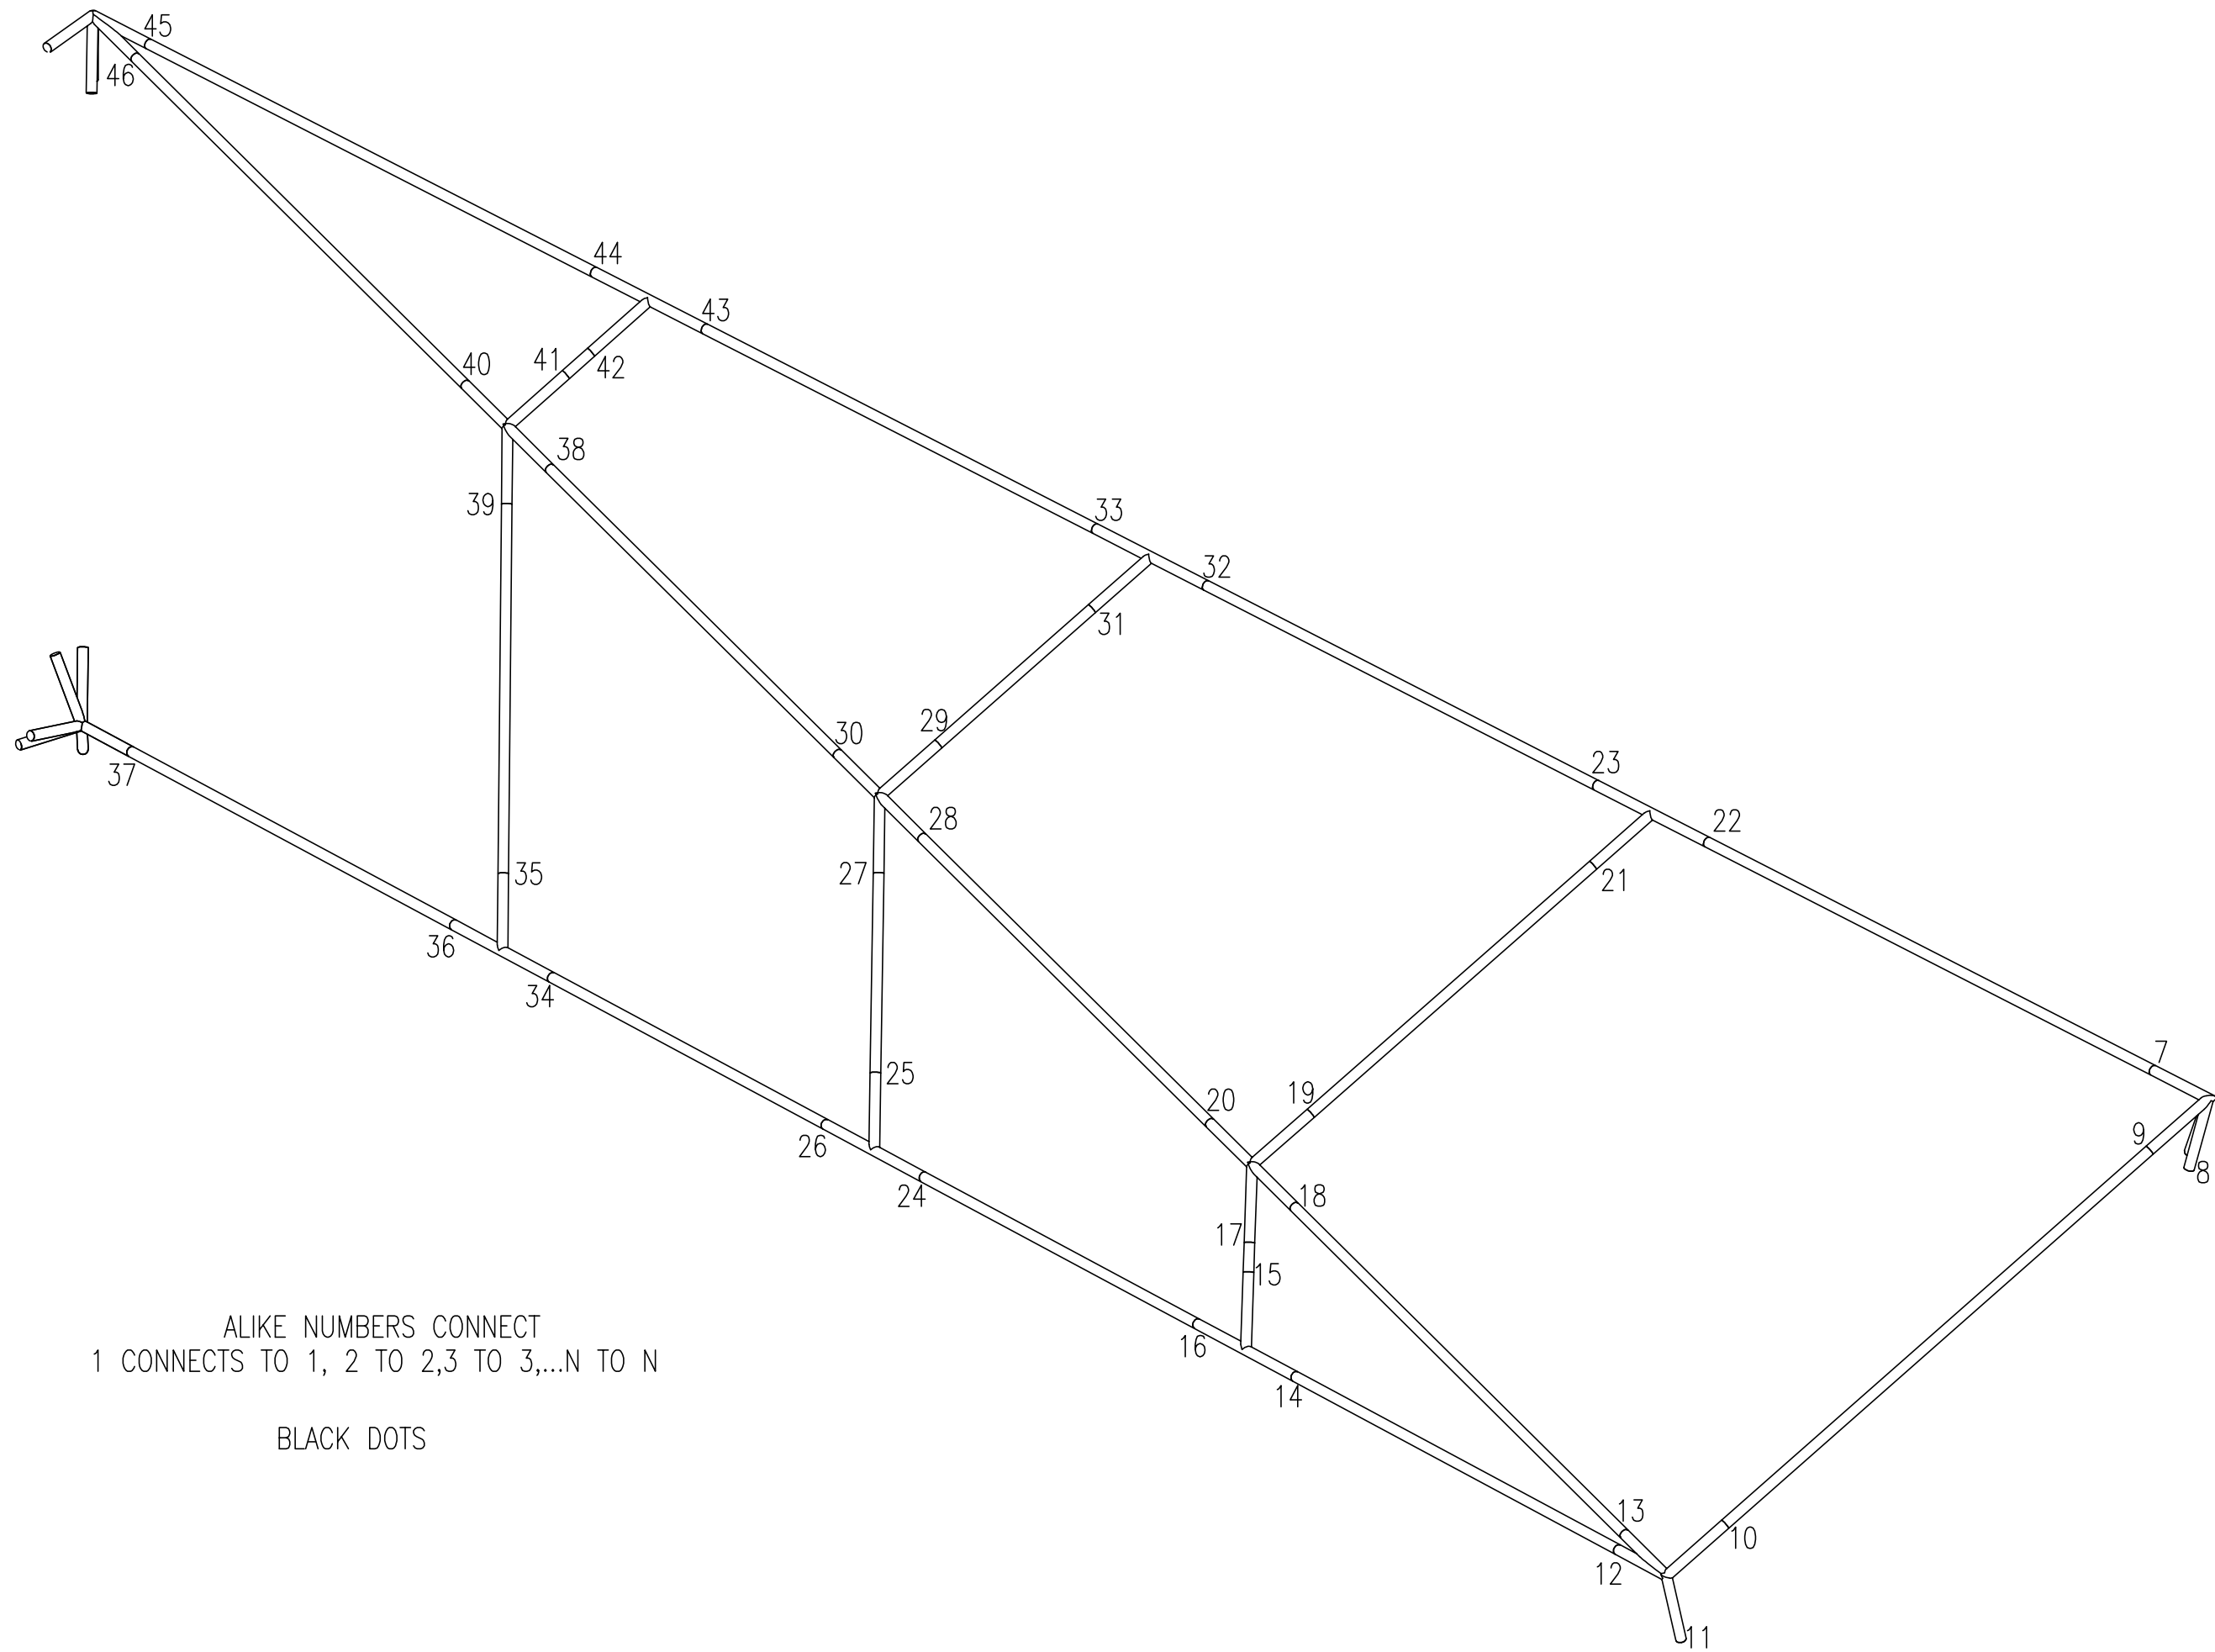


ALIKE NUMBERS CONNECT
 1 CONNECTS TO 1, 2 TO 2,3 TO 3,...N TO N

BLACK DOTS



ALIKE NUMBERS CONNECT
 1 CONNECTS TO 1, 2 TO 2, 3 TO 3, ... N TO N
 RED DOTS

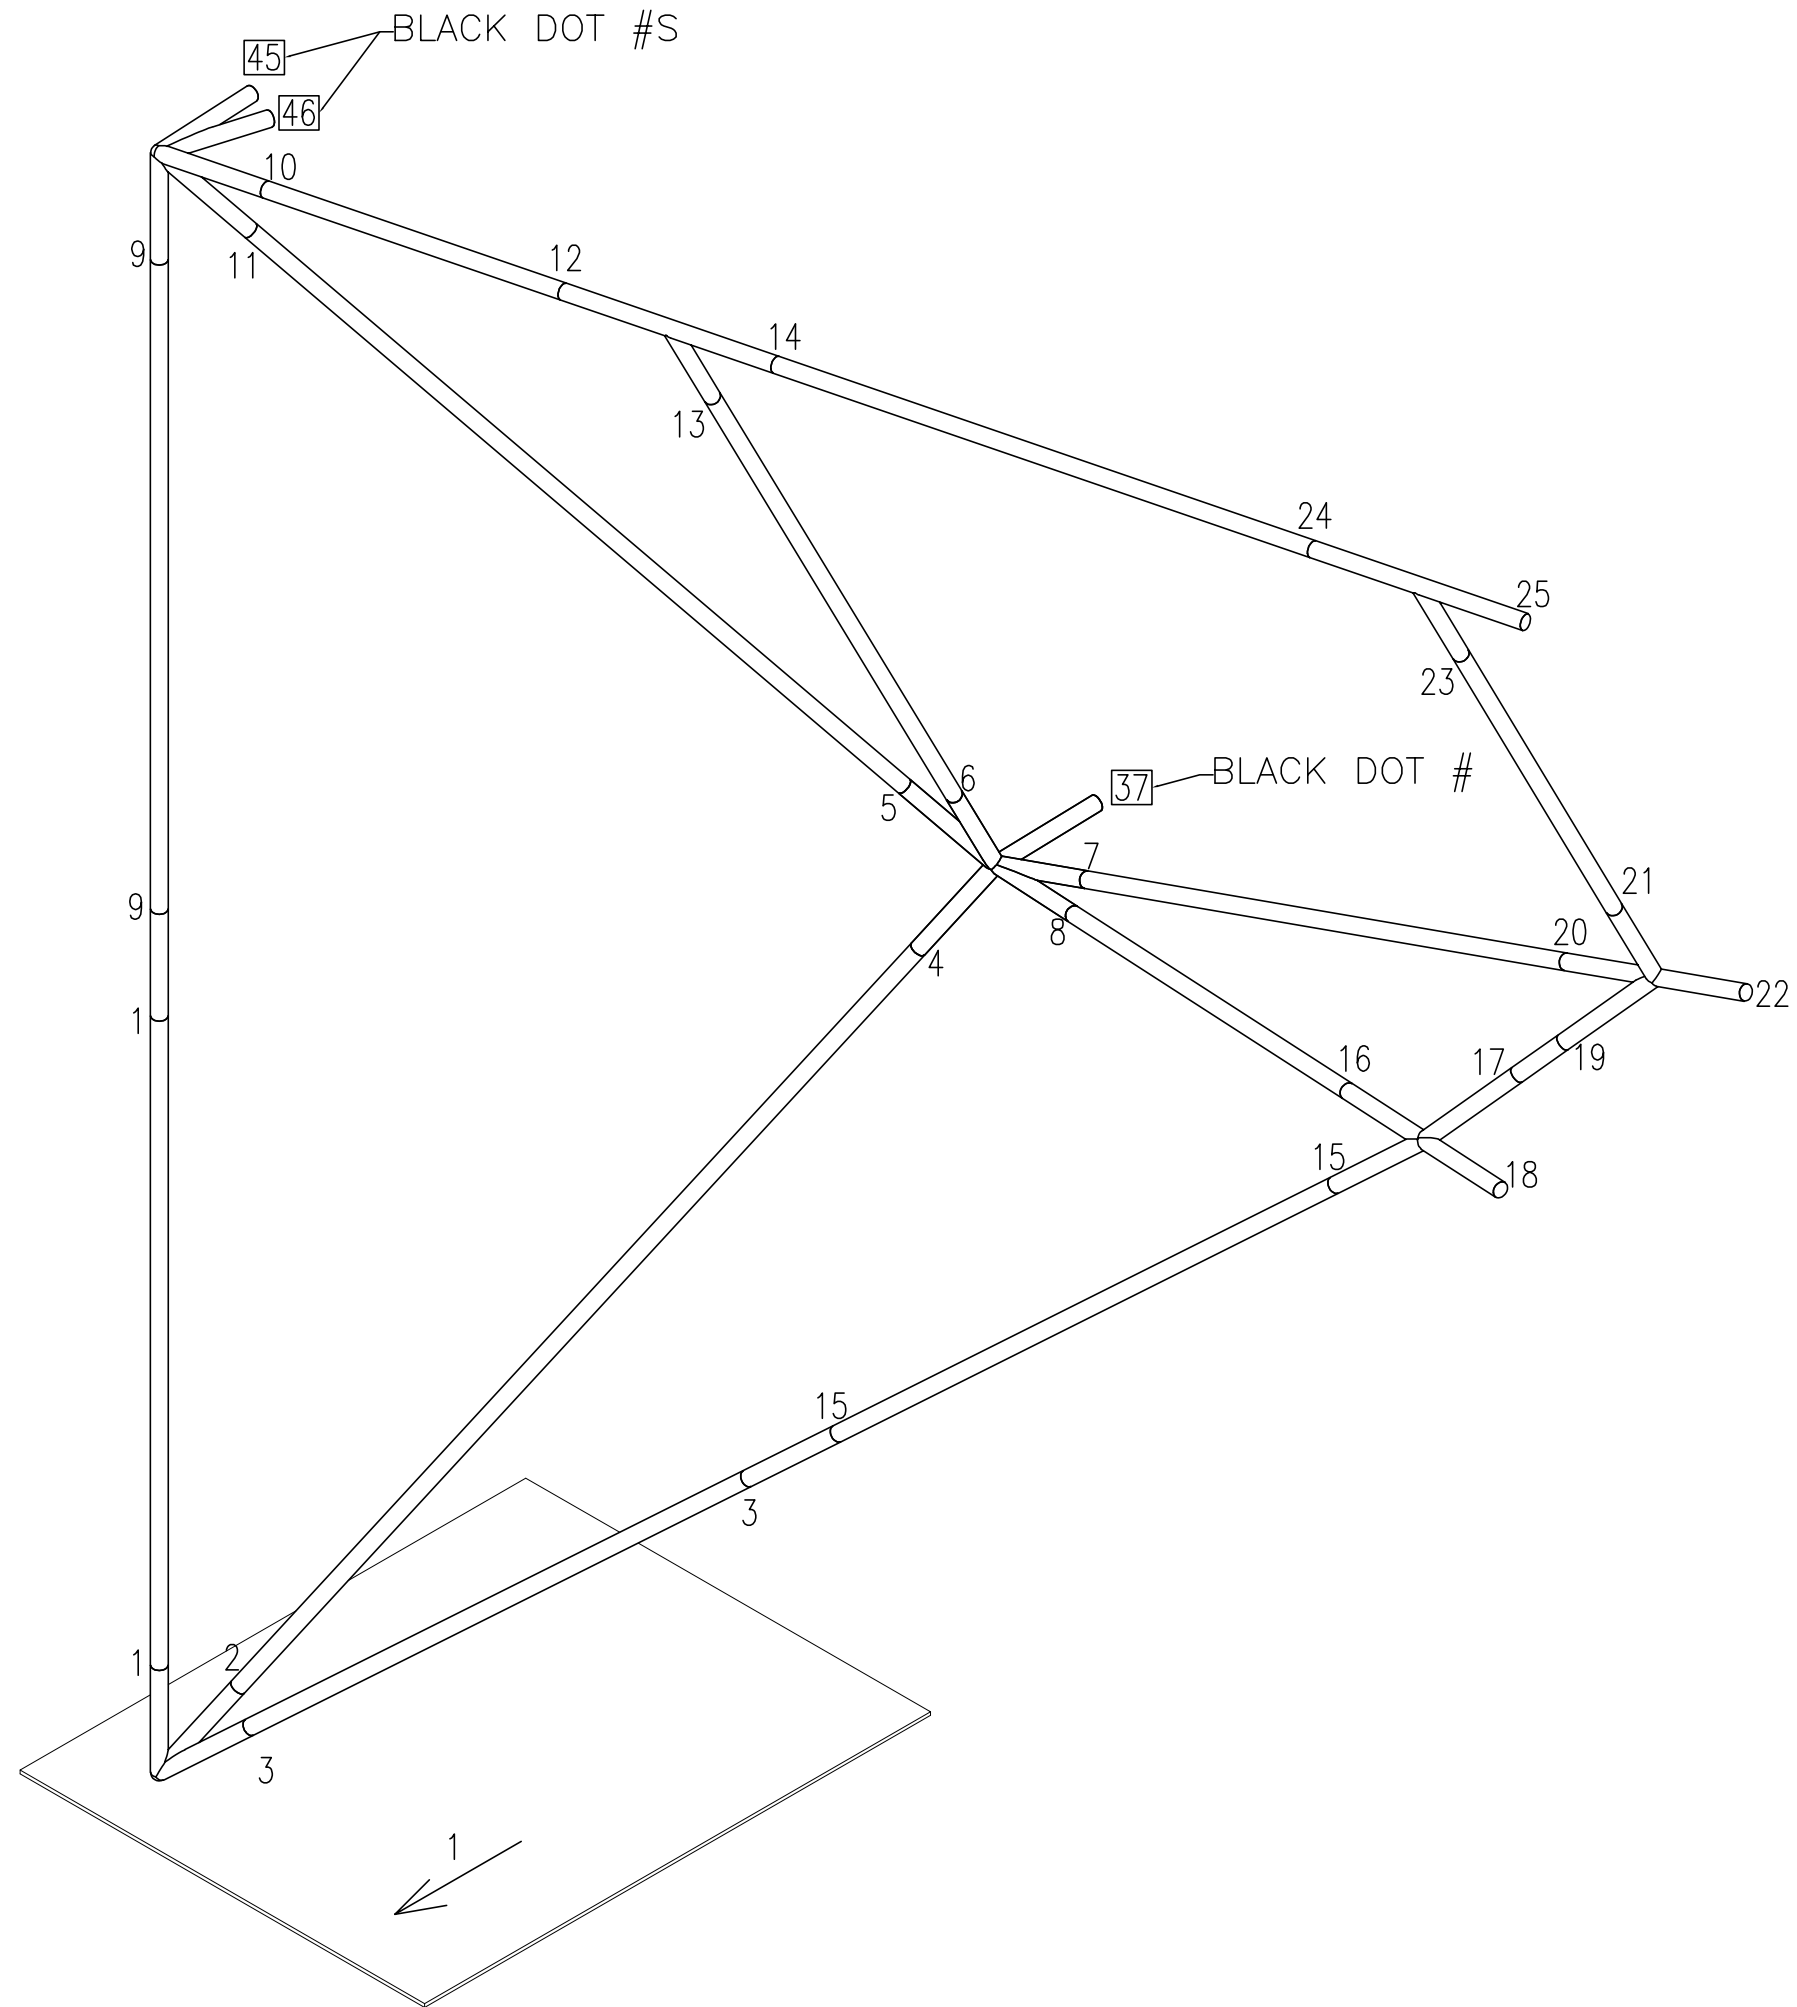

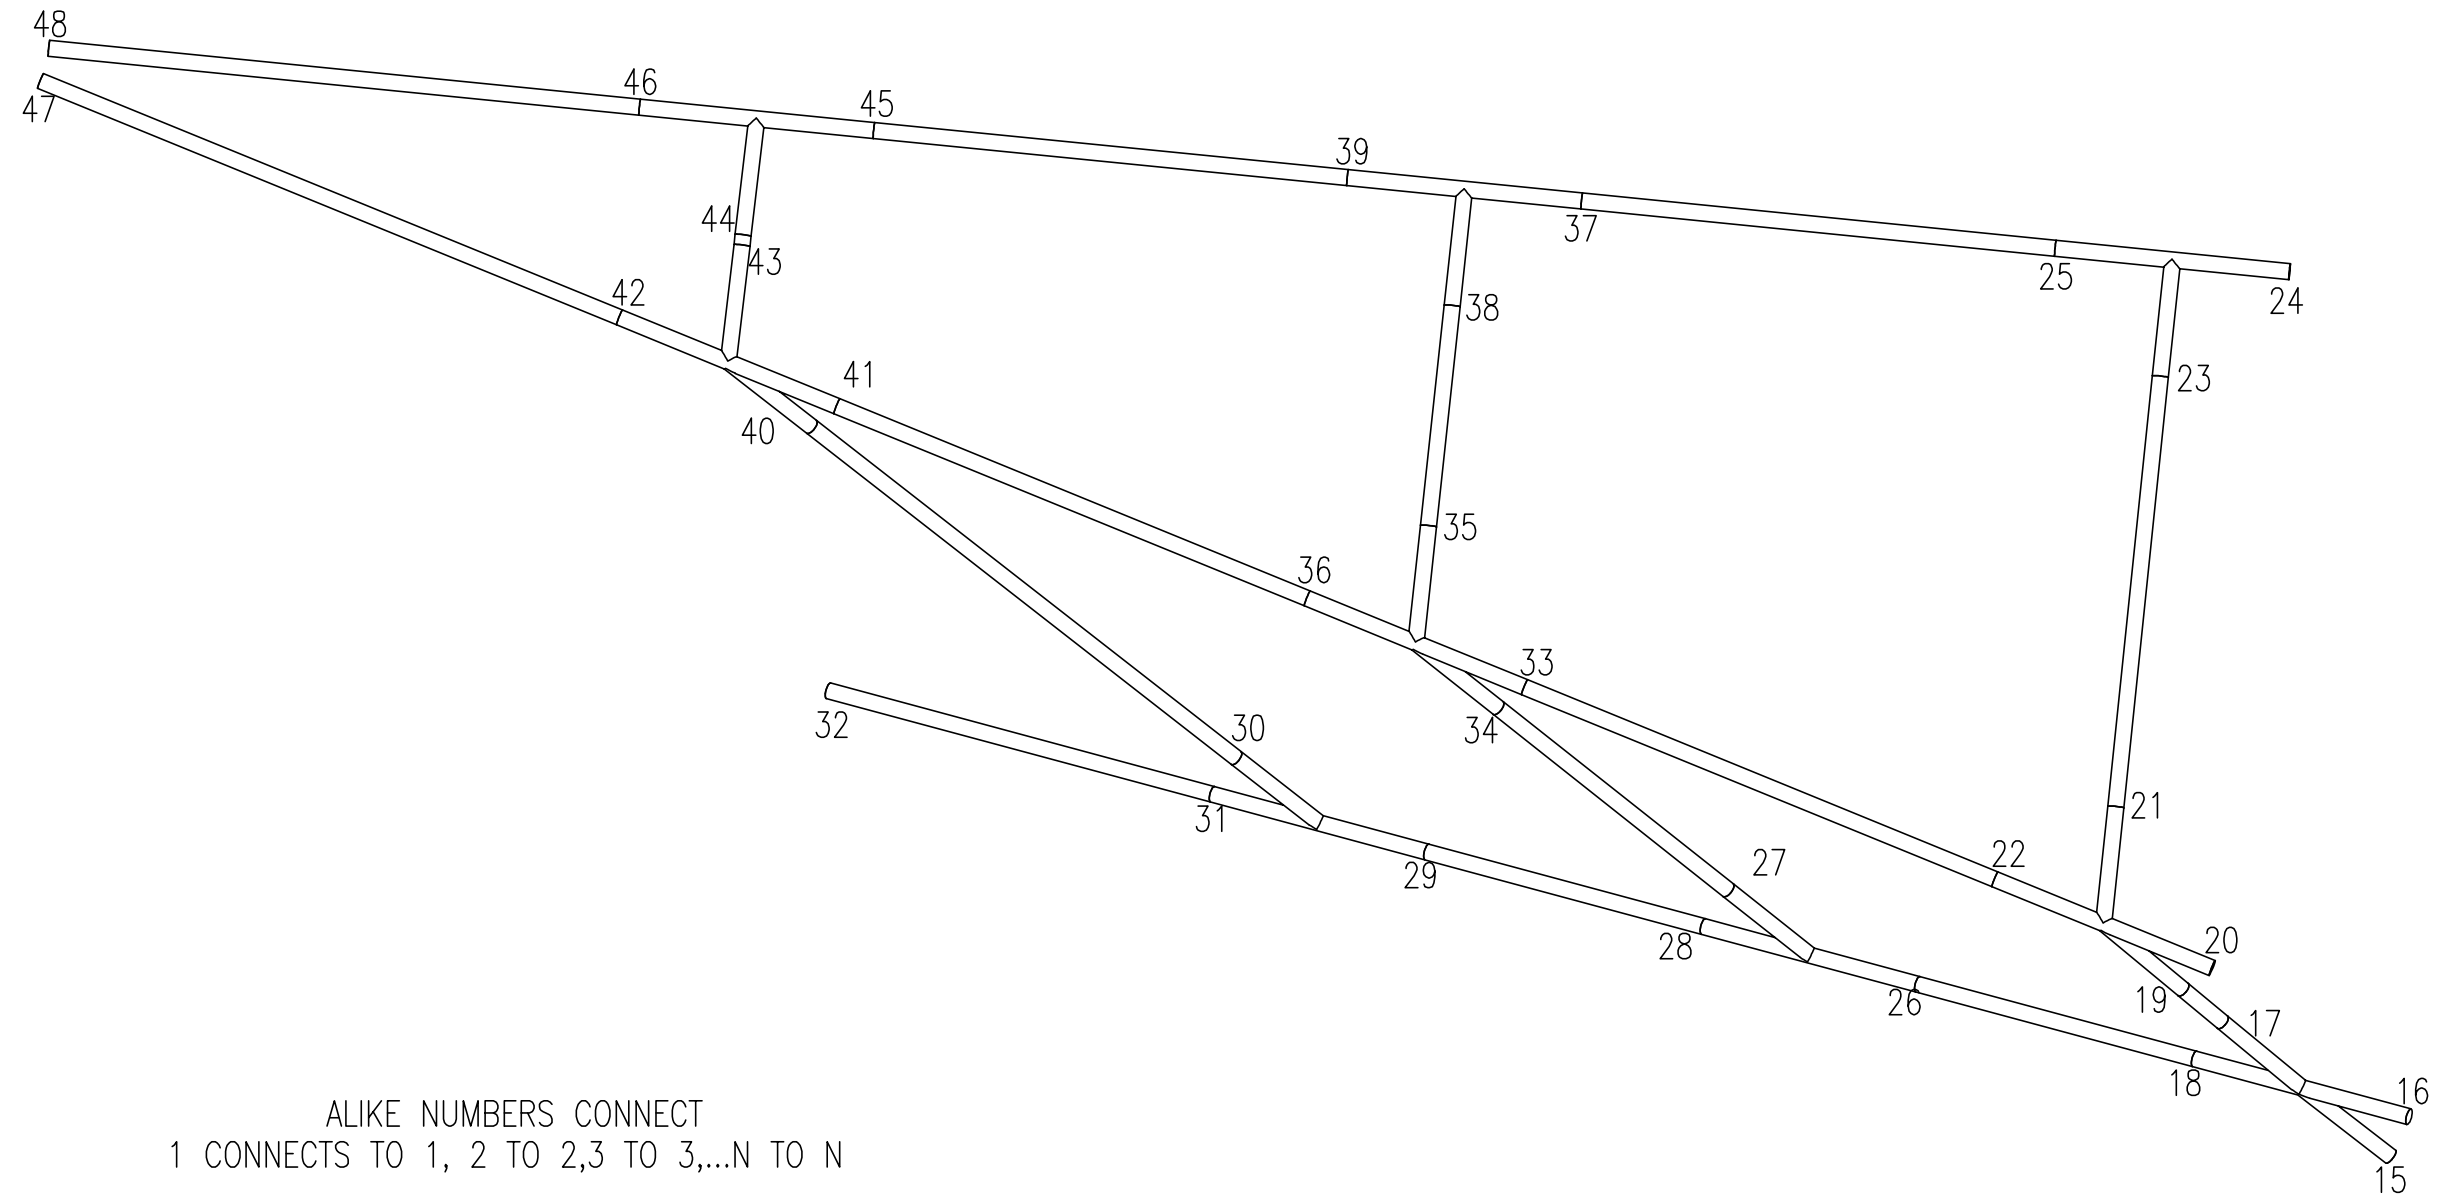

ALIKE NUMBERS CONNECT
 1 CONNECTS TO 1, 2 TO 2, 3 TO 3,...N TO N


RED DOTS

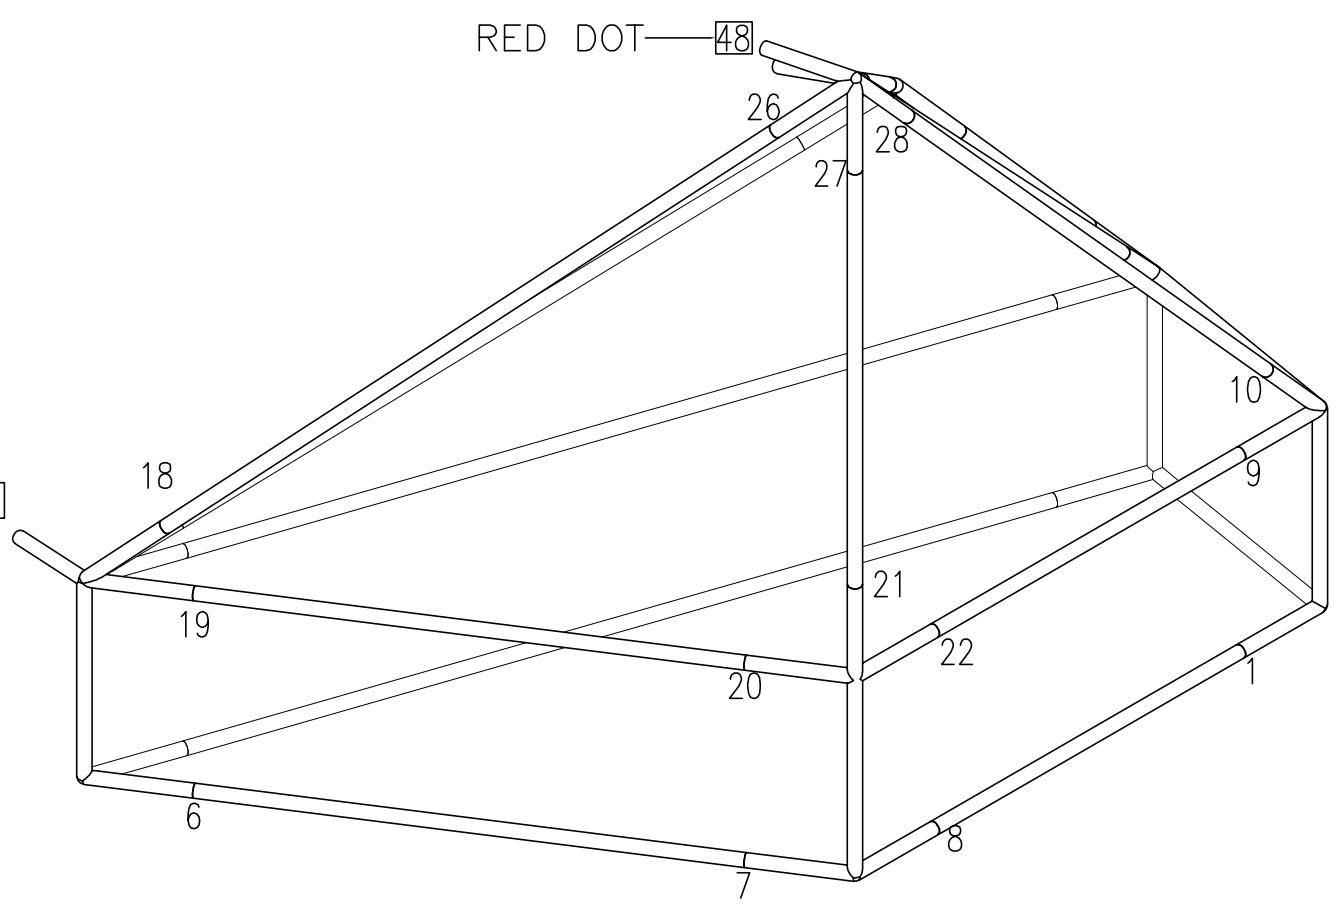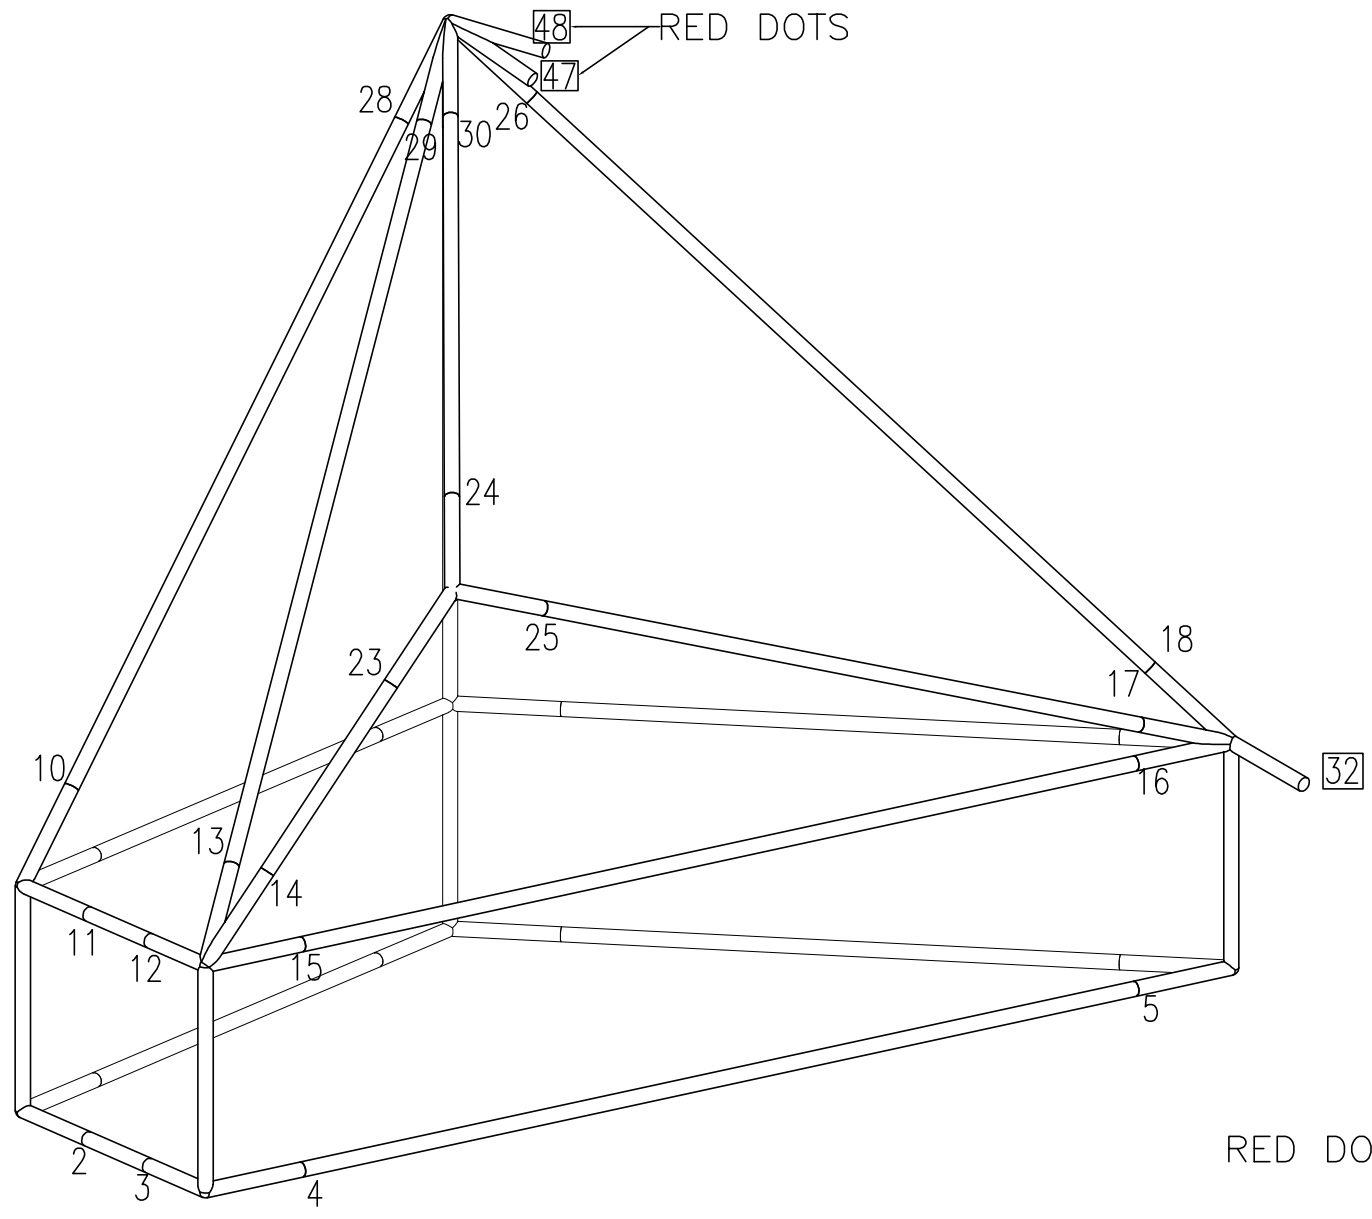


ALIKE NUMBERS CONNECT
 1 CONNECTS TO 1, 2 TO 2, 3 TO 3,...N TO N
 WHITE DOTS


ALIKE NUMBERS CONNECT
1 CONNECTS TO 1, 2 TO 2,3 TO 3,...N TO N


BLUE DOTS

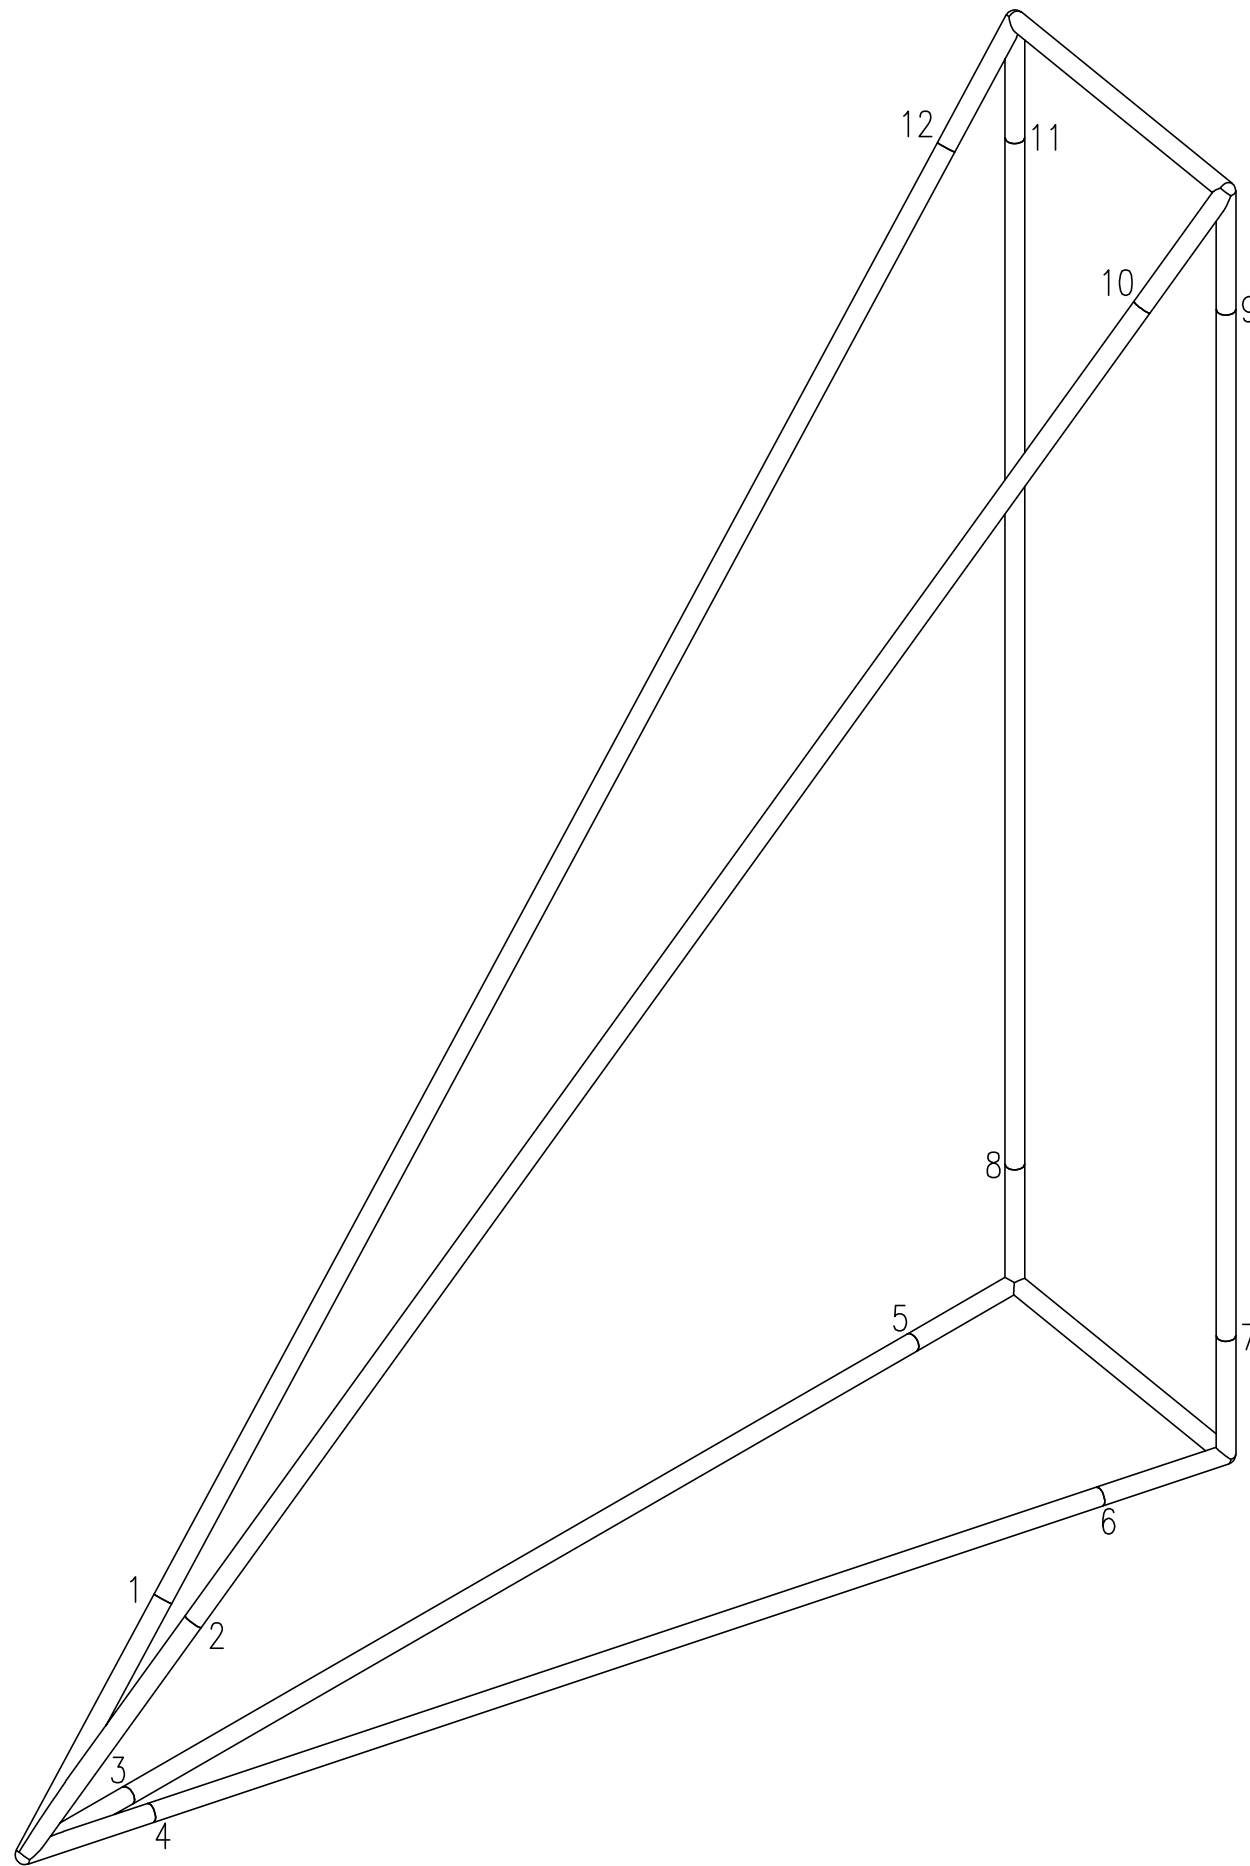

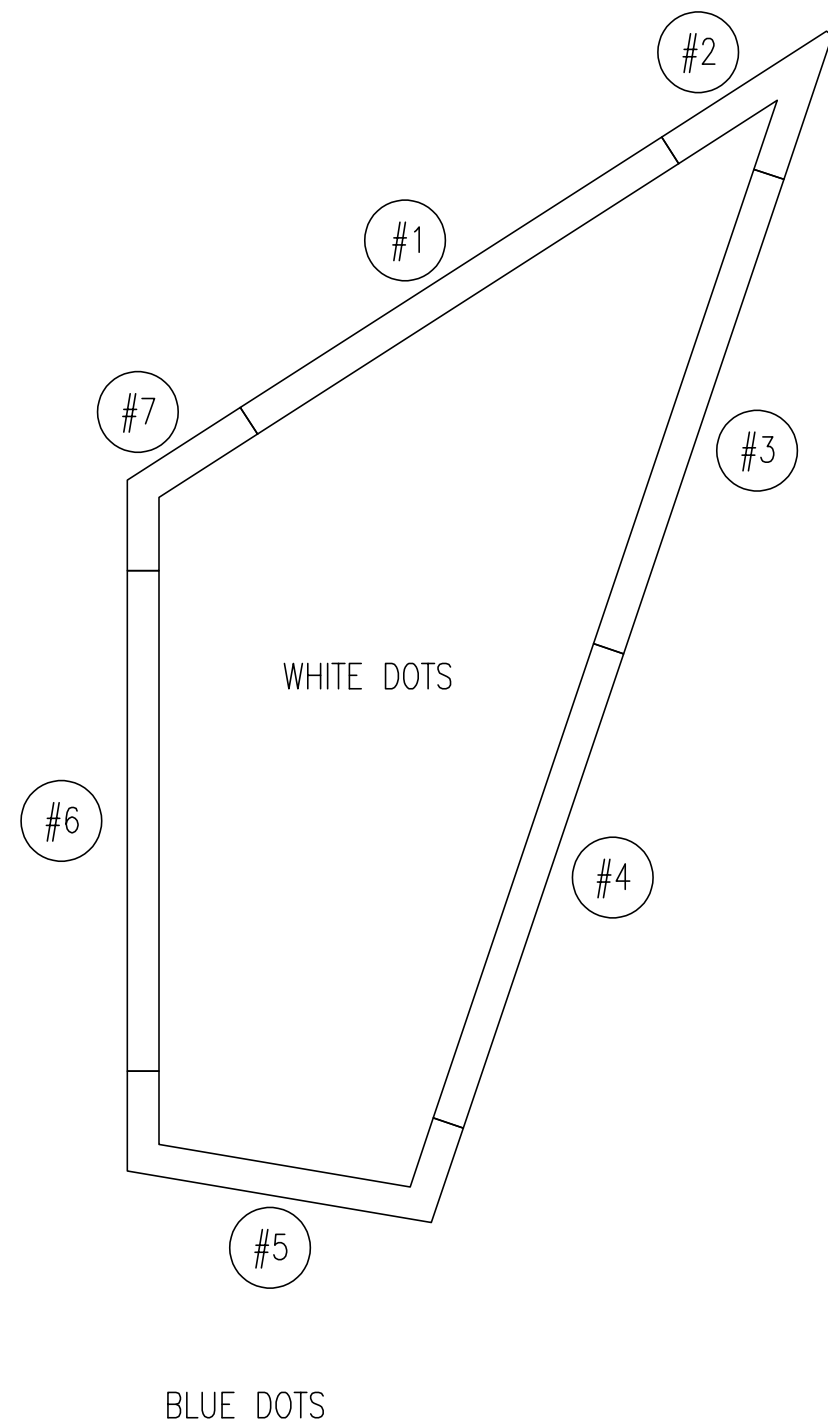

RED DOTS

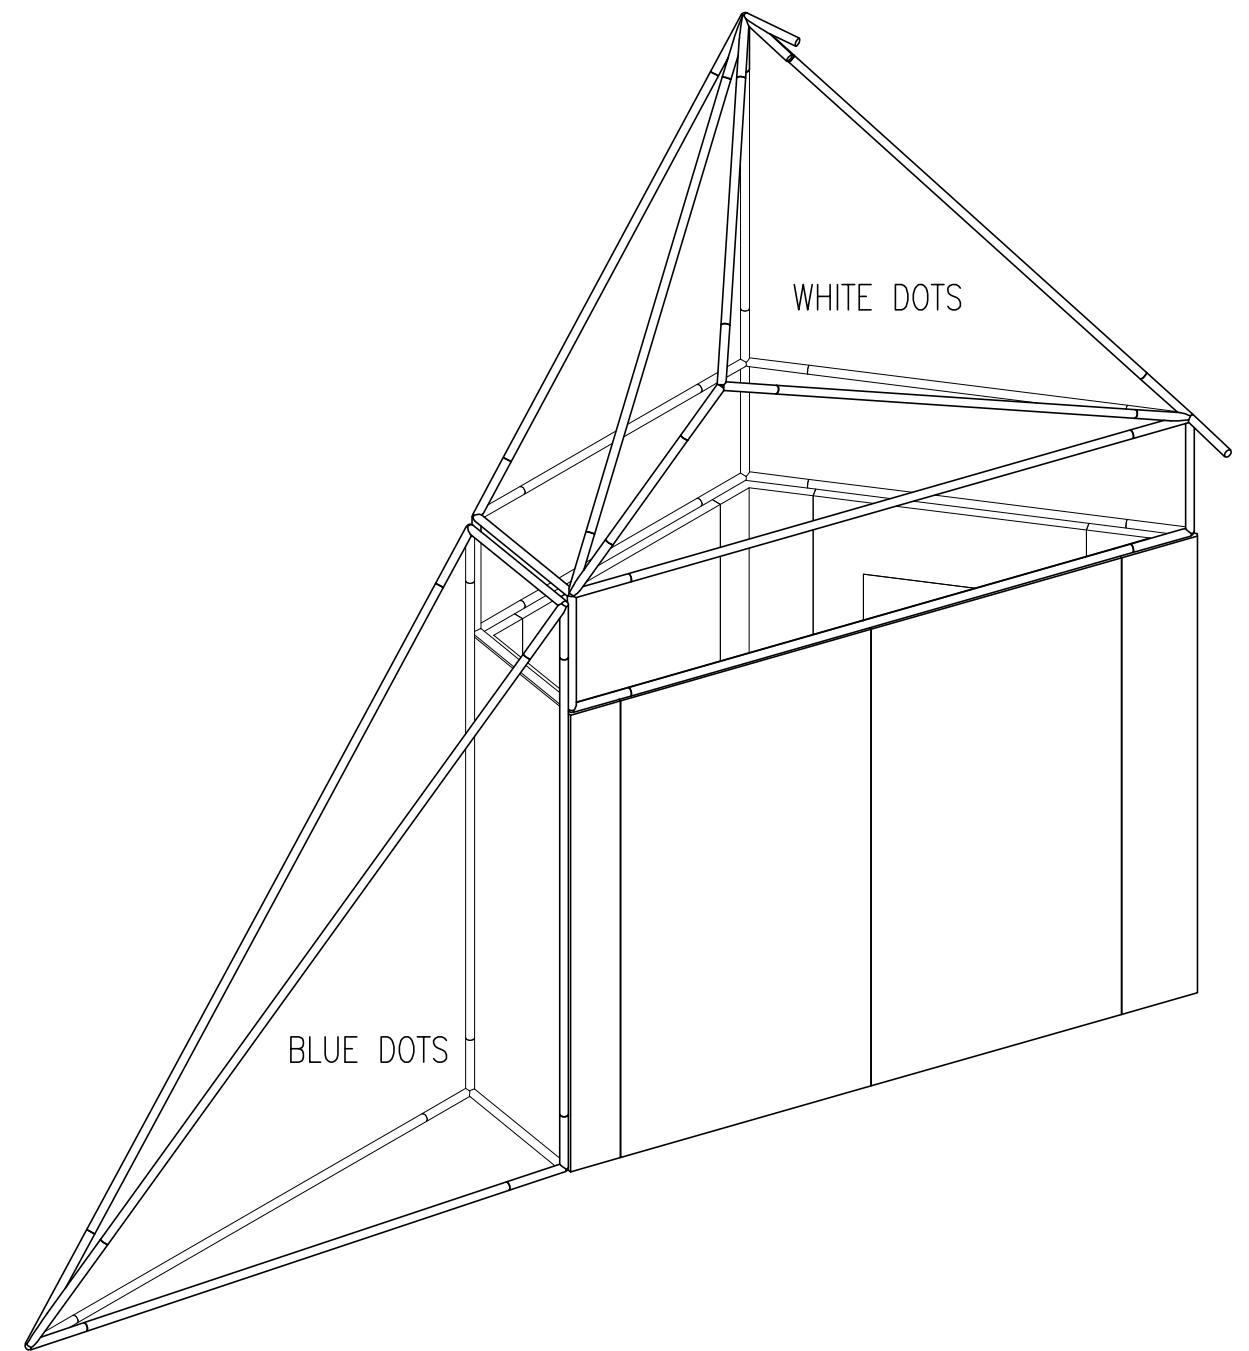

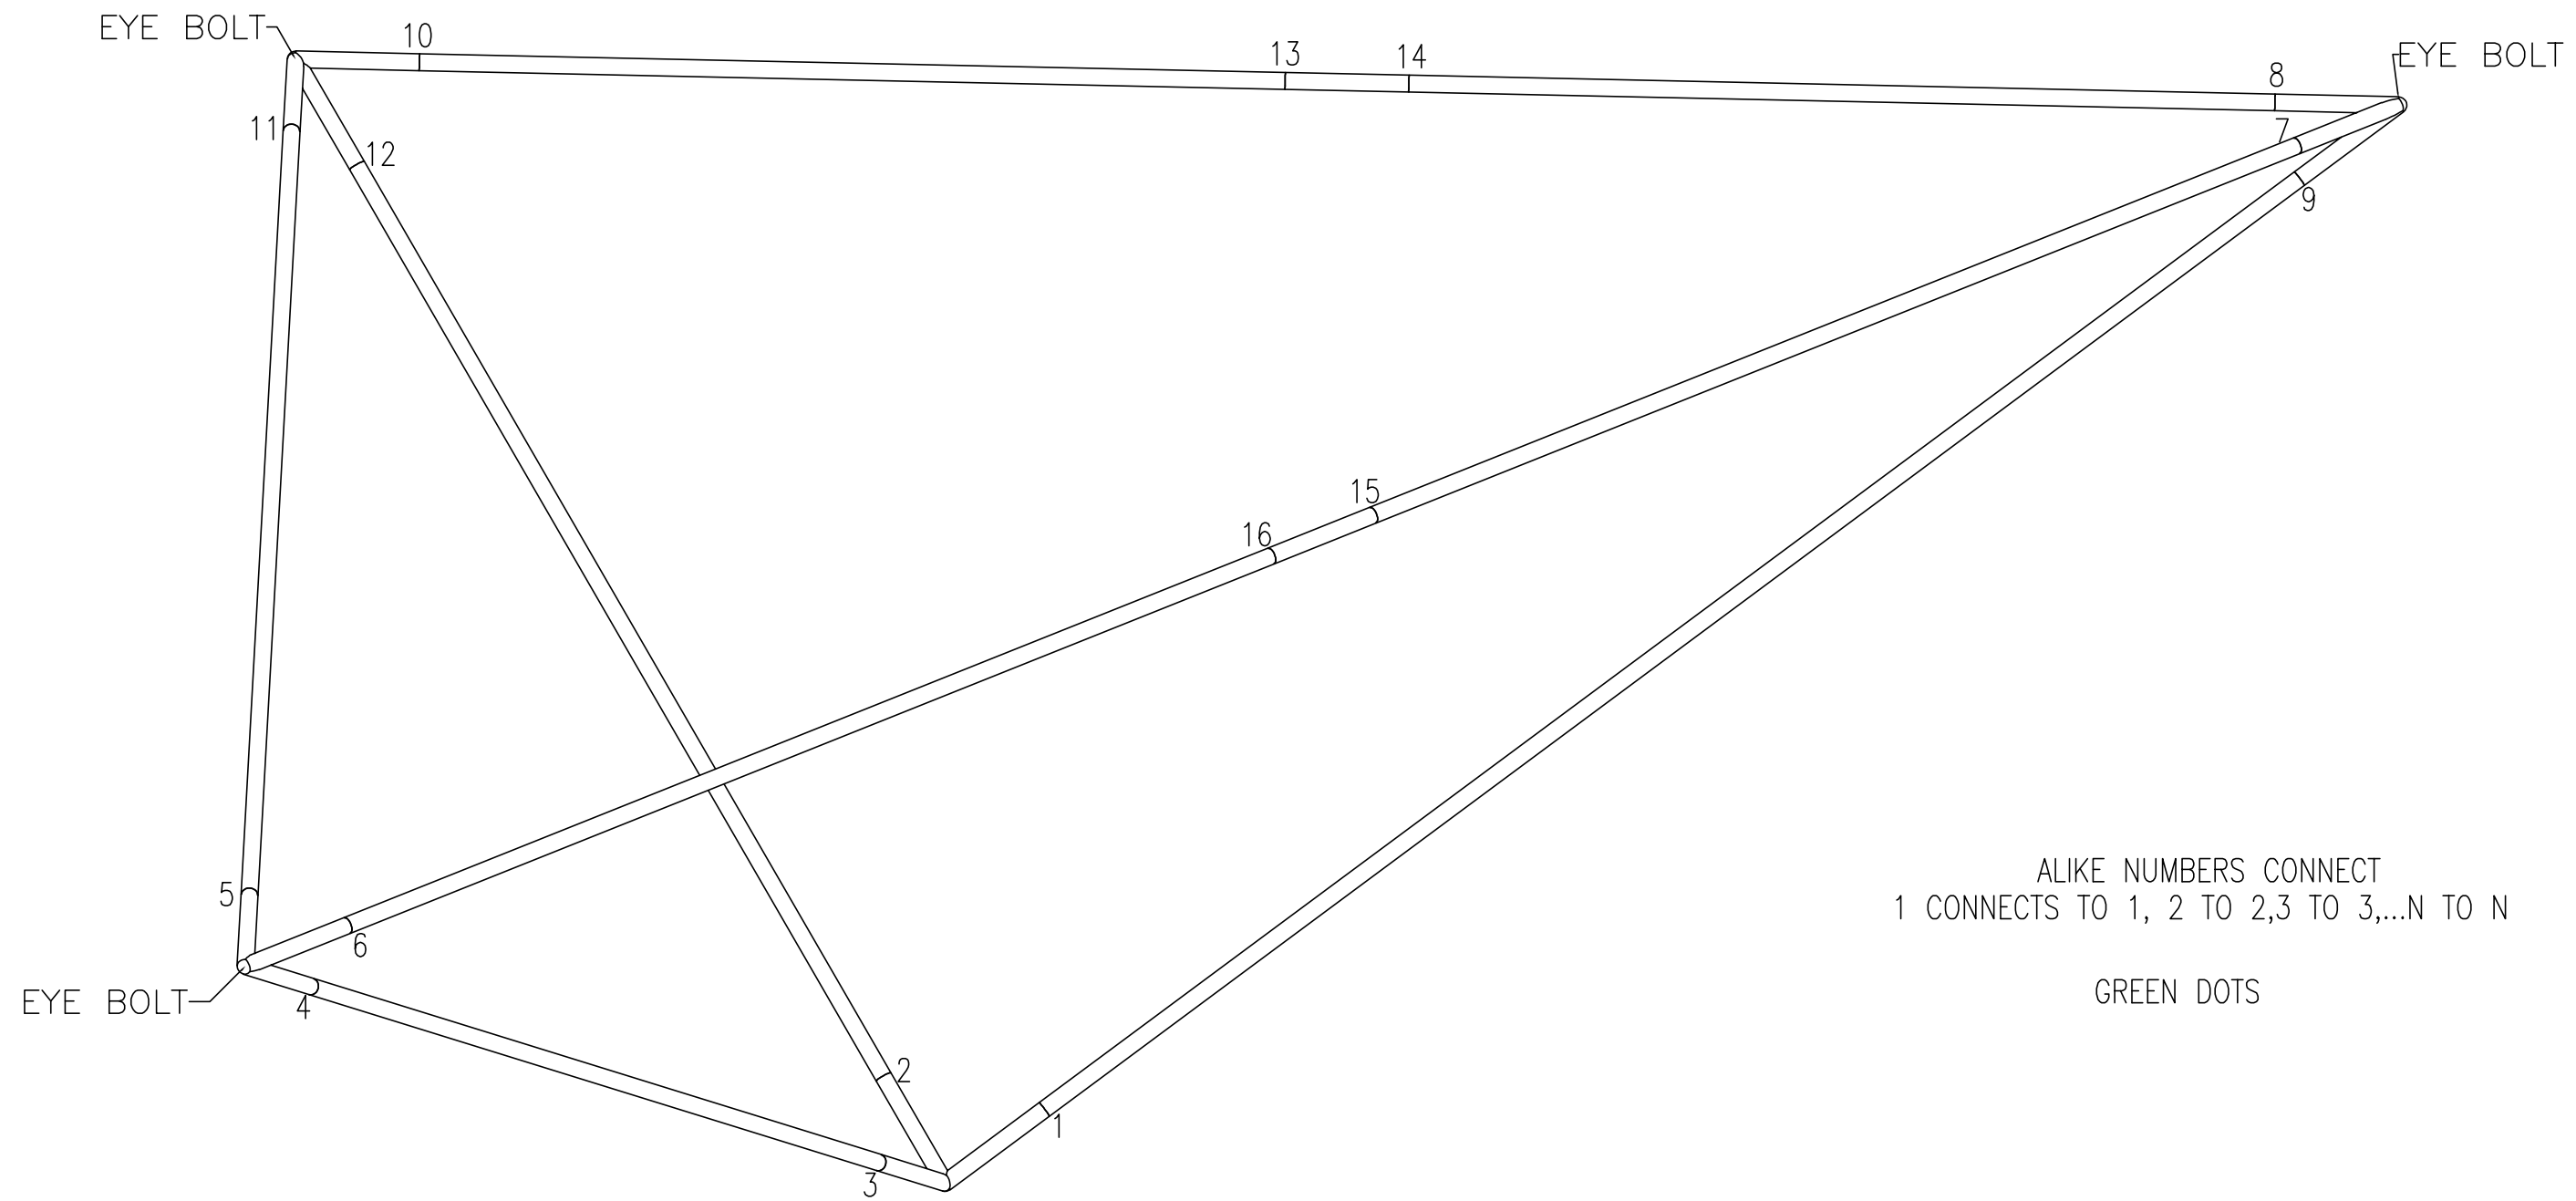

ALIKE NUMBERS CONNECT
 1 CONNECTS TO 1, 2 TO 2, 3 TO 3,...N TO N

GREEN DOTS