




SHOW SET	
Sheet Number	Sheet Title
1	COVER PAGE
2	ISOMETRIC VIEWS
3	FLOOR PLAN - ELEVATIONS
4	SHOWCASE - BACKWALL ELEVATION
5	ELECTRICAL PLAN
6	CARPET - PADDING PLAN
7	SETUPS_BACKWALL_COLUMN_HEADER
8	SETUPS FURNITURE PRIVACY WALL

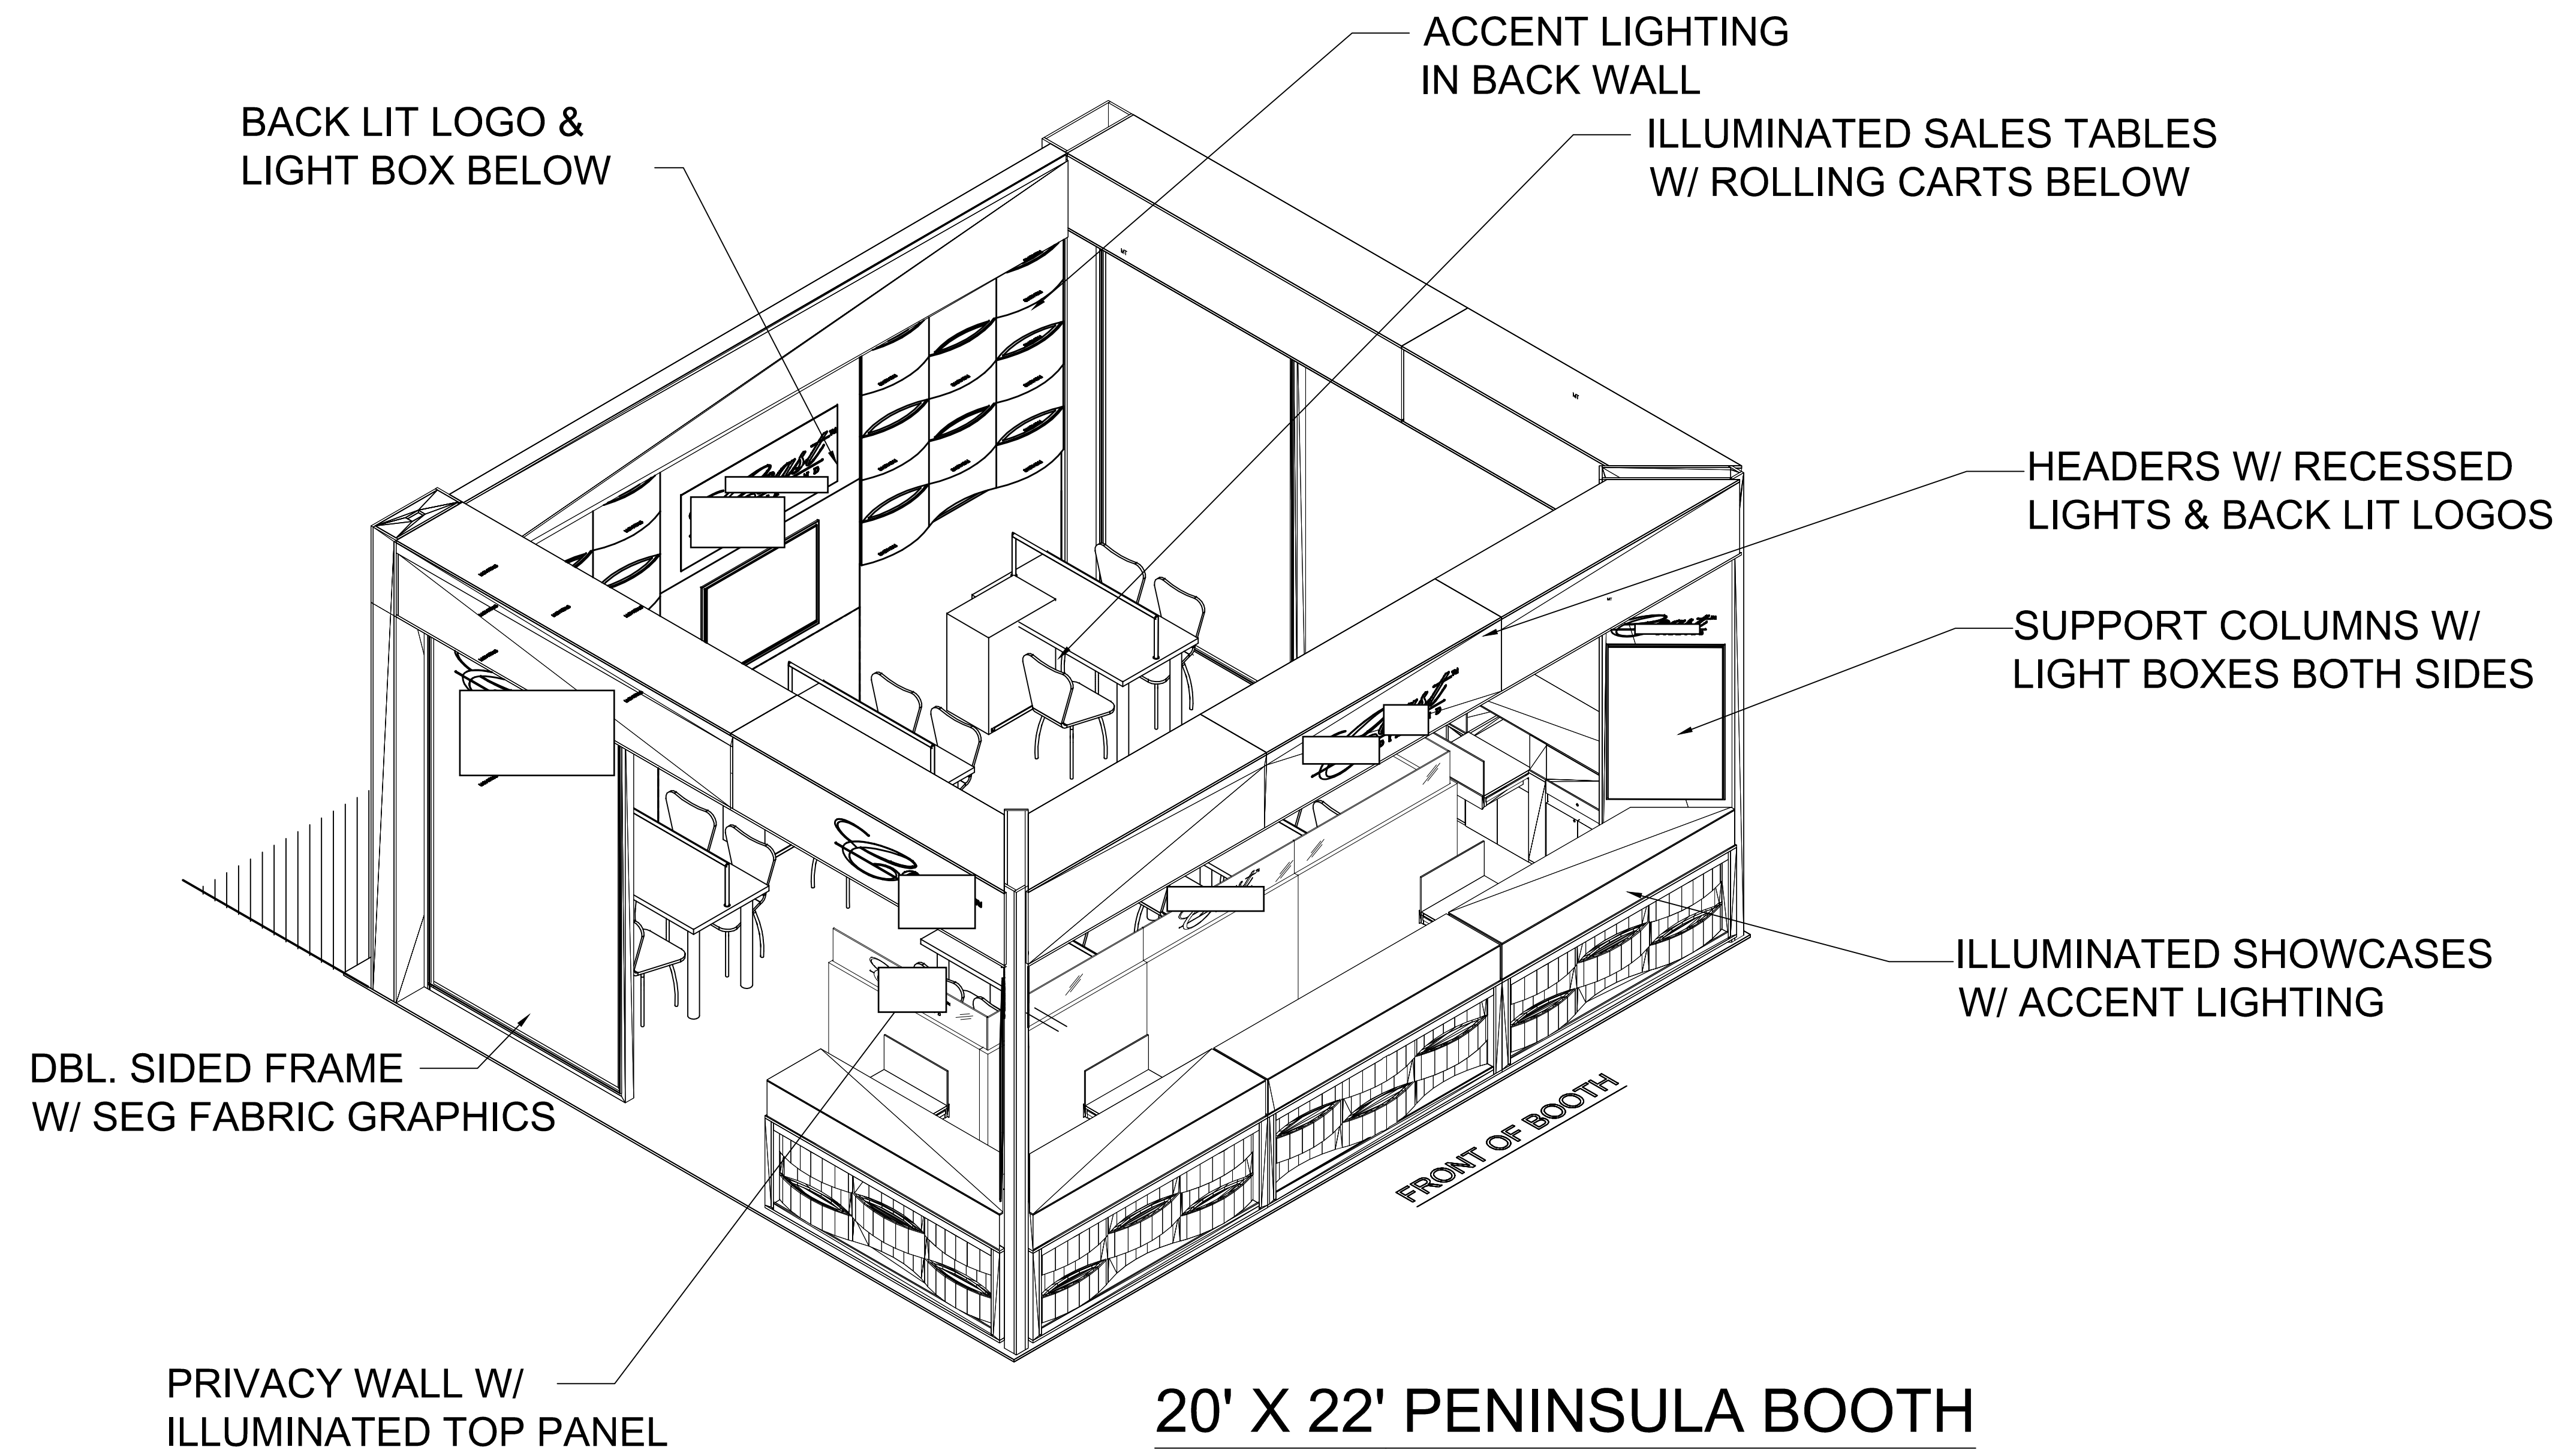


ISOMETRIC VIEW

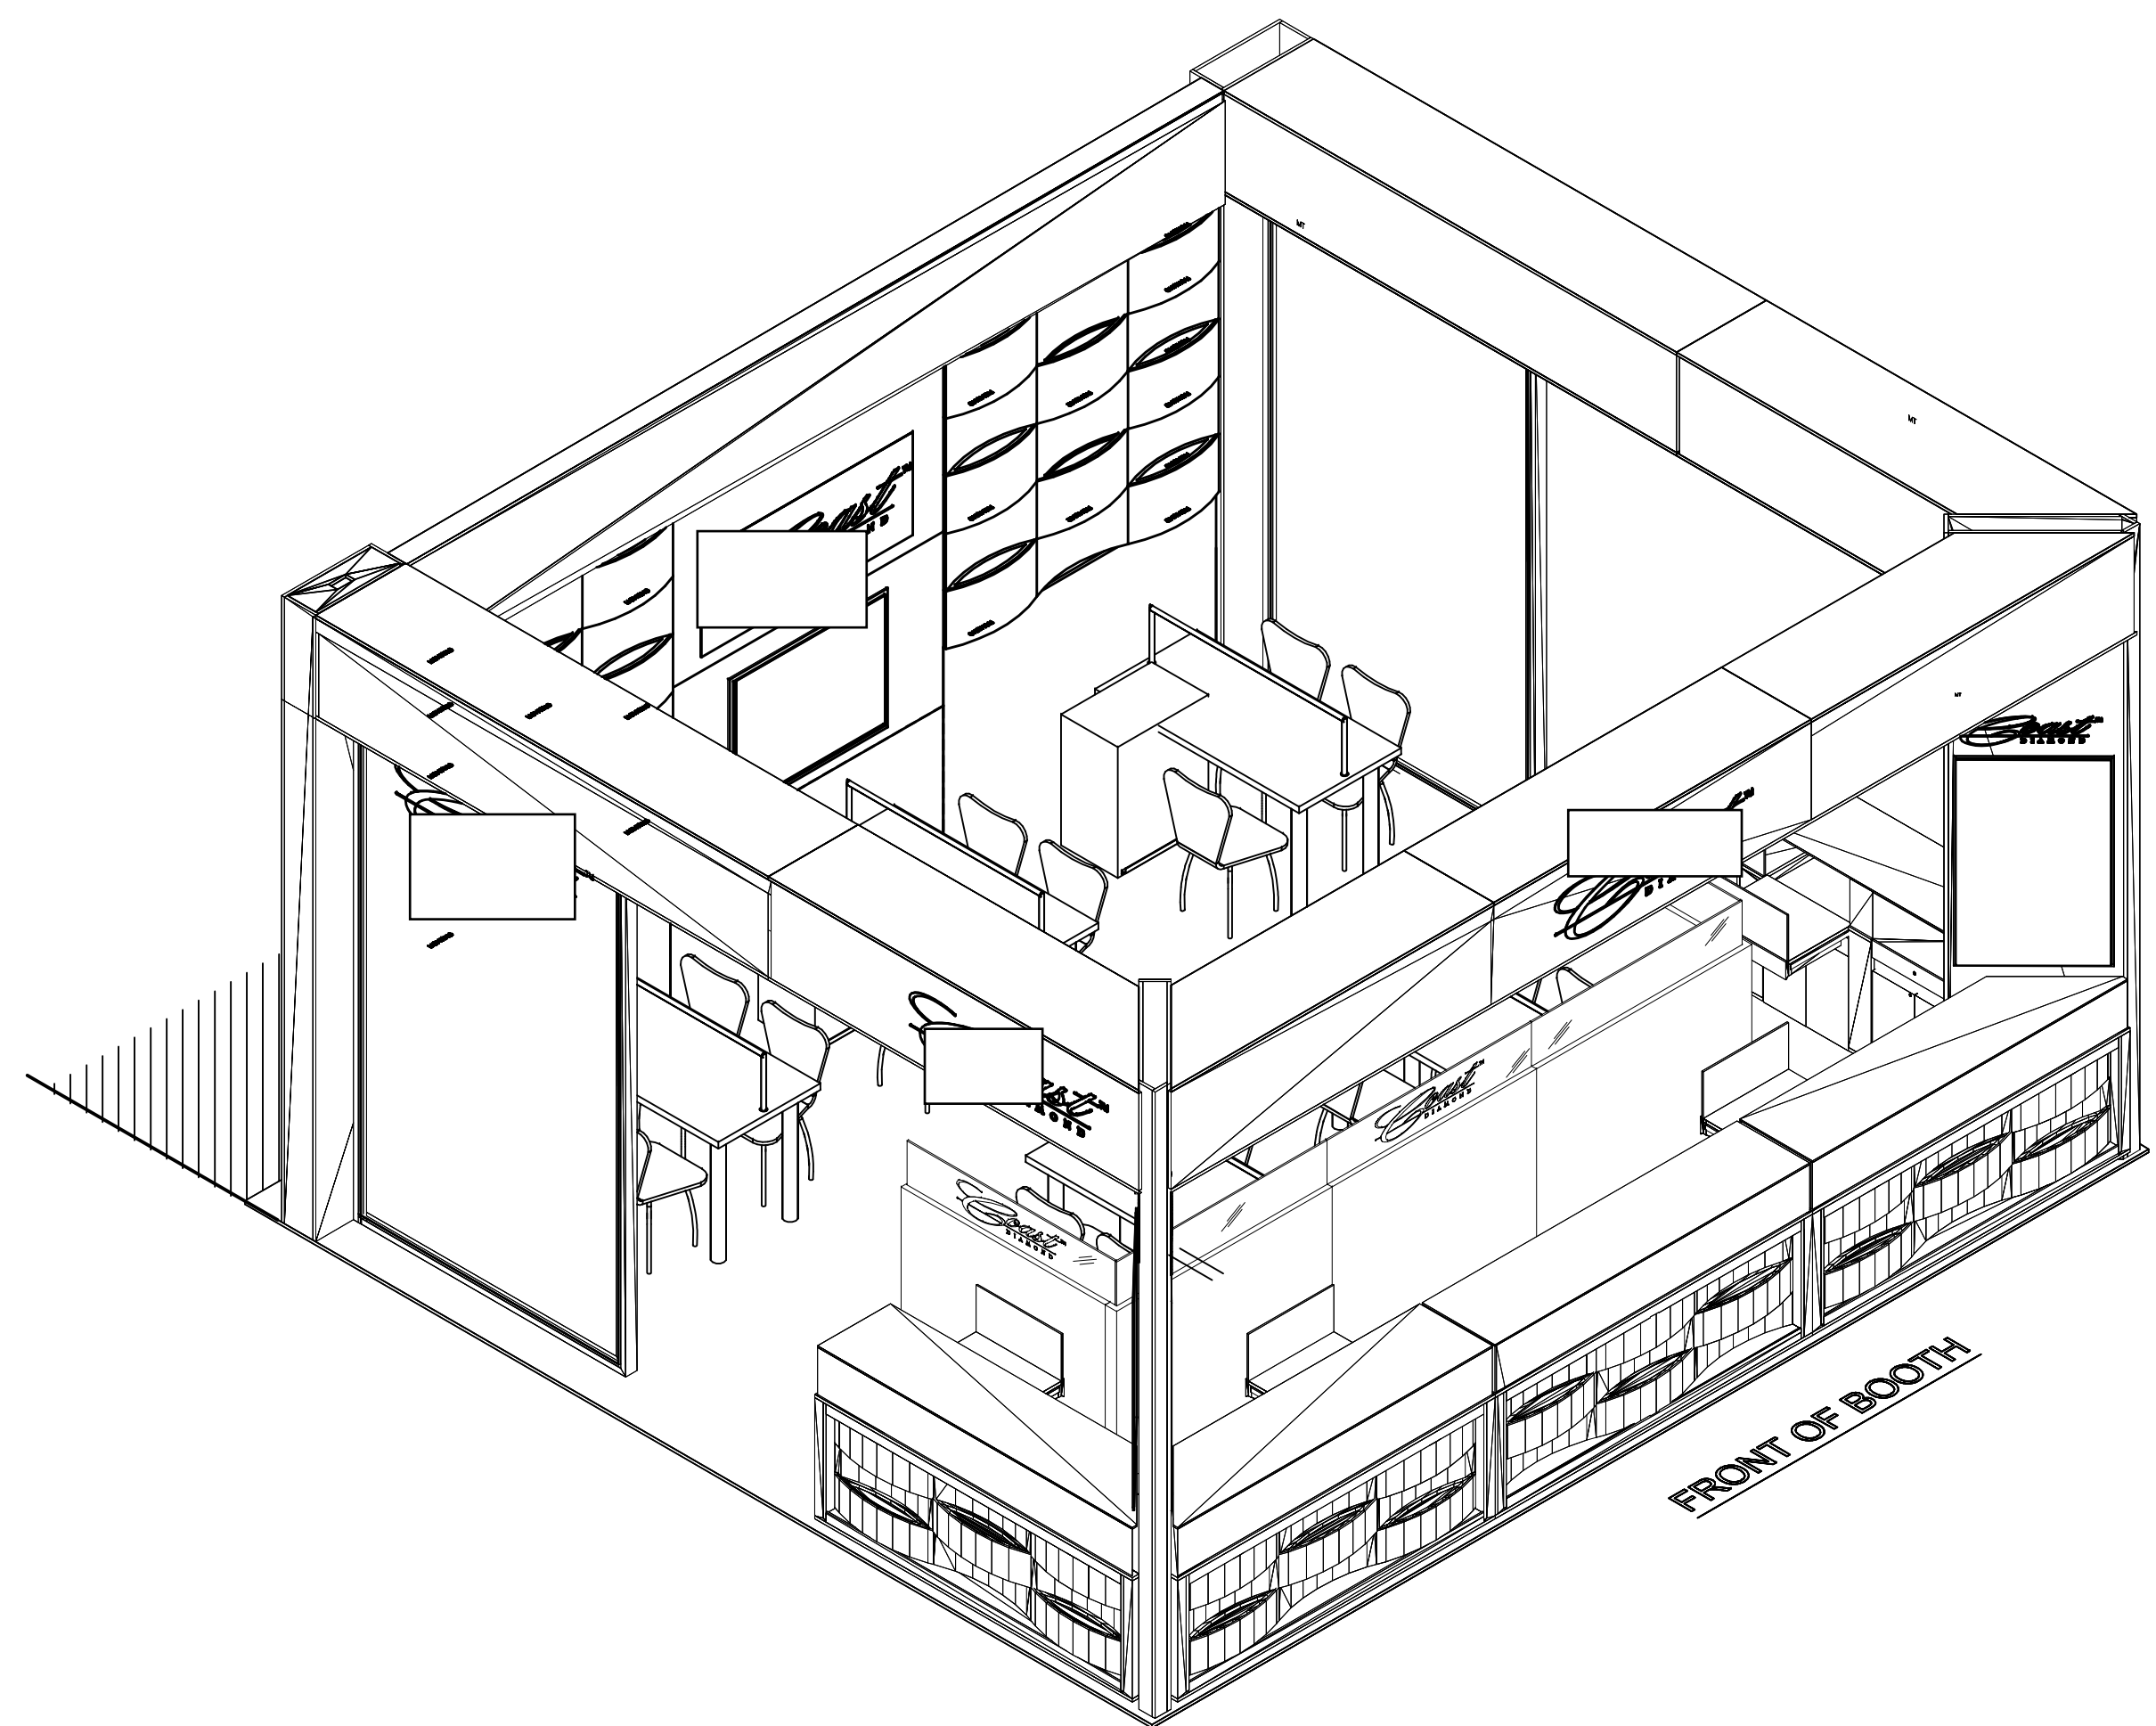

1 FRONT ISOMETRIC
SCALE: NTS

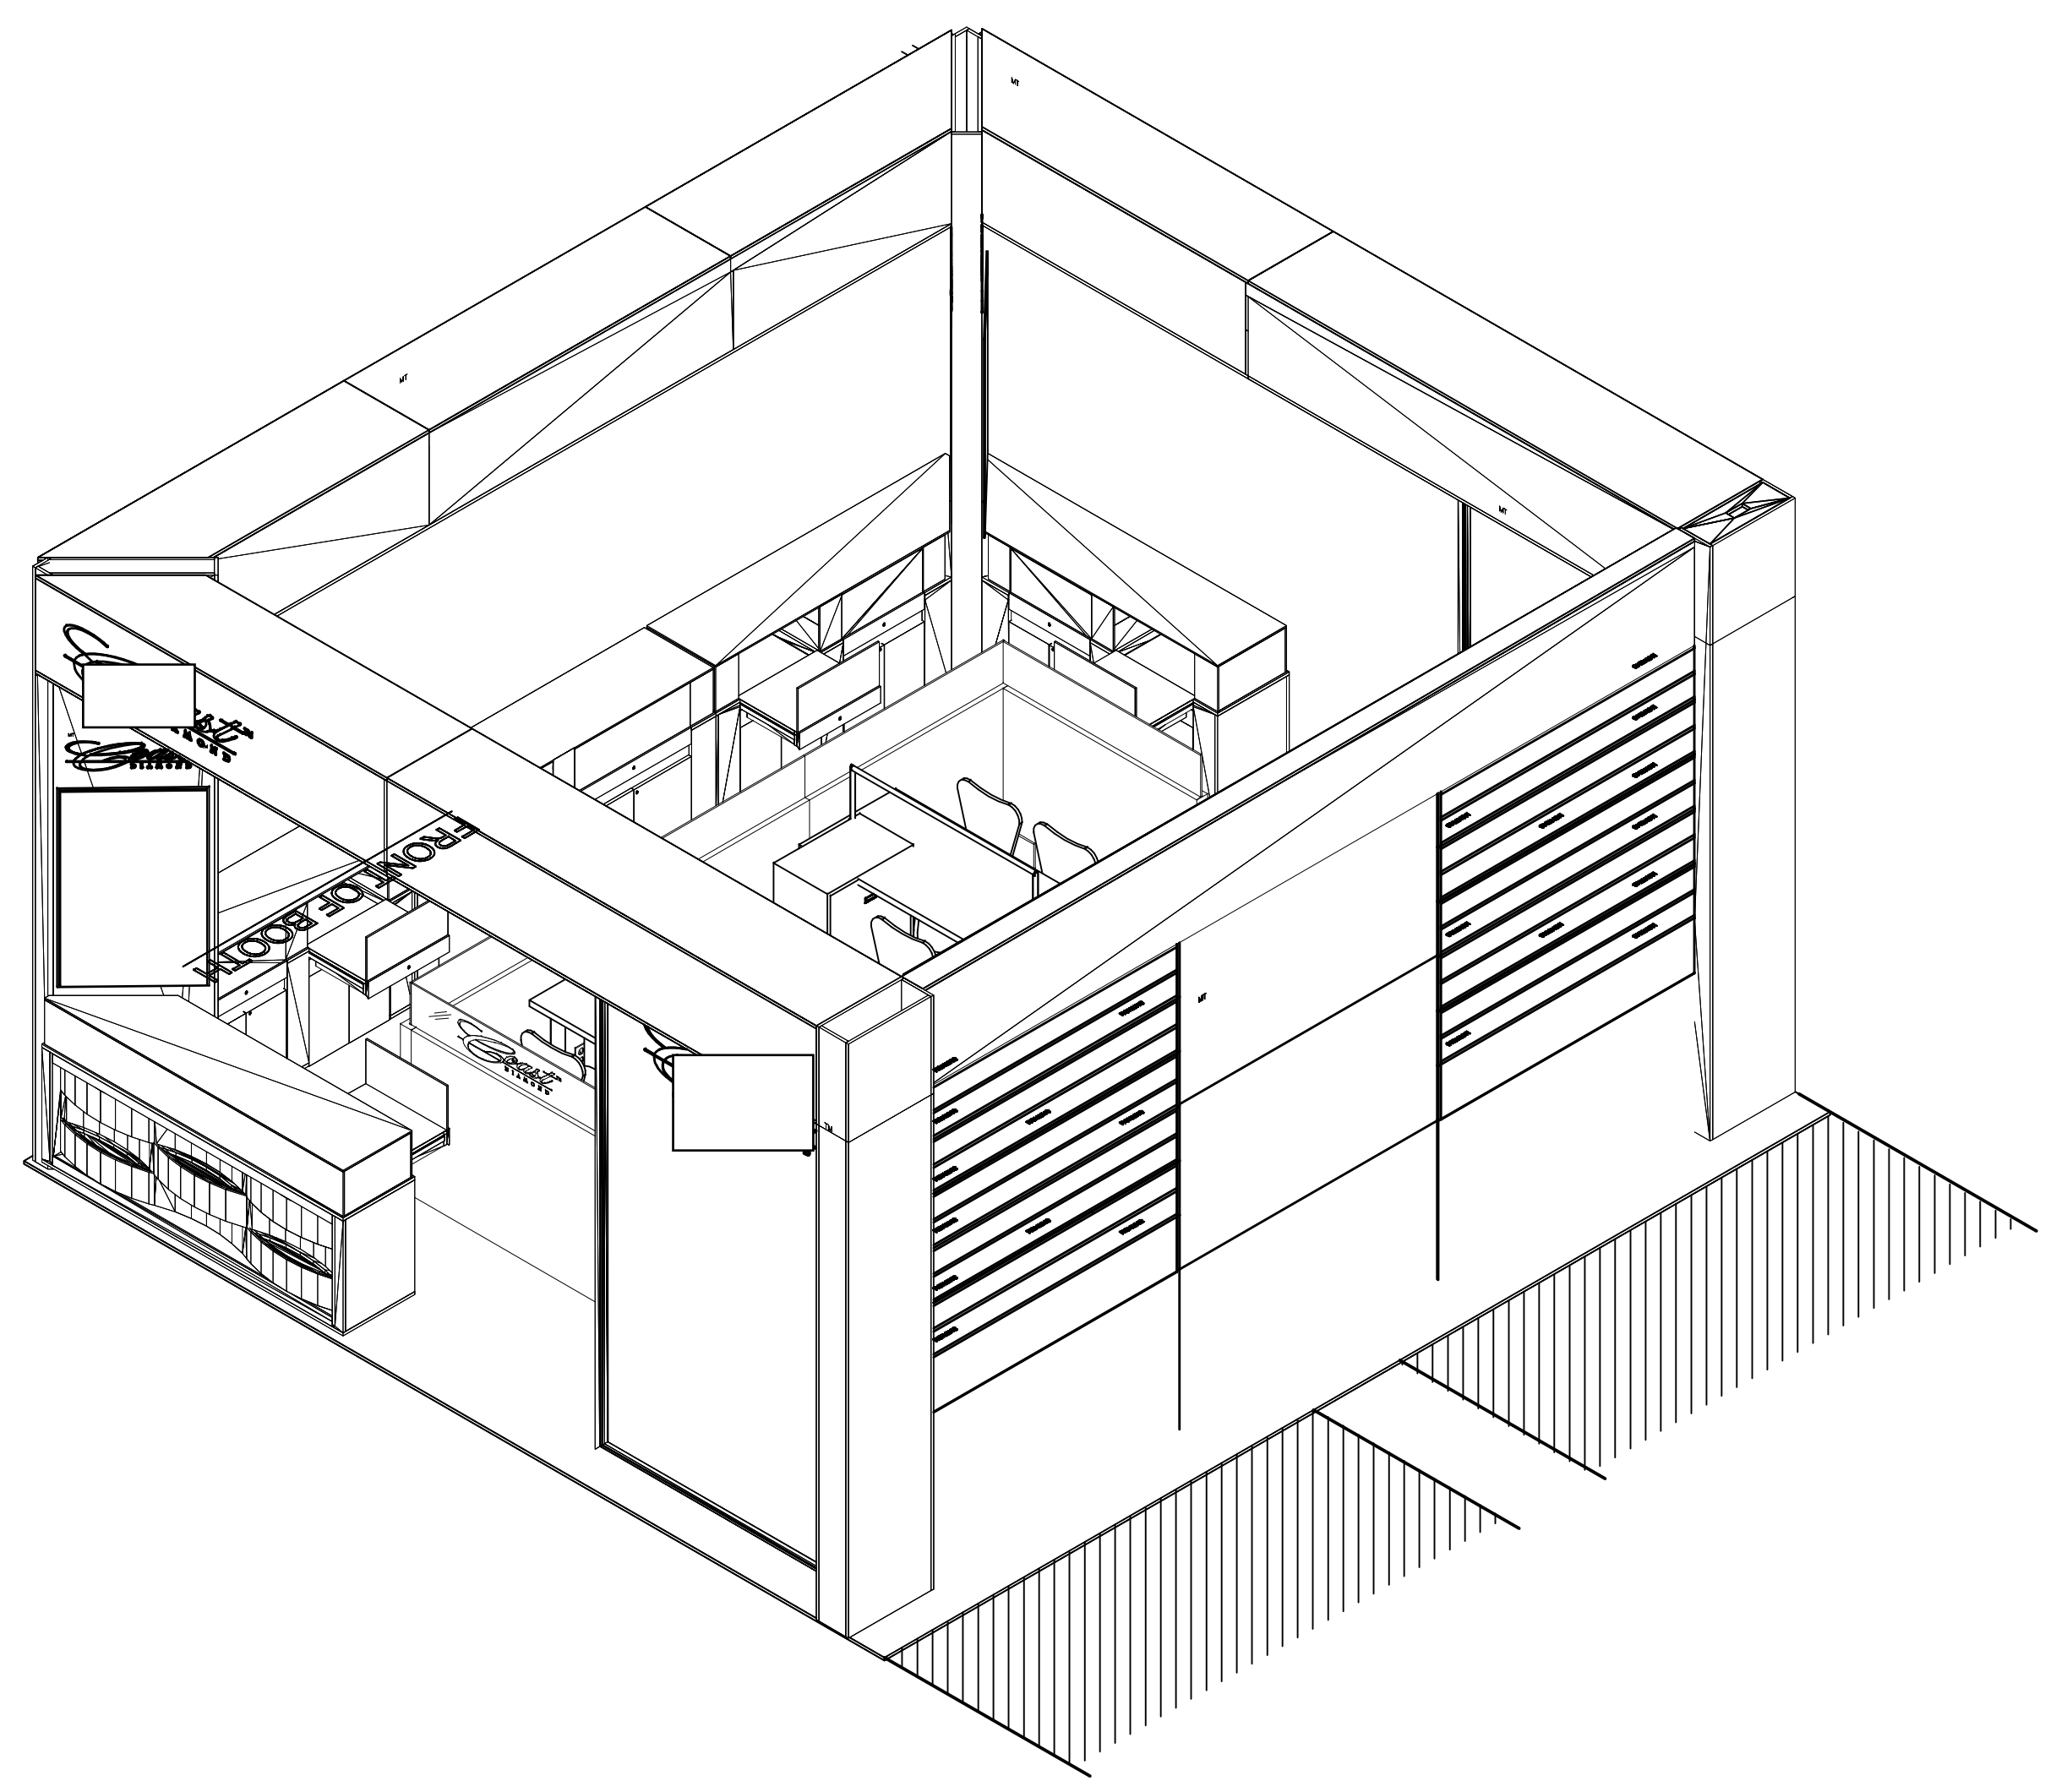

2 REAR ISOMETRIC
SCALE: NTS

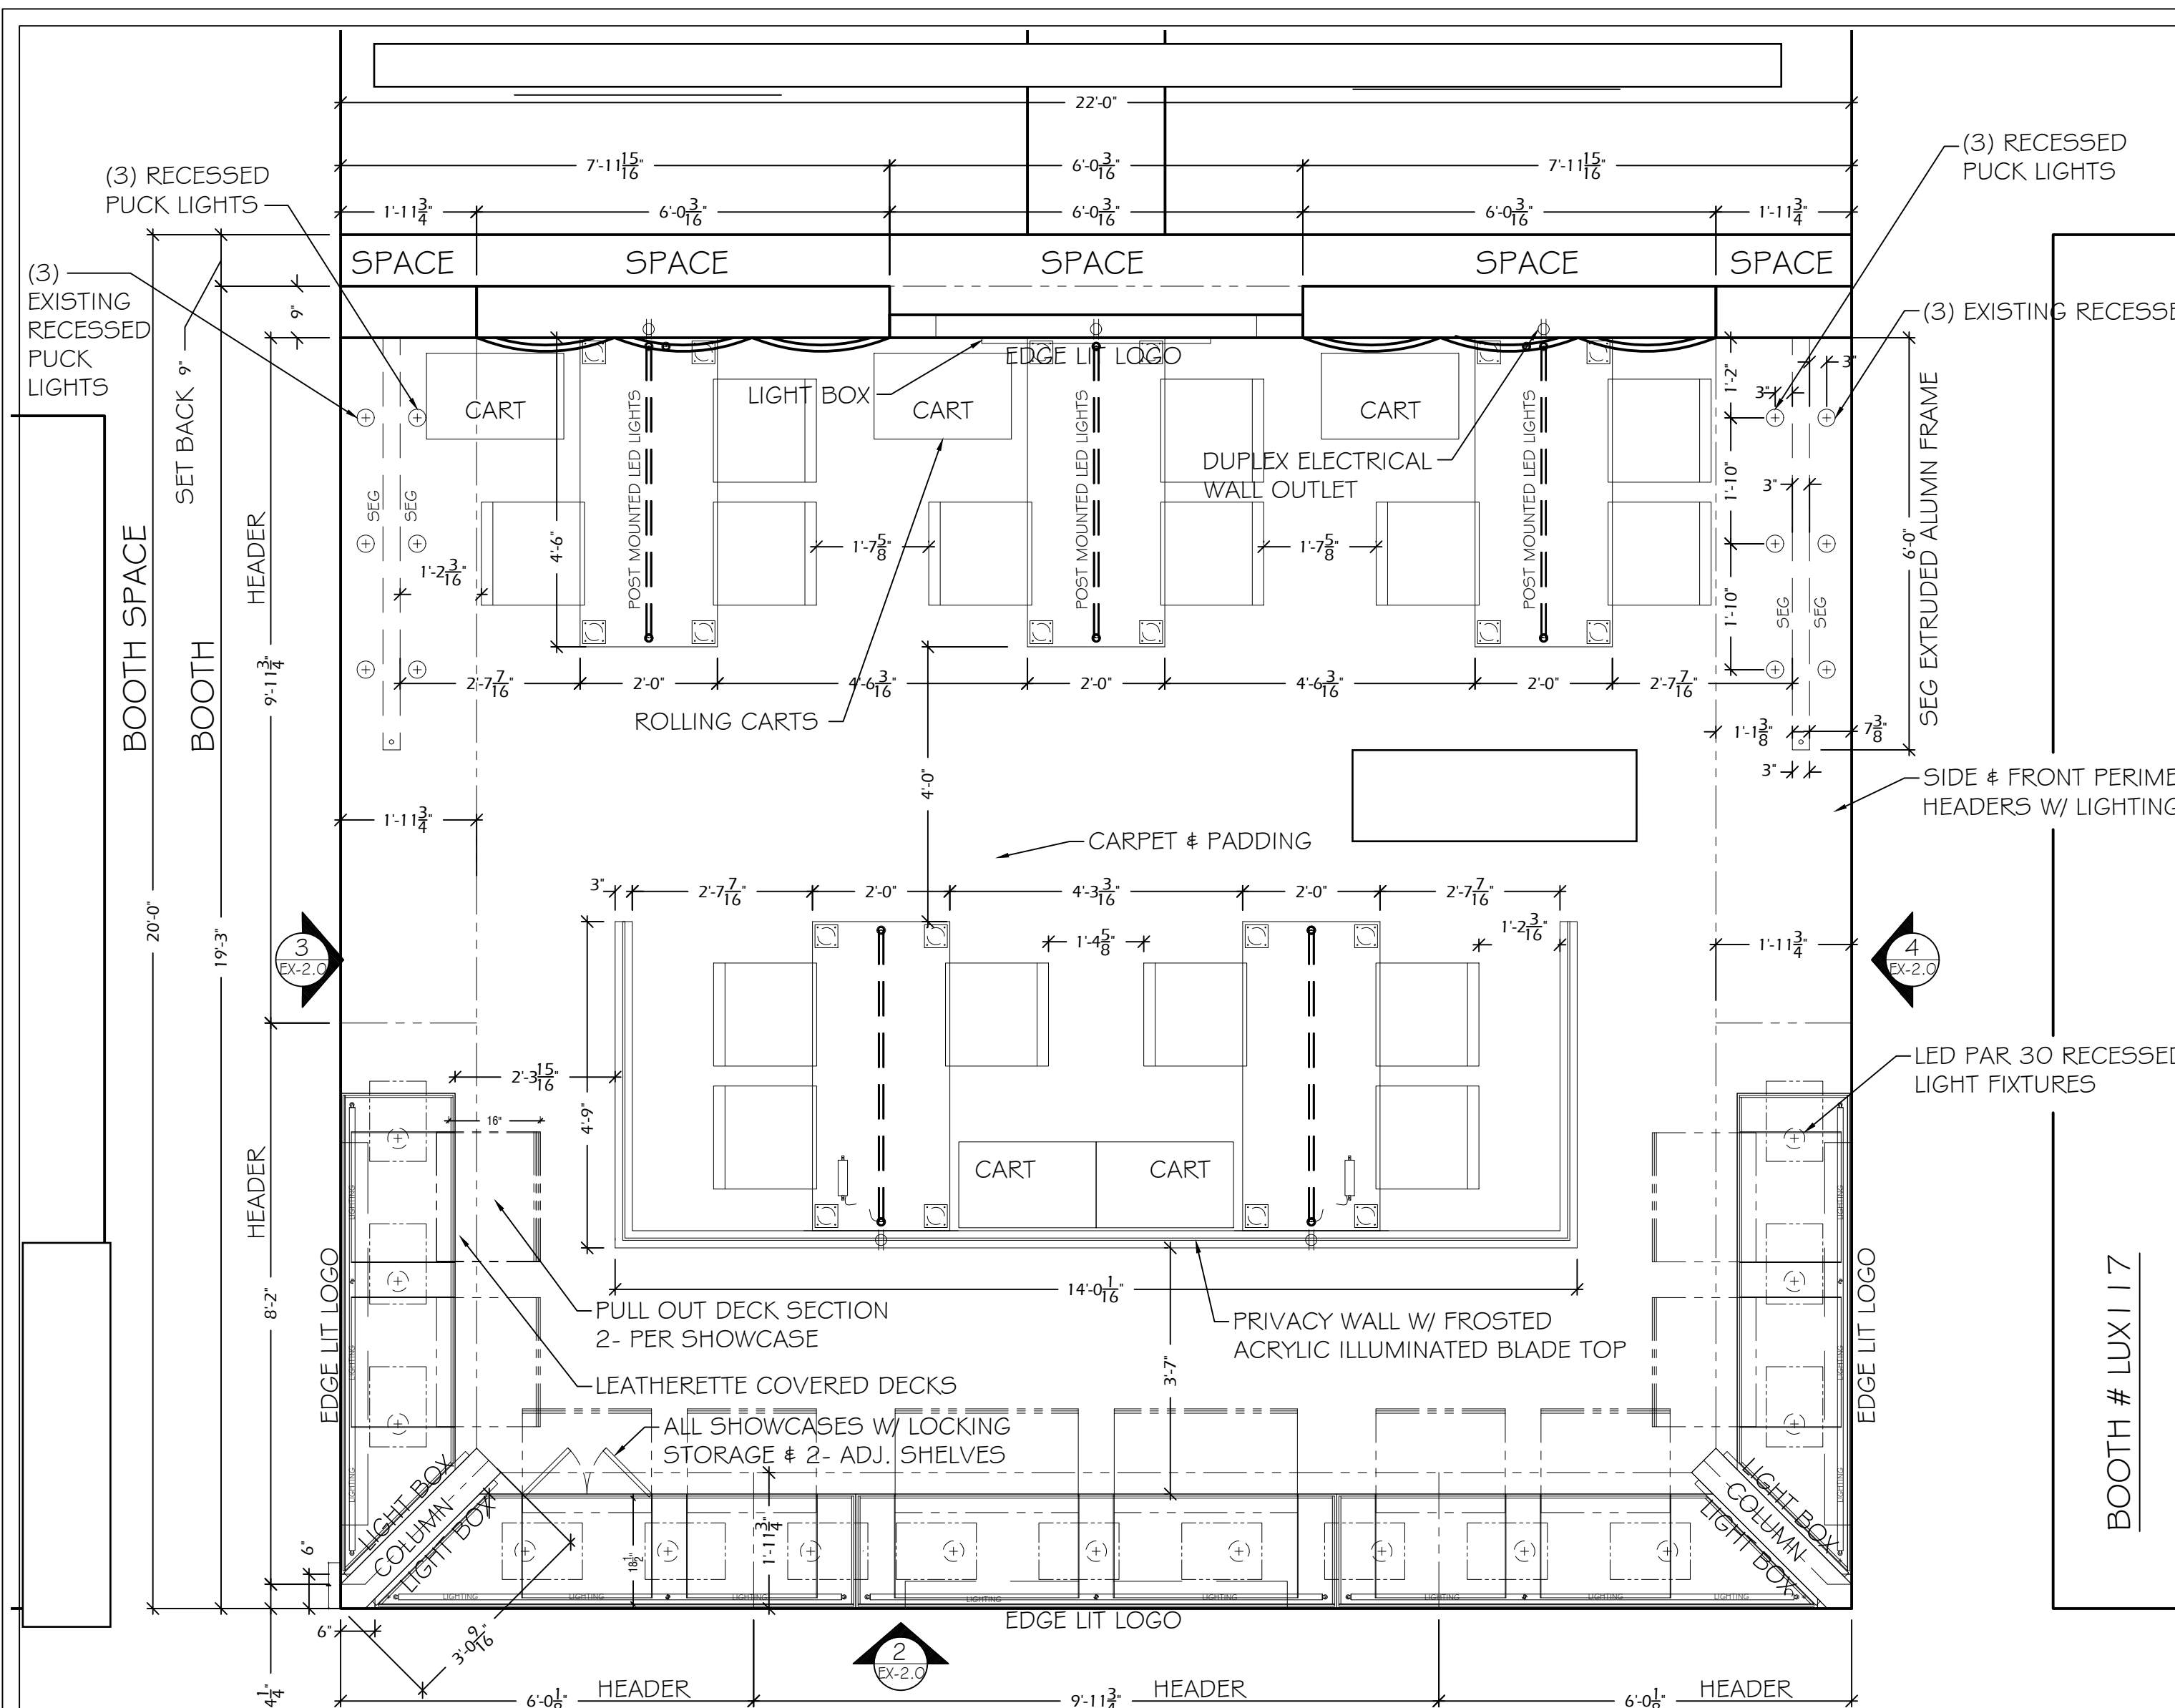


1 FLOOR PLAN
SCALE: 1/2"=1'-0"

FRONT OF BOOTH

BOOTH # LUX 117

FRONT OF BOOTH

4 ELEVATION
SCALE: 1/2"=1'-0"

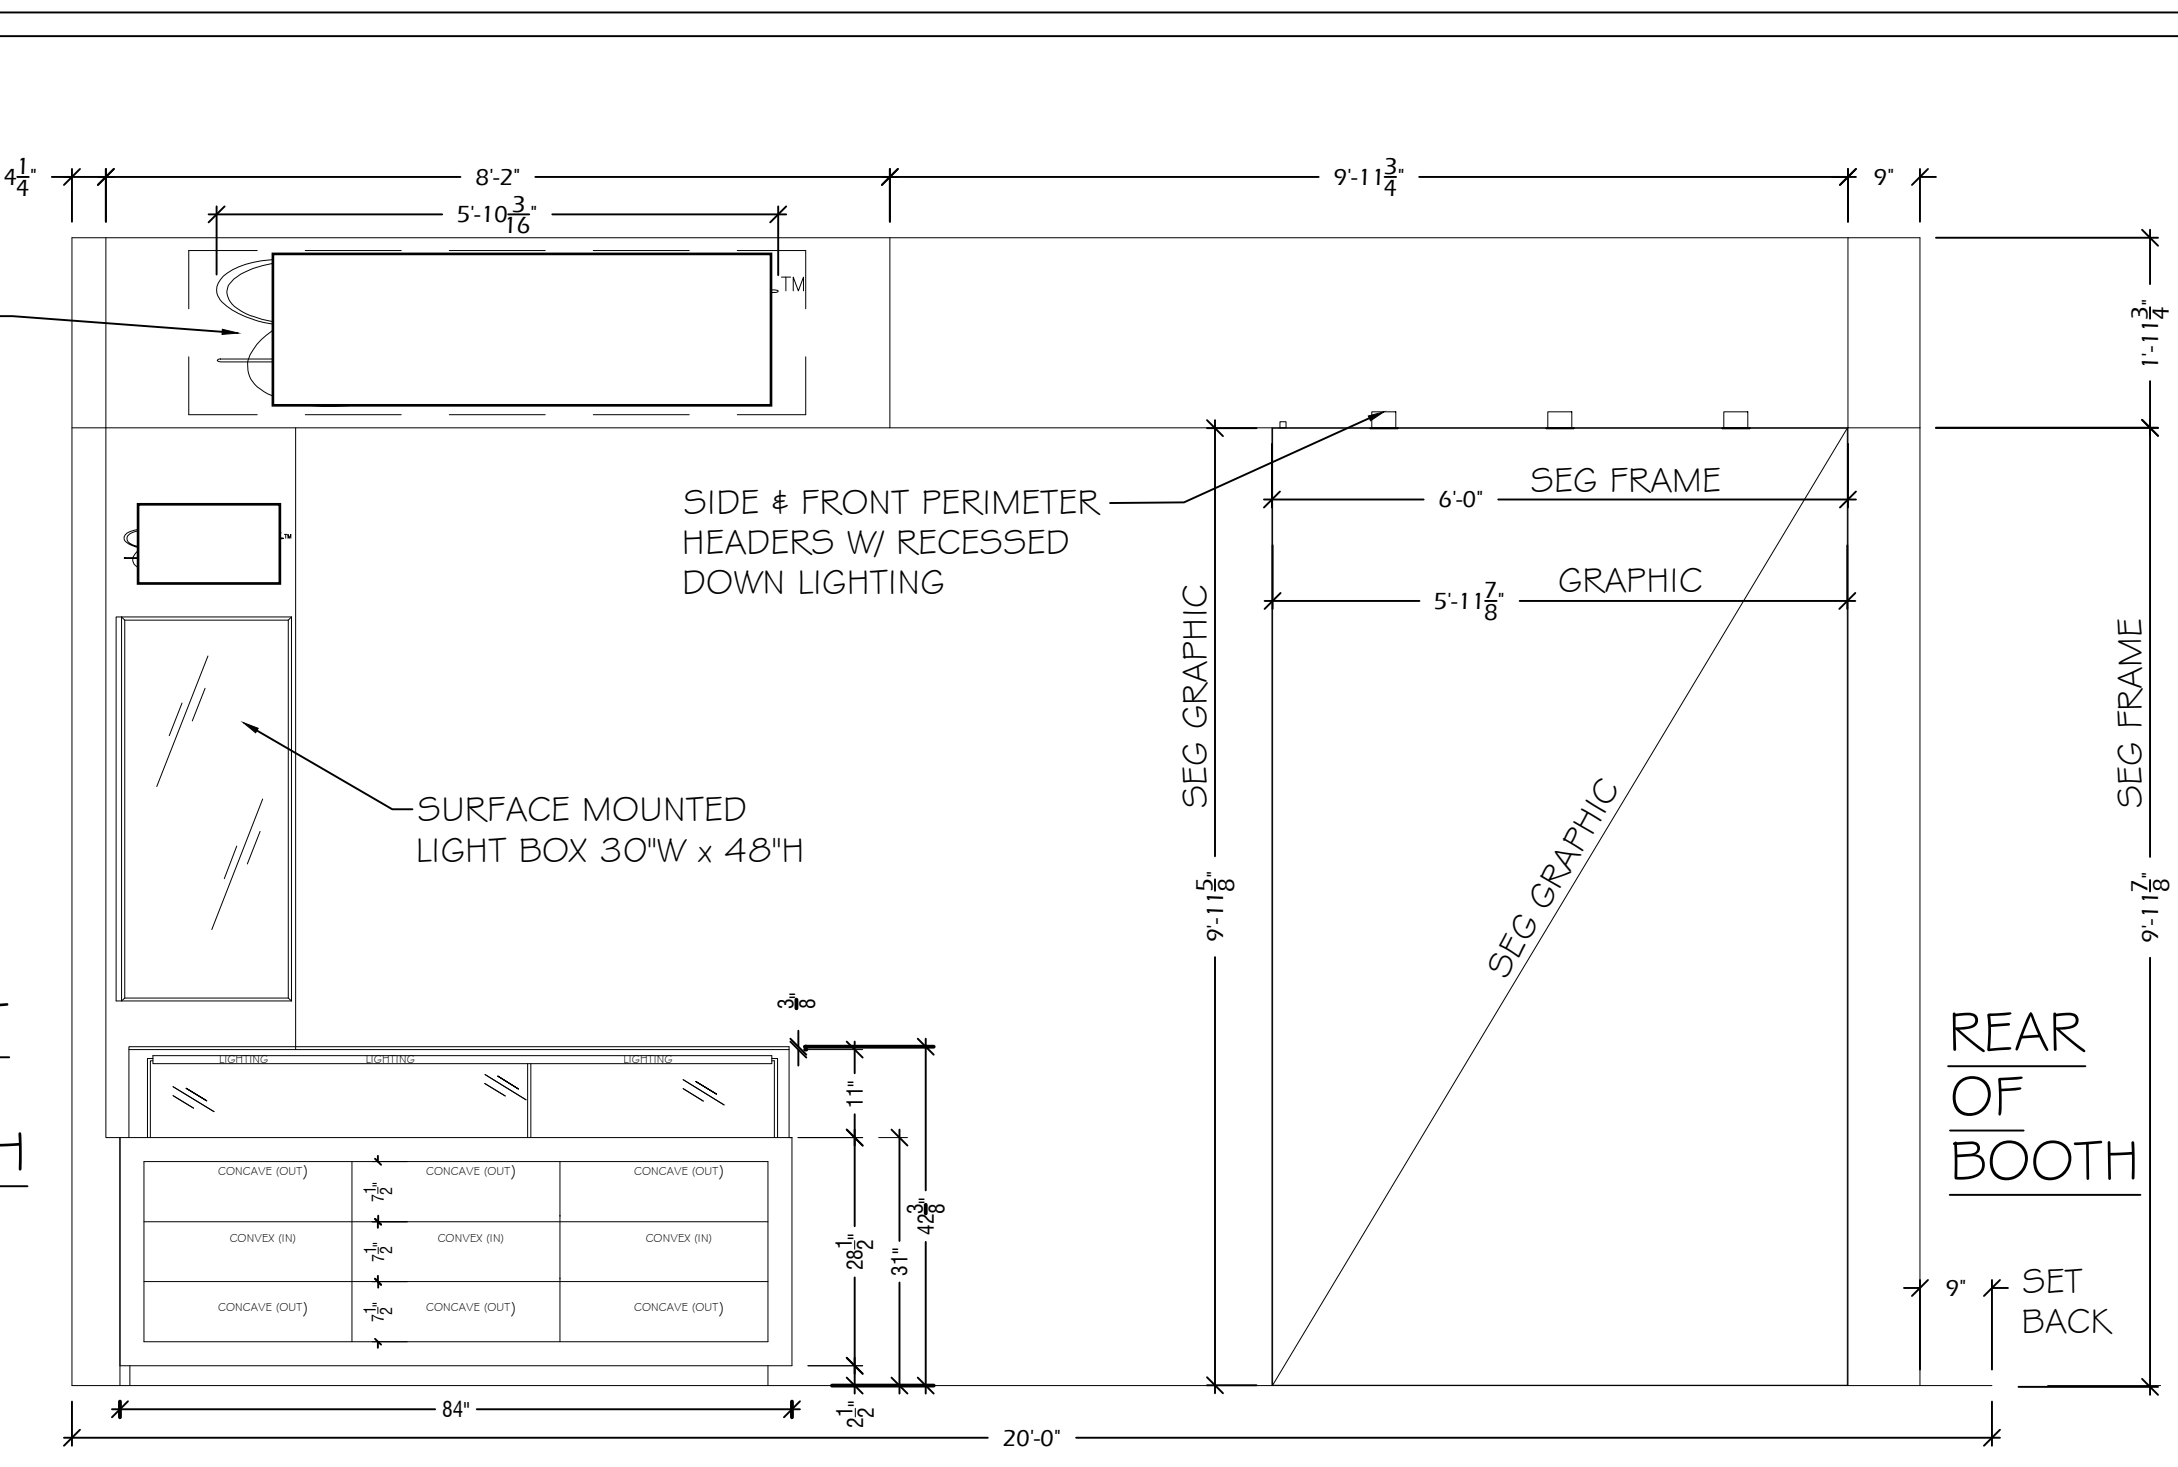


REAR OF BOOTH

LIGHT BOX BY DSA PHOTOTECH
30"W X 48"H GRAPHIC
VISIBLE OPENING
29 5/8"W X 47 5/8"H
ANODIZED SILVER FINISH

CORNER PANEL


ELEVATION:
LIGHTBOX COLUMNS
(TYP)

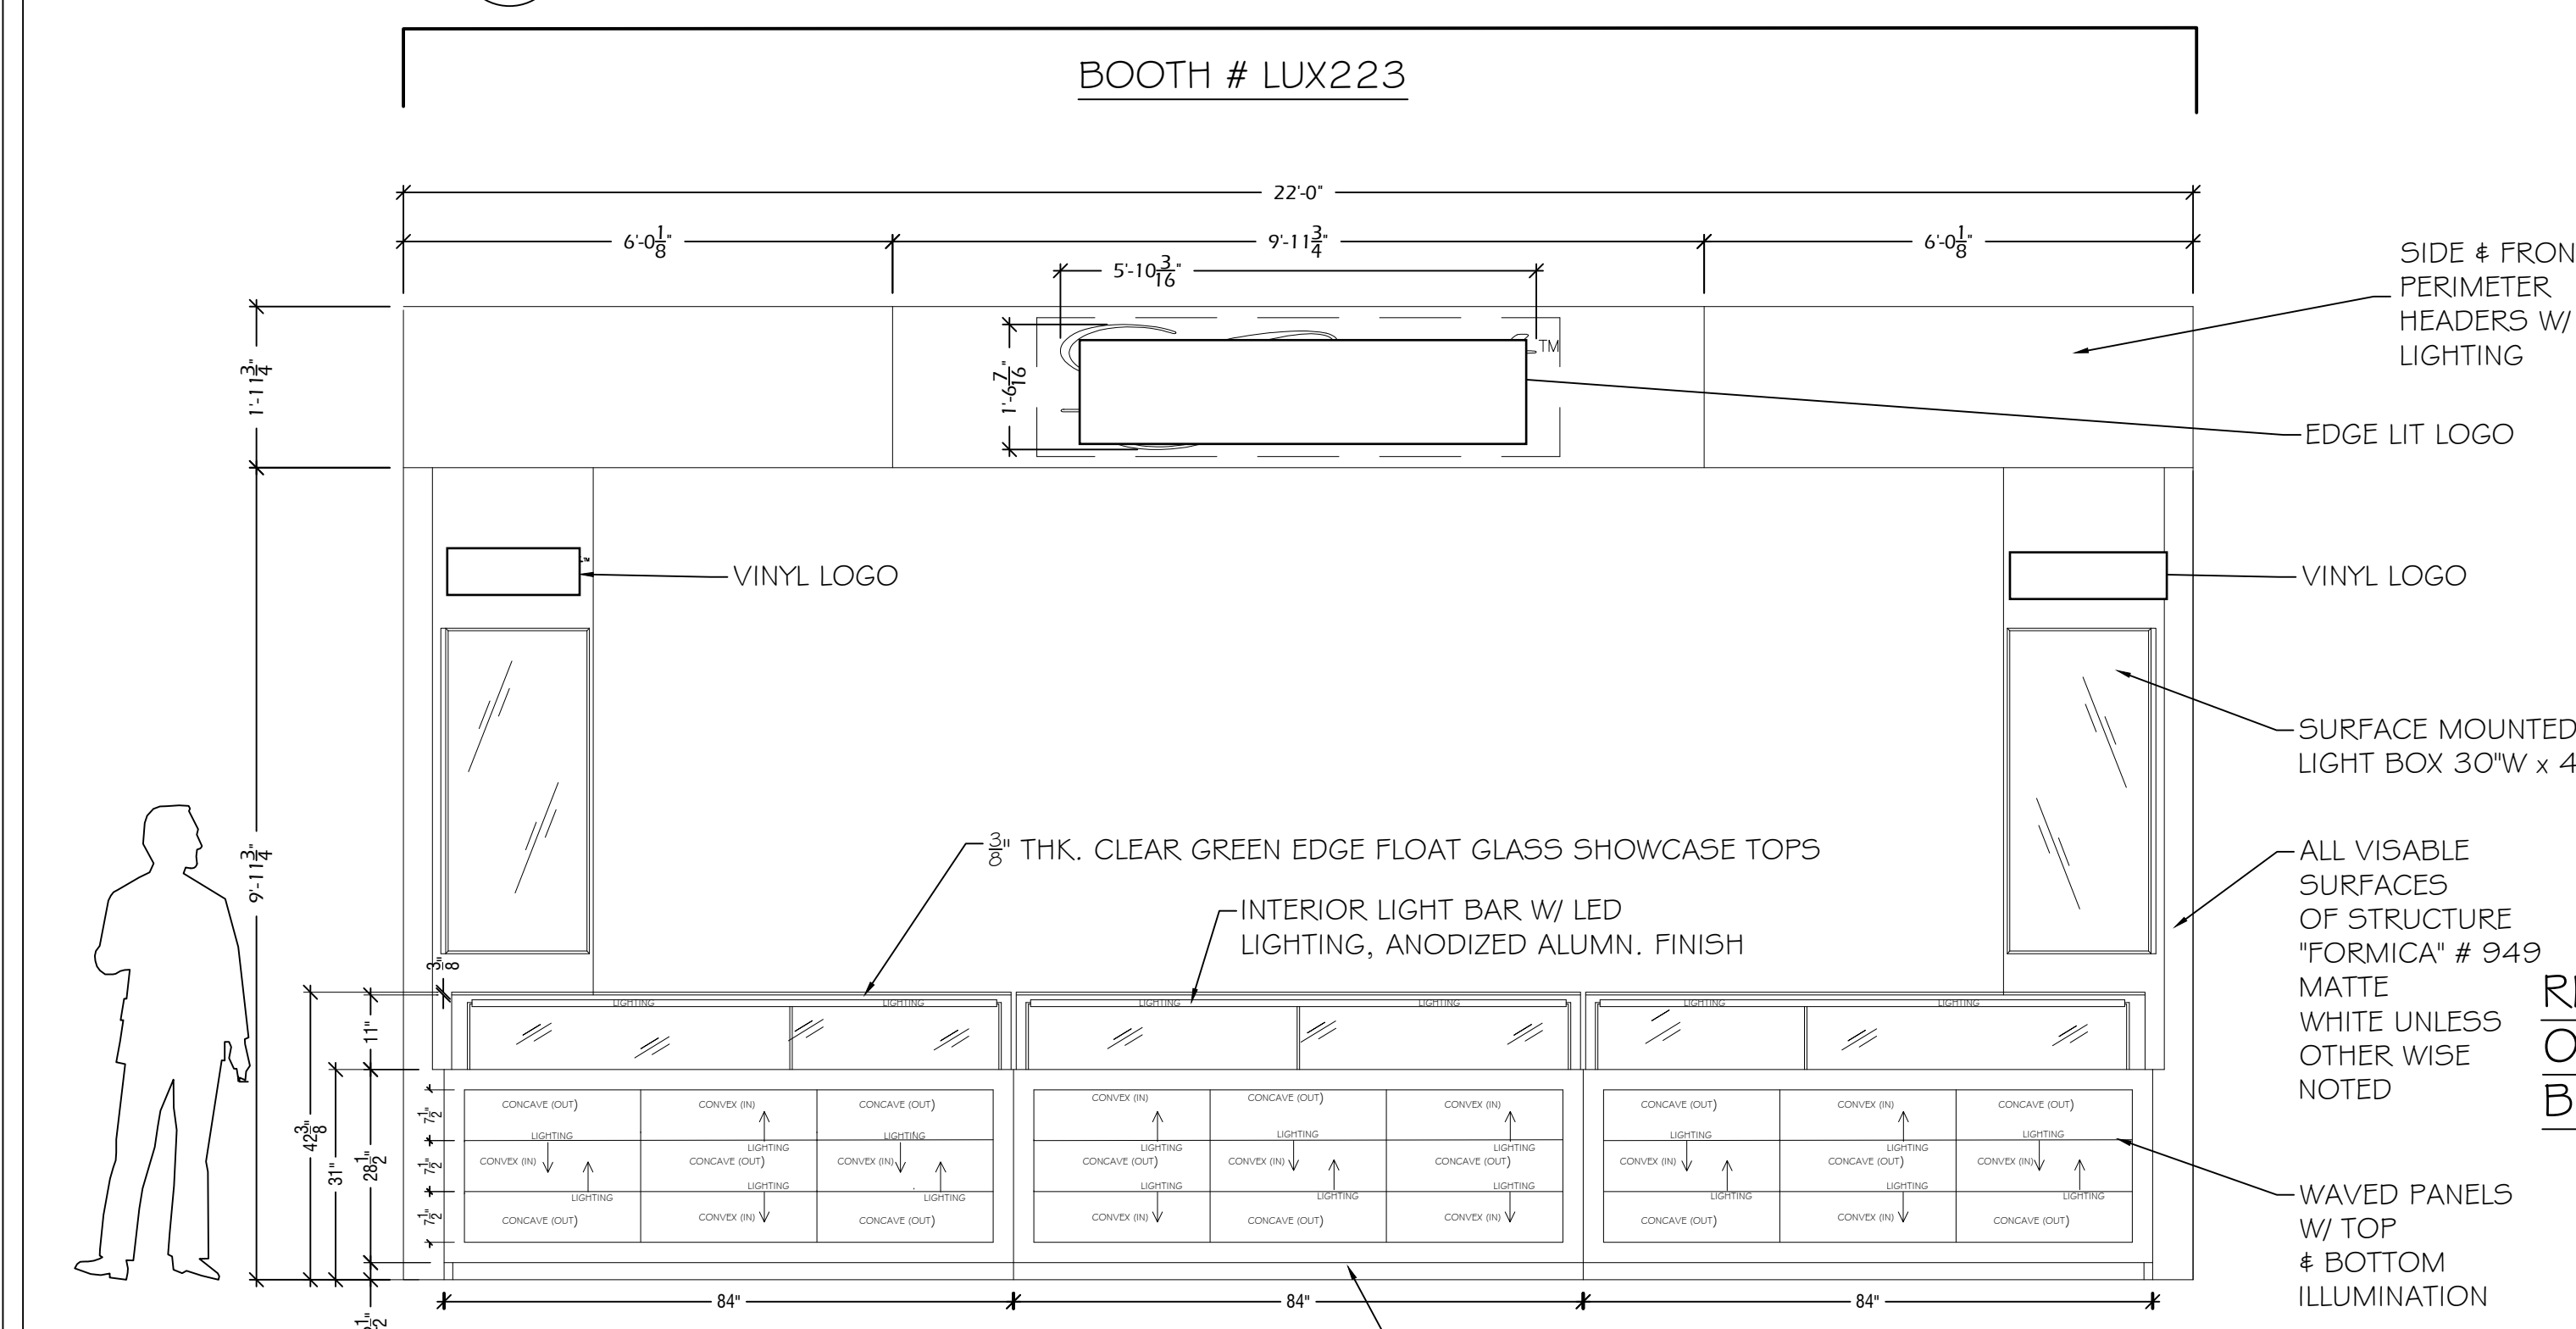


2 FRONT ELEVATION
SCALE: 1/2"=1'-0"

REAR OF BOOTH


SHOW FLOOR PLAN

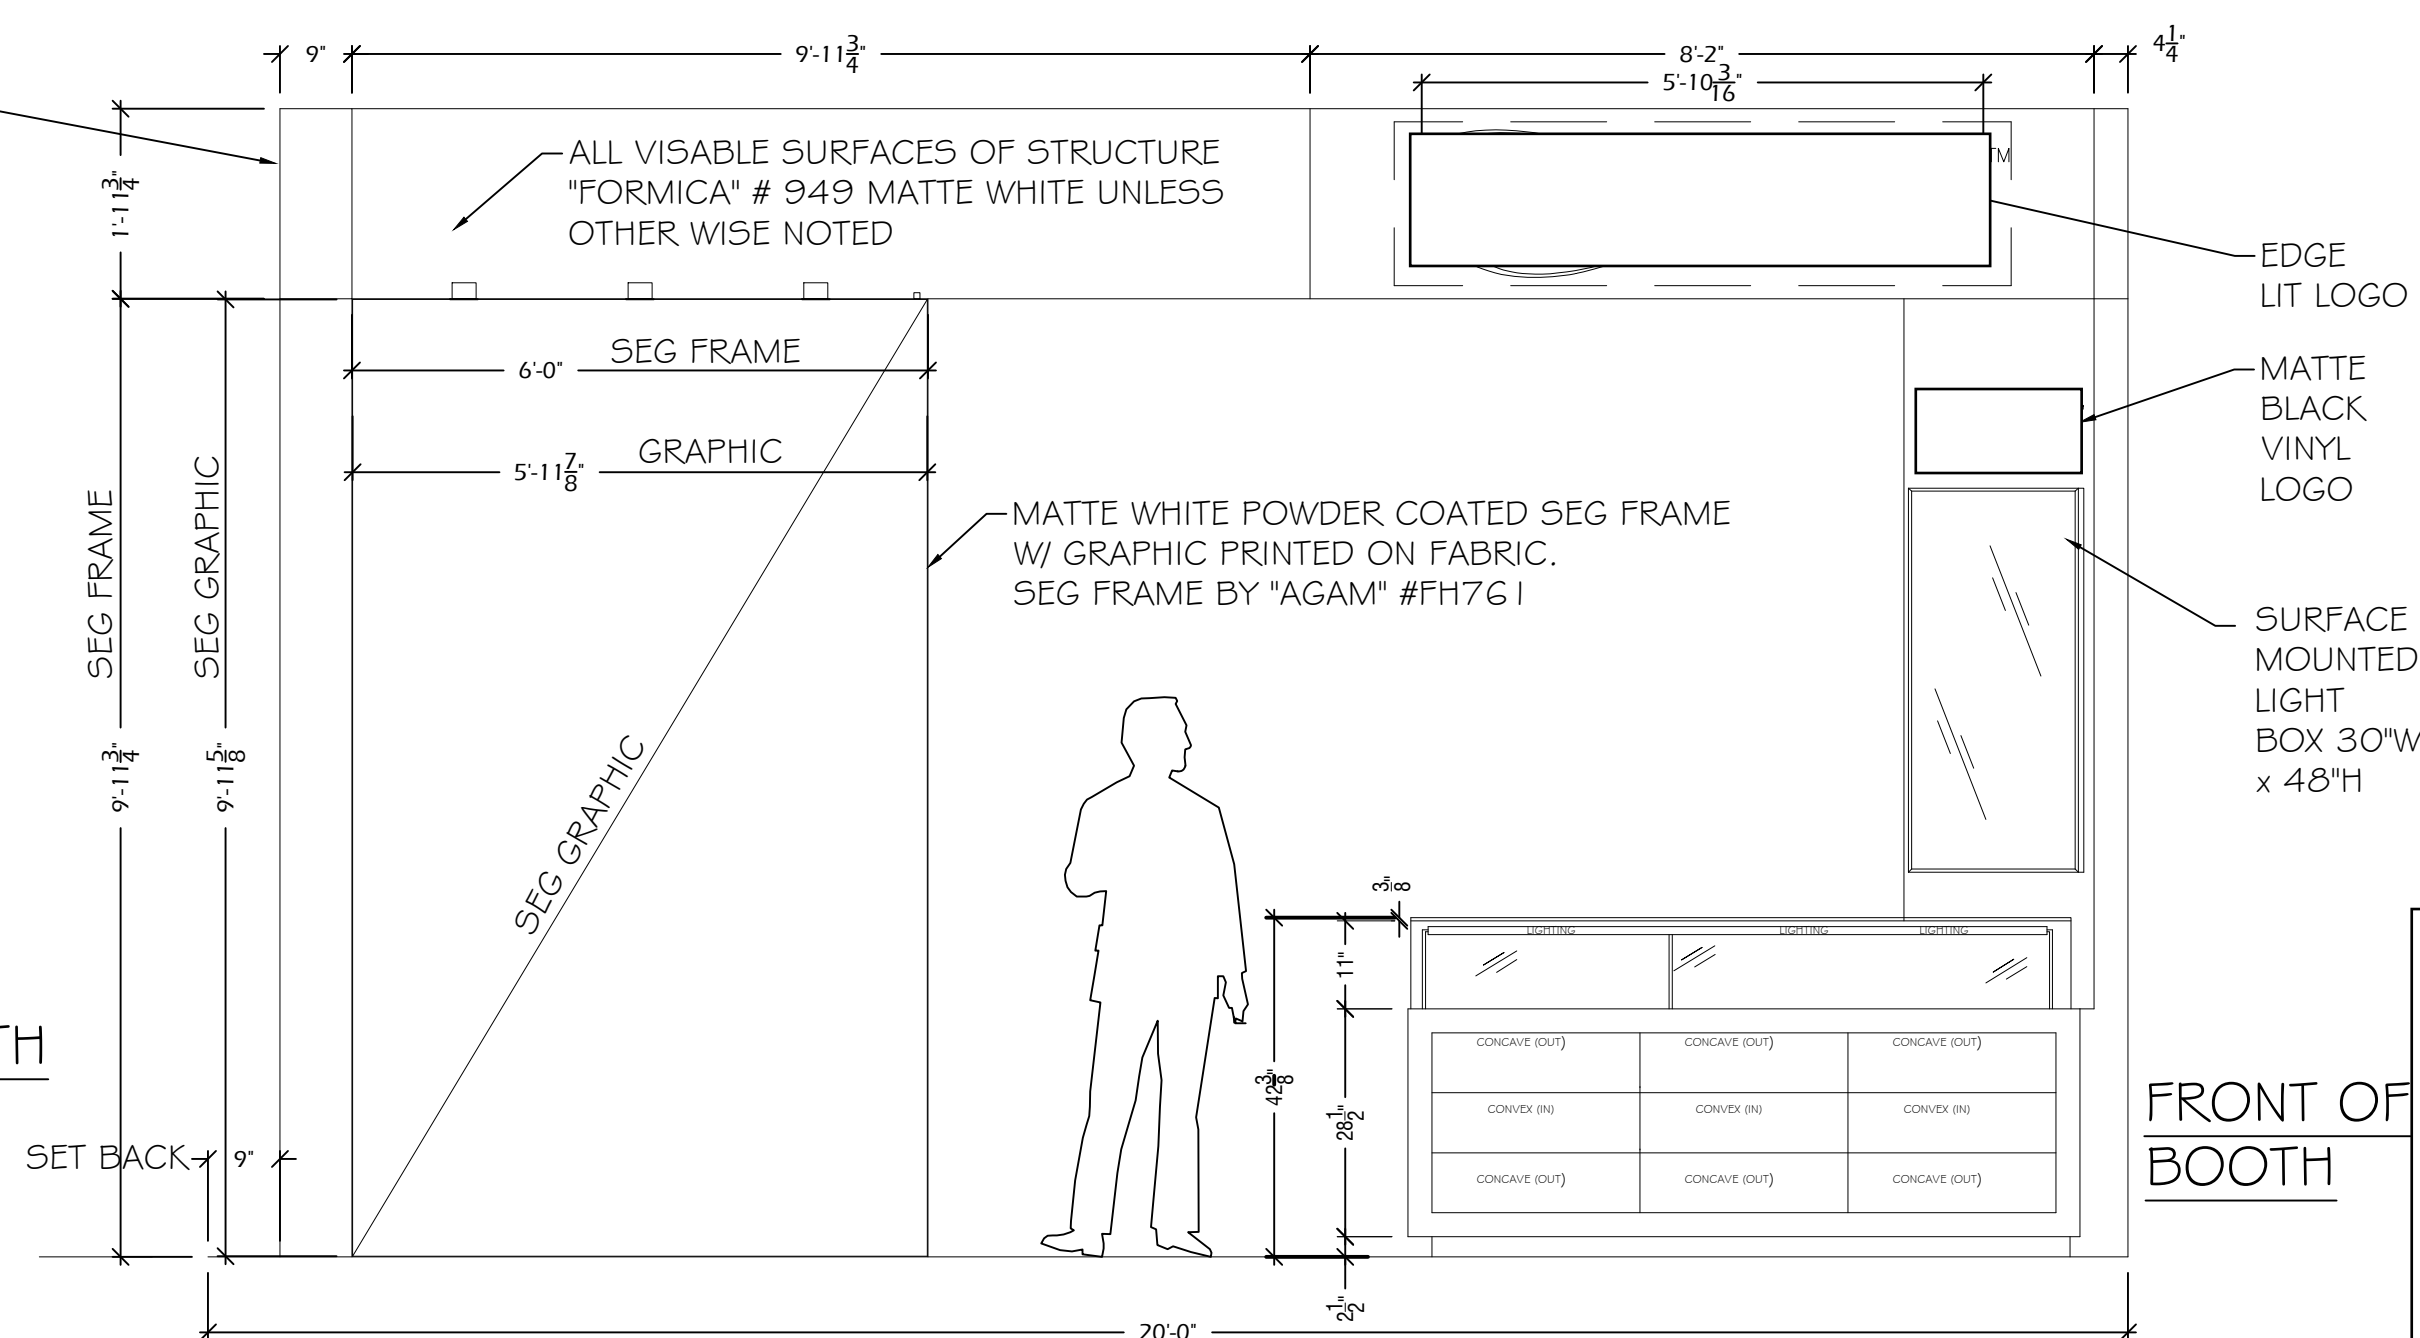


FRONT OF BOOTH

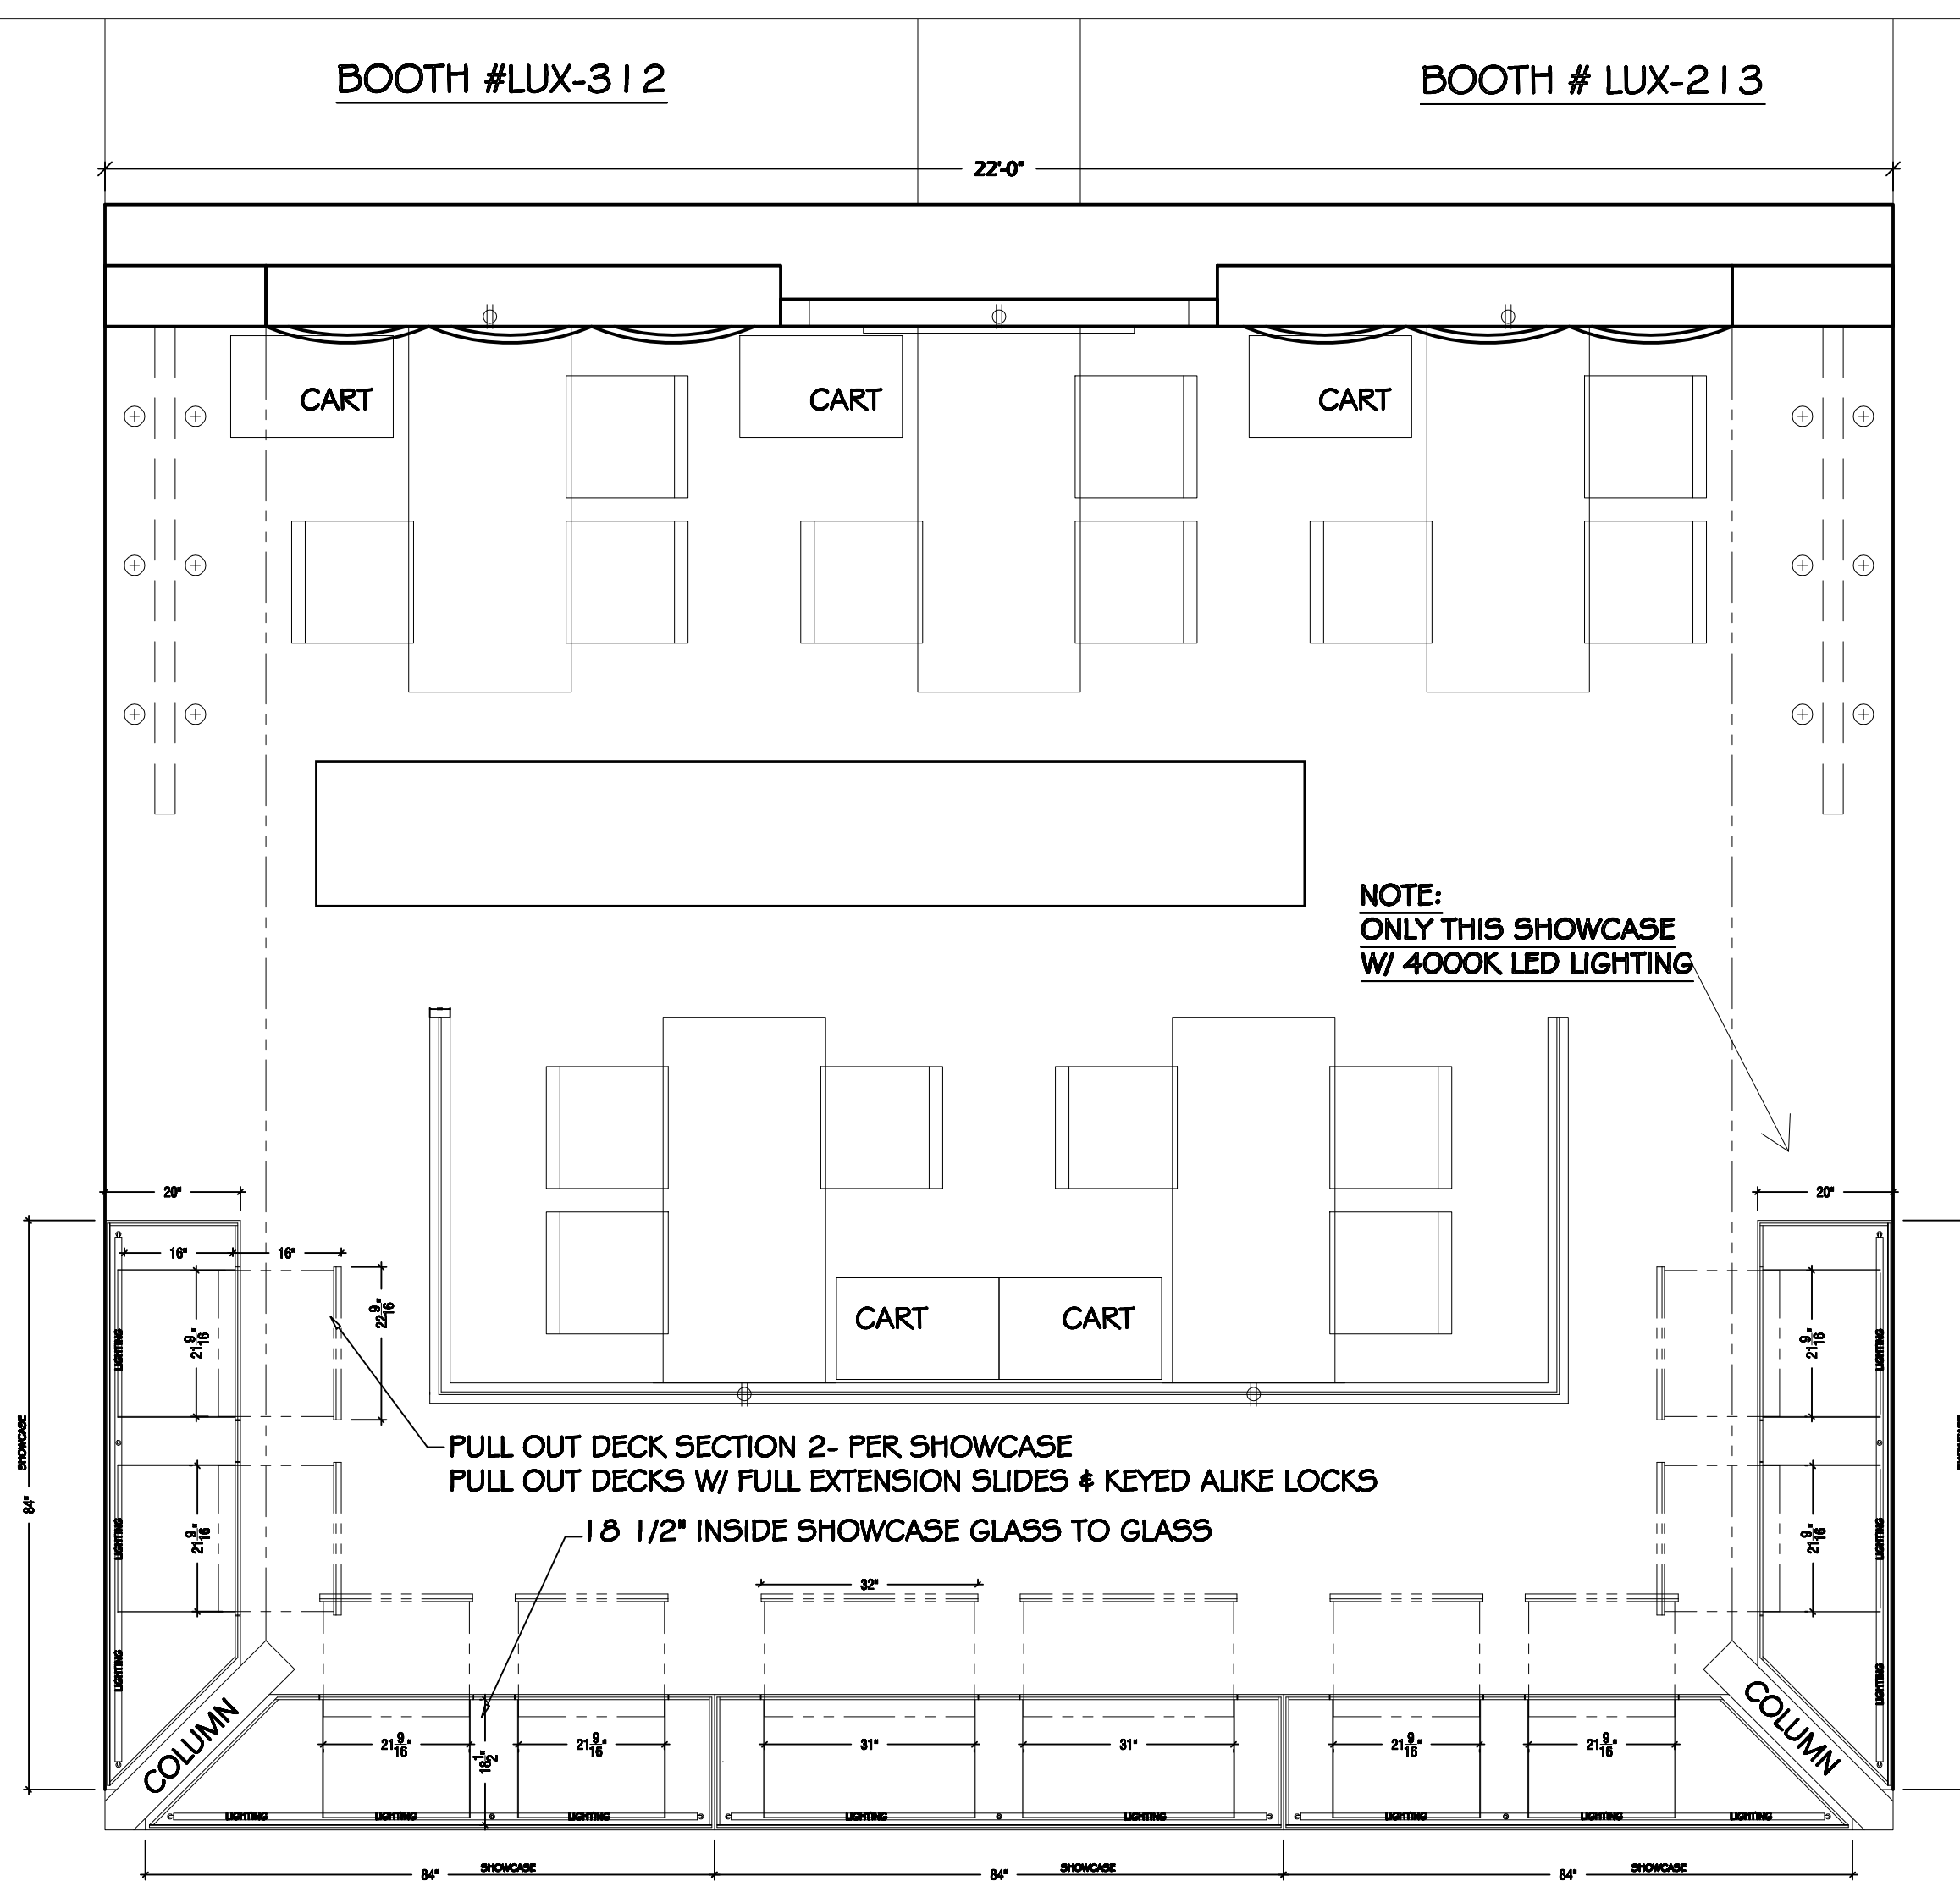


FLOOR PLAN: 22' X 20' PENINSULA BOOTH SPACE
FRONT OF BOOTH

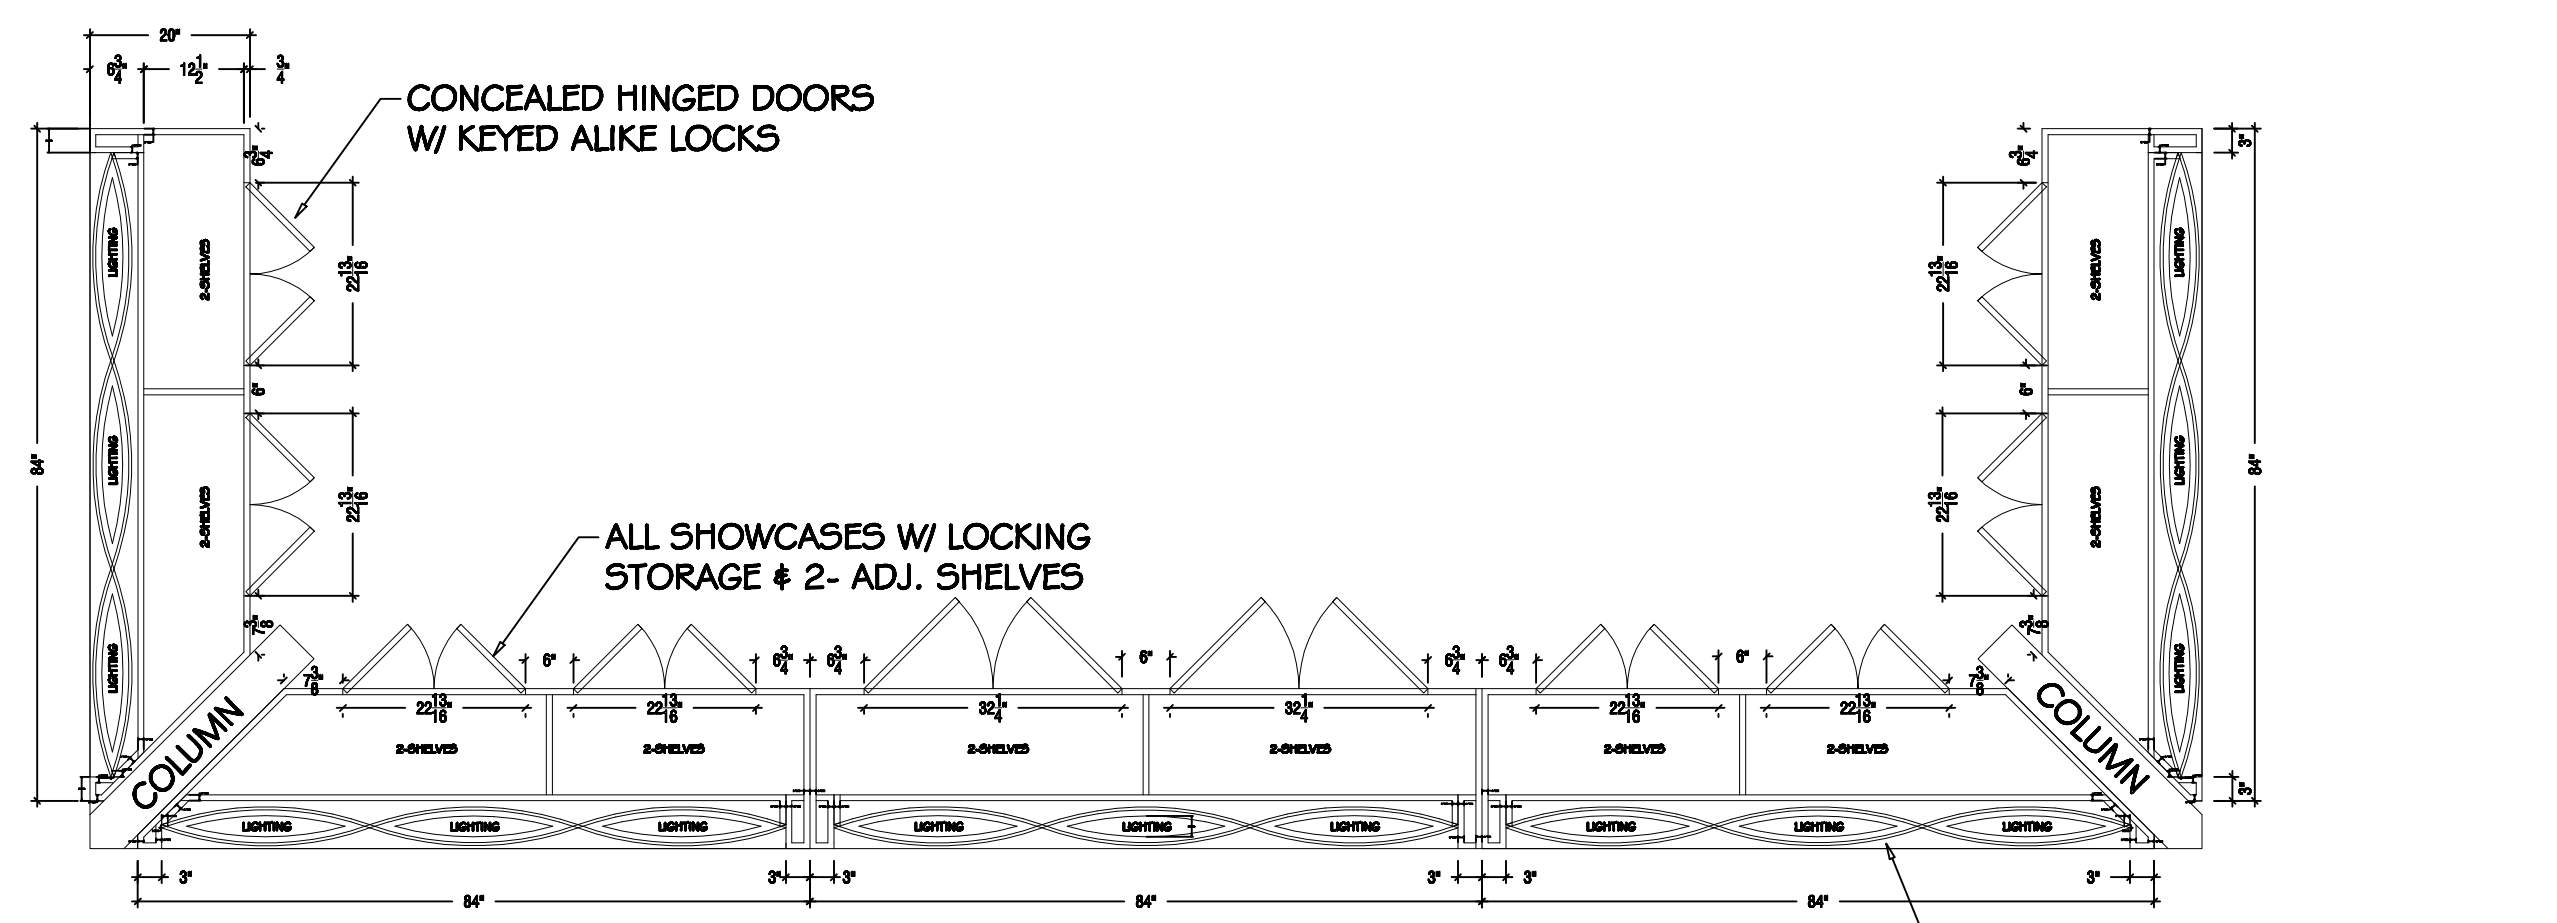


PLAN SECTION: SHOWCASES
FRONT OF BOOTH

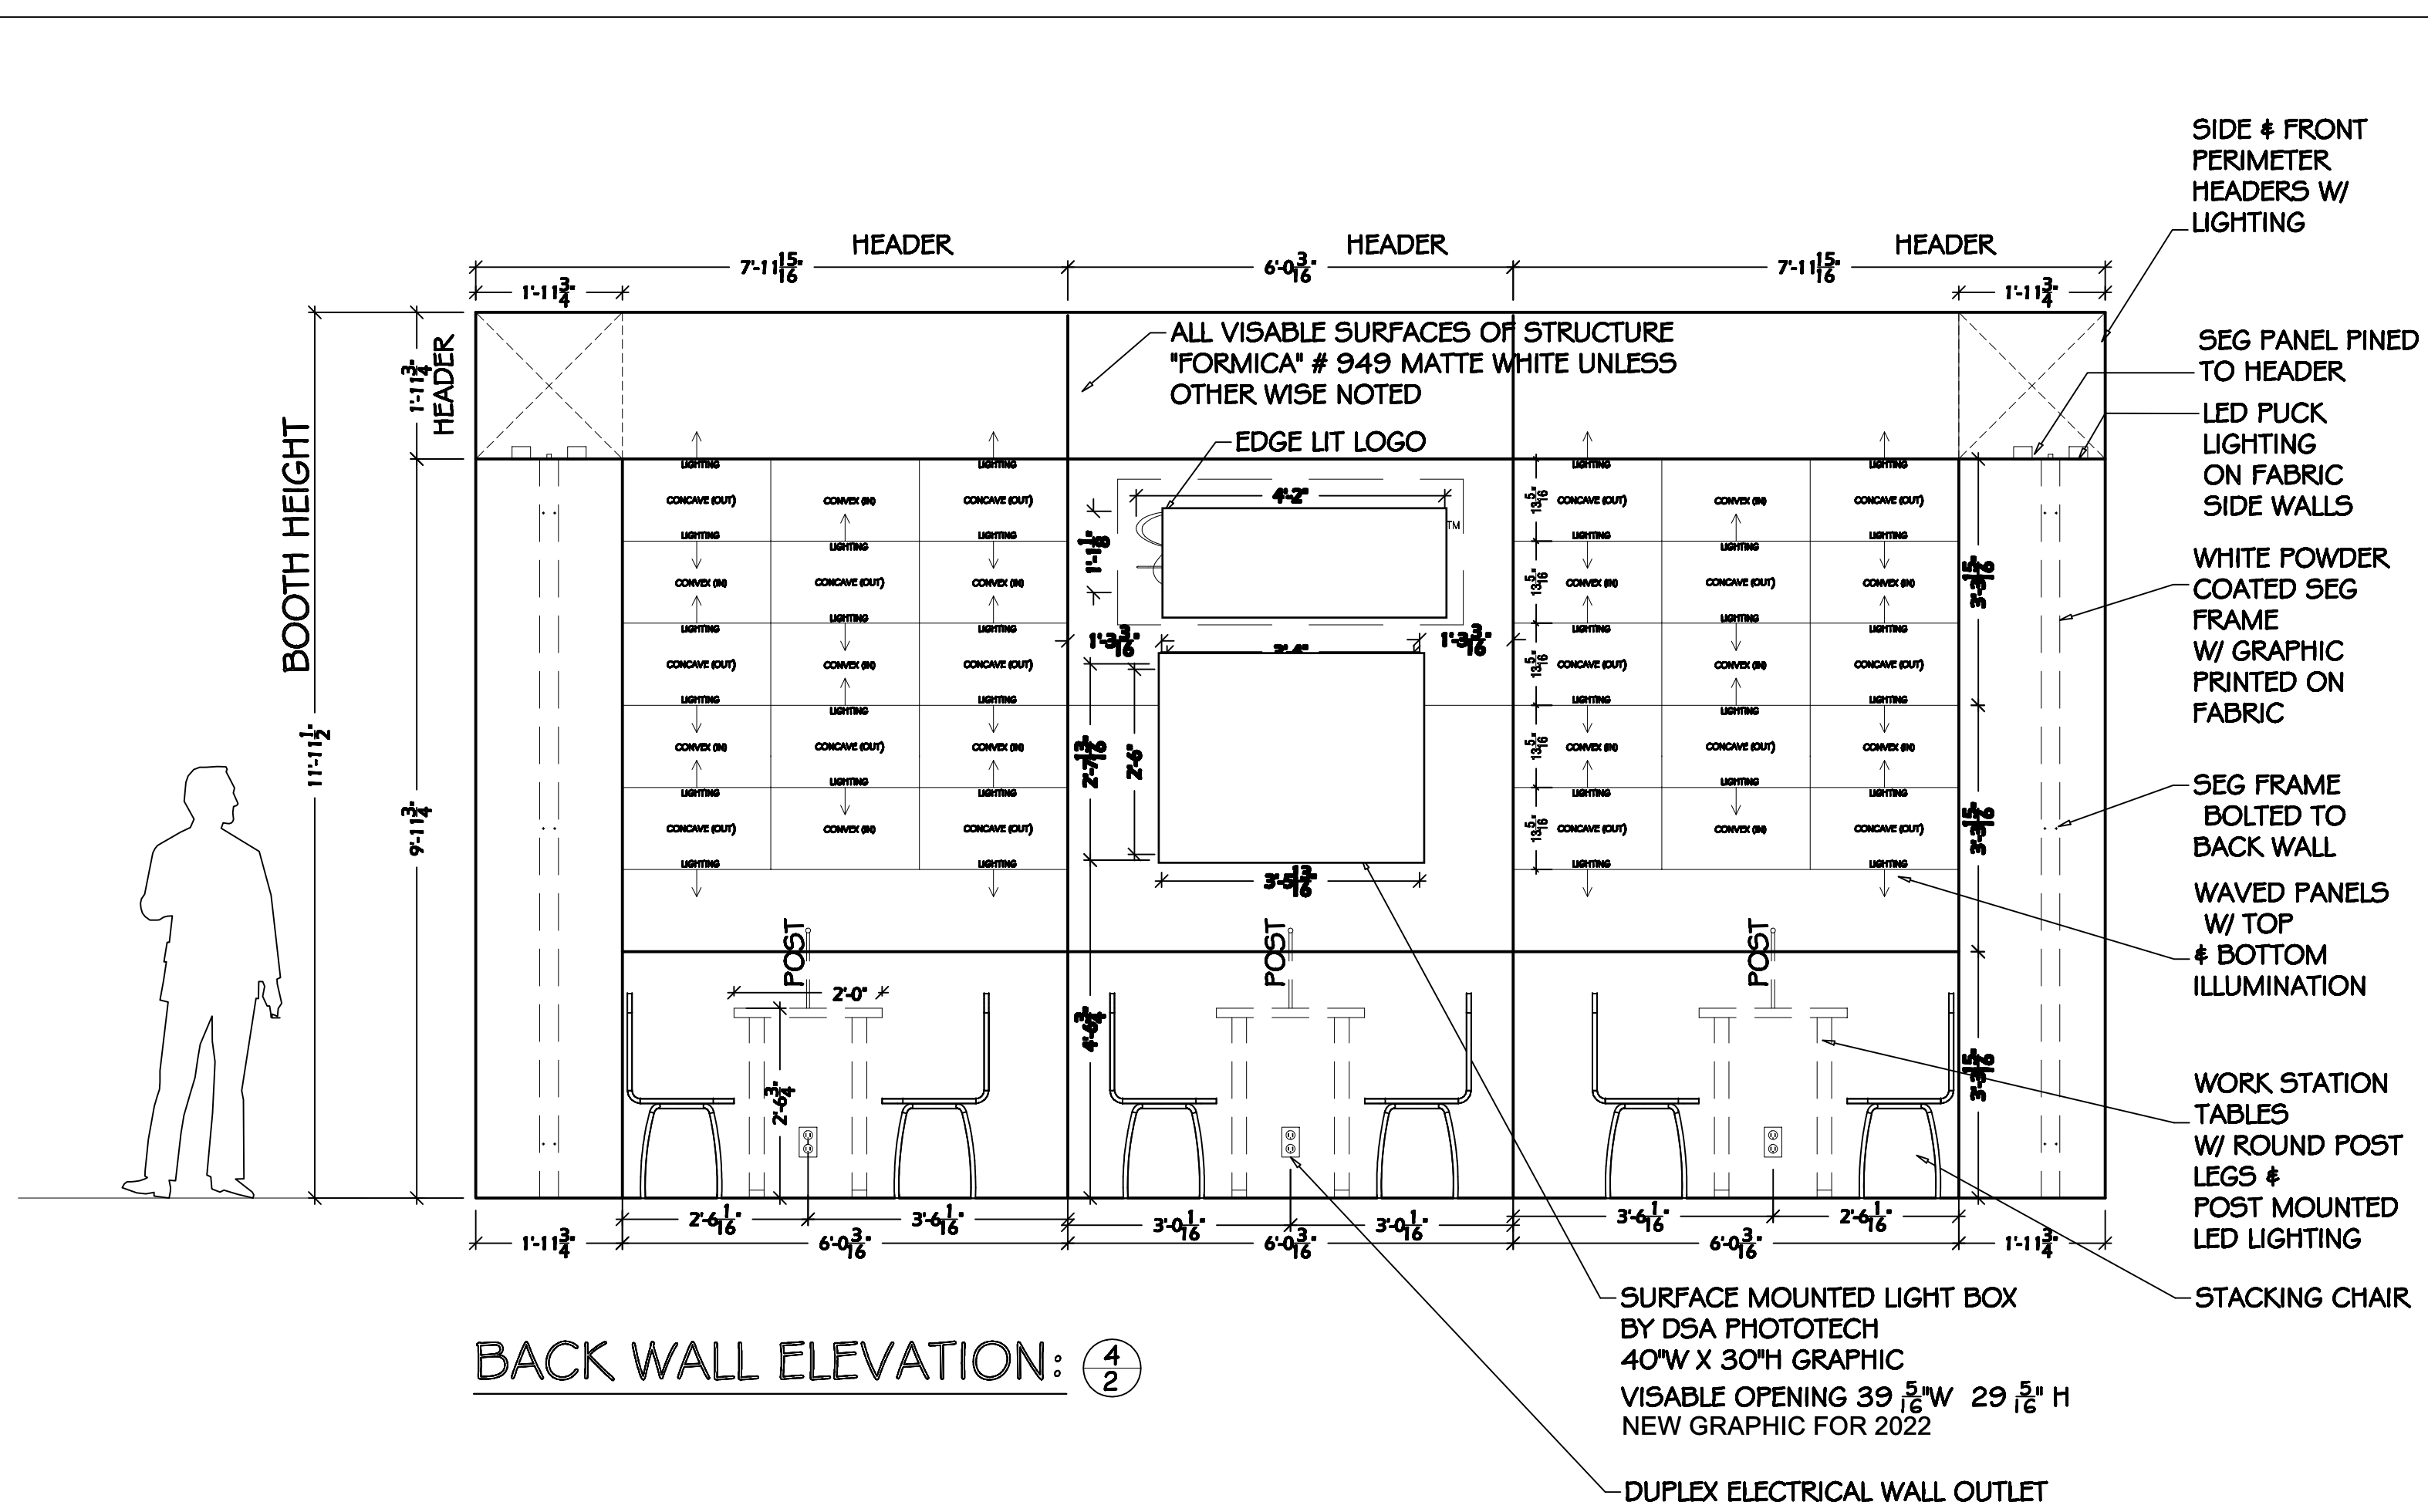


BACK WALL ELEVATION: ④

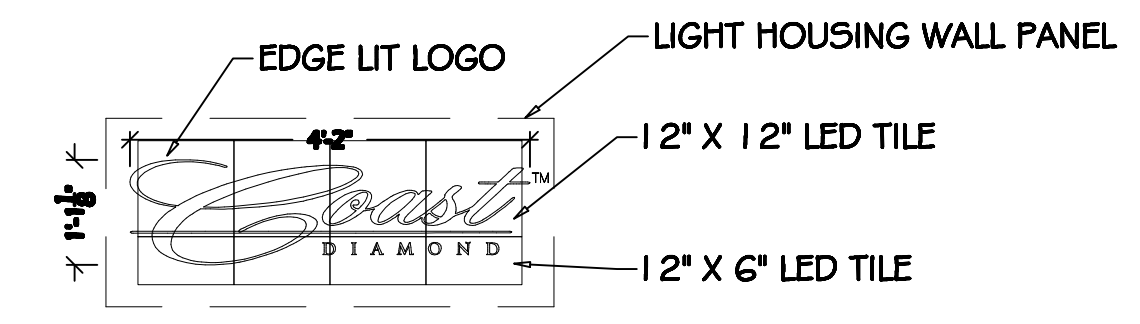

BACK WALL LOGO

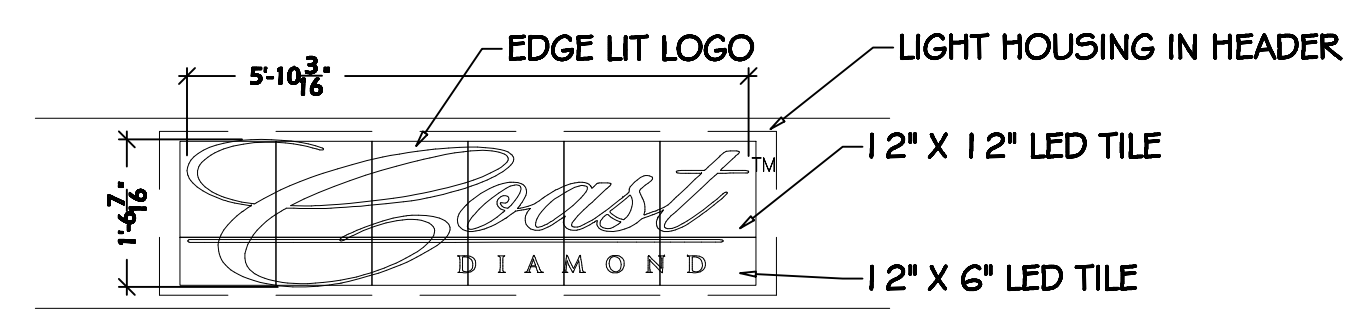


HEADER LOGO

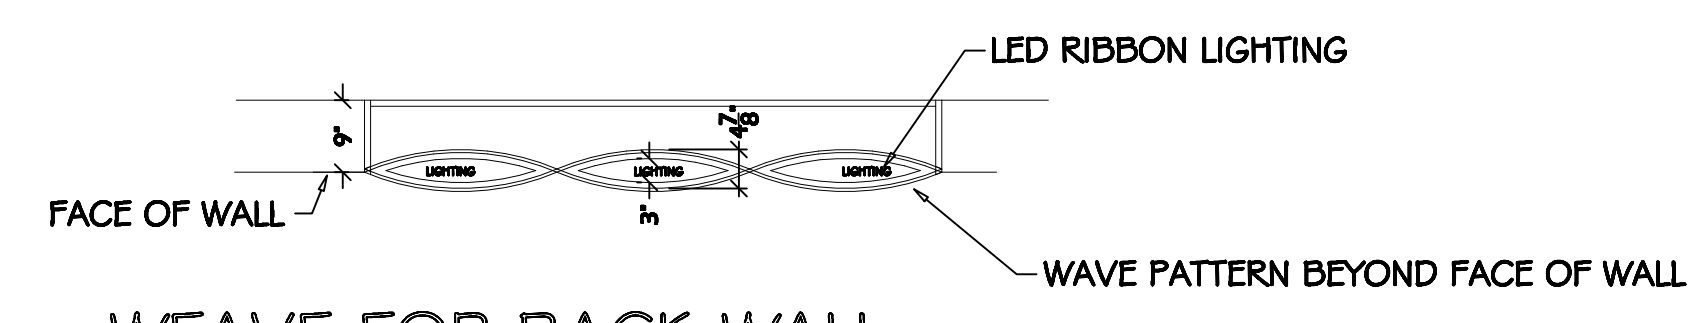


WEAVE FOR BACK WALL


1 SHOWCASE - BACKWALL ELEVATION
SCALE: 1/2" = 1'-0"

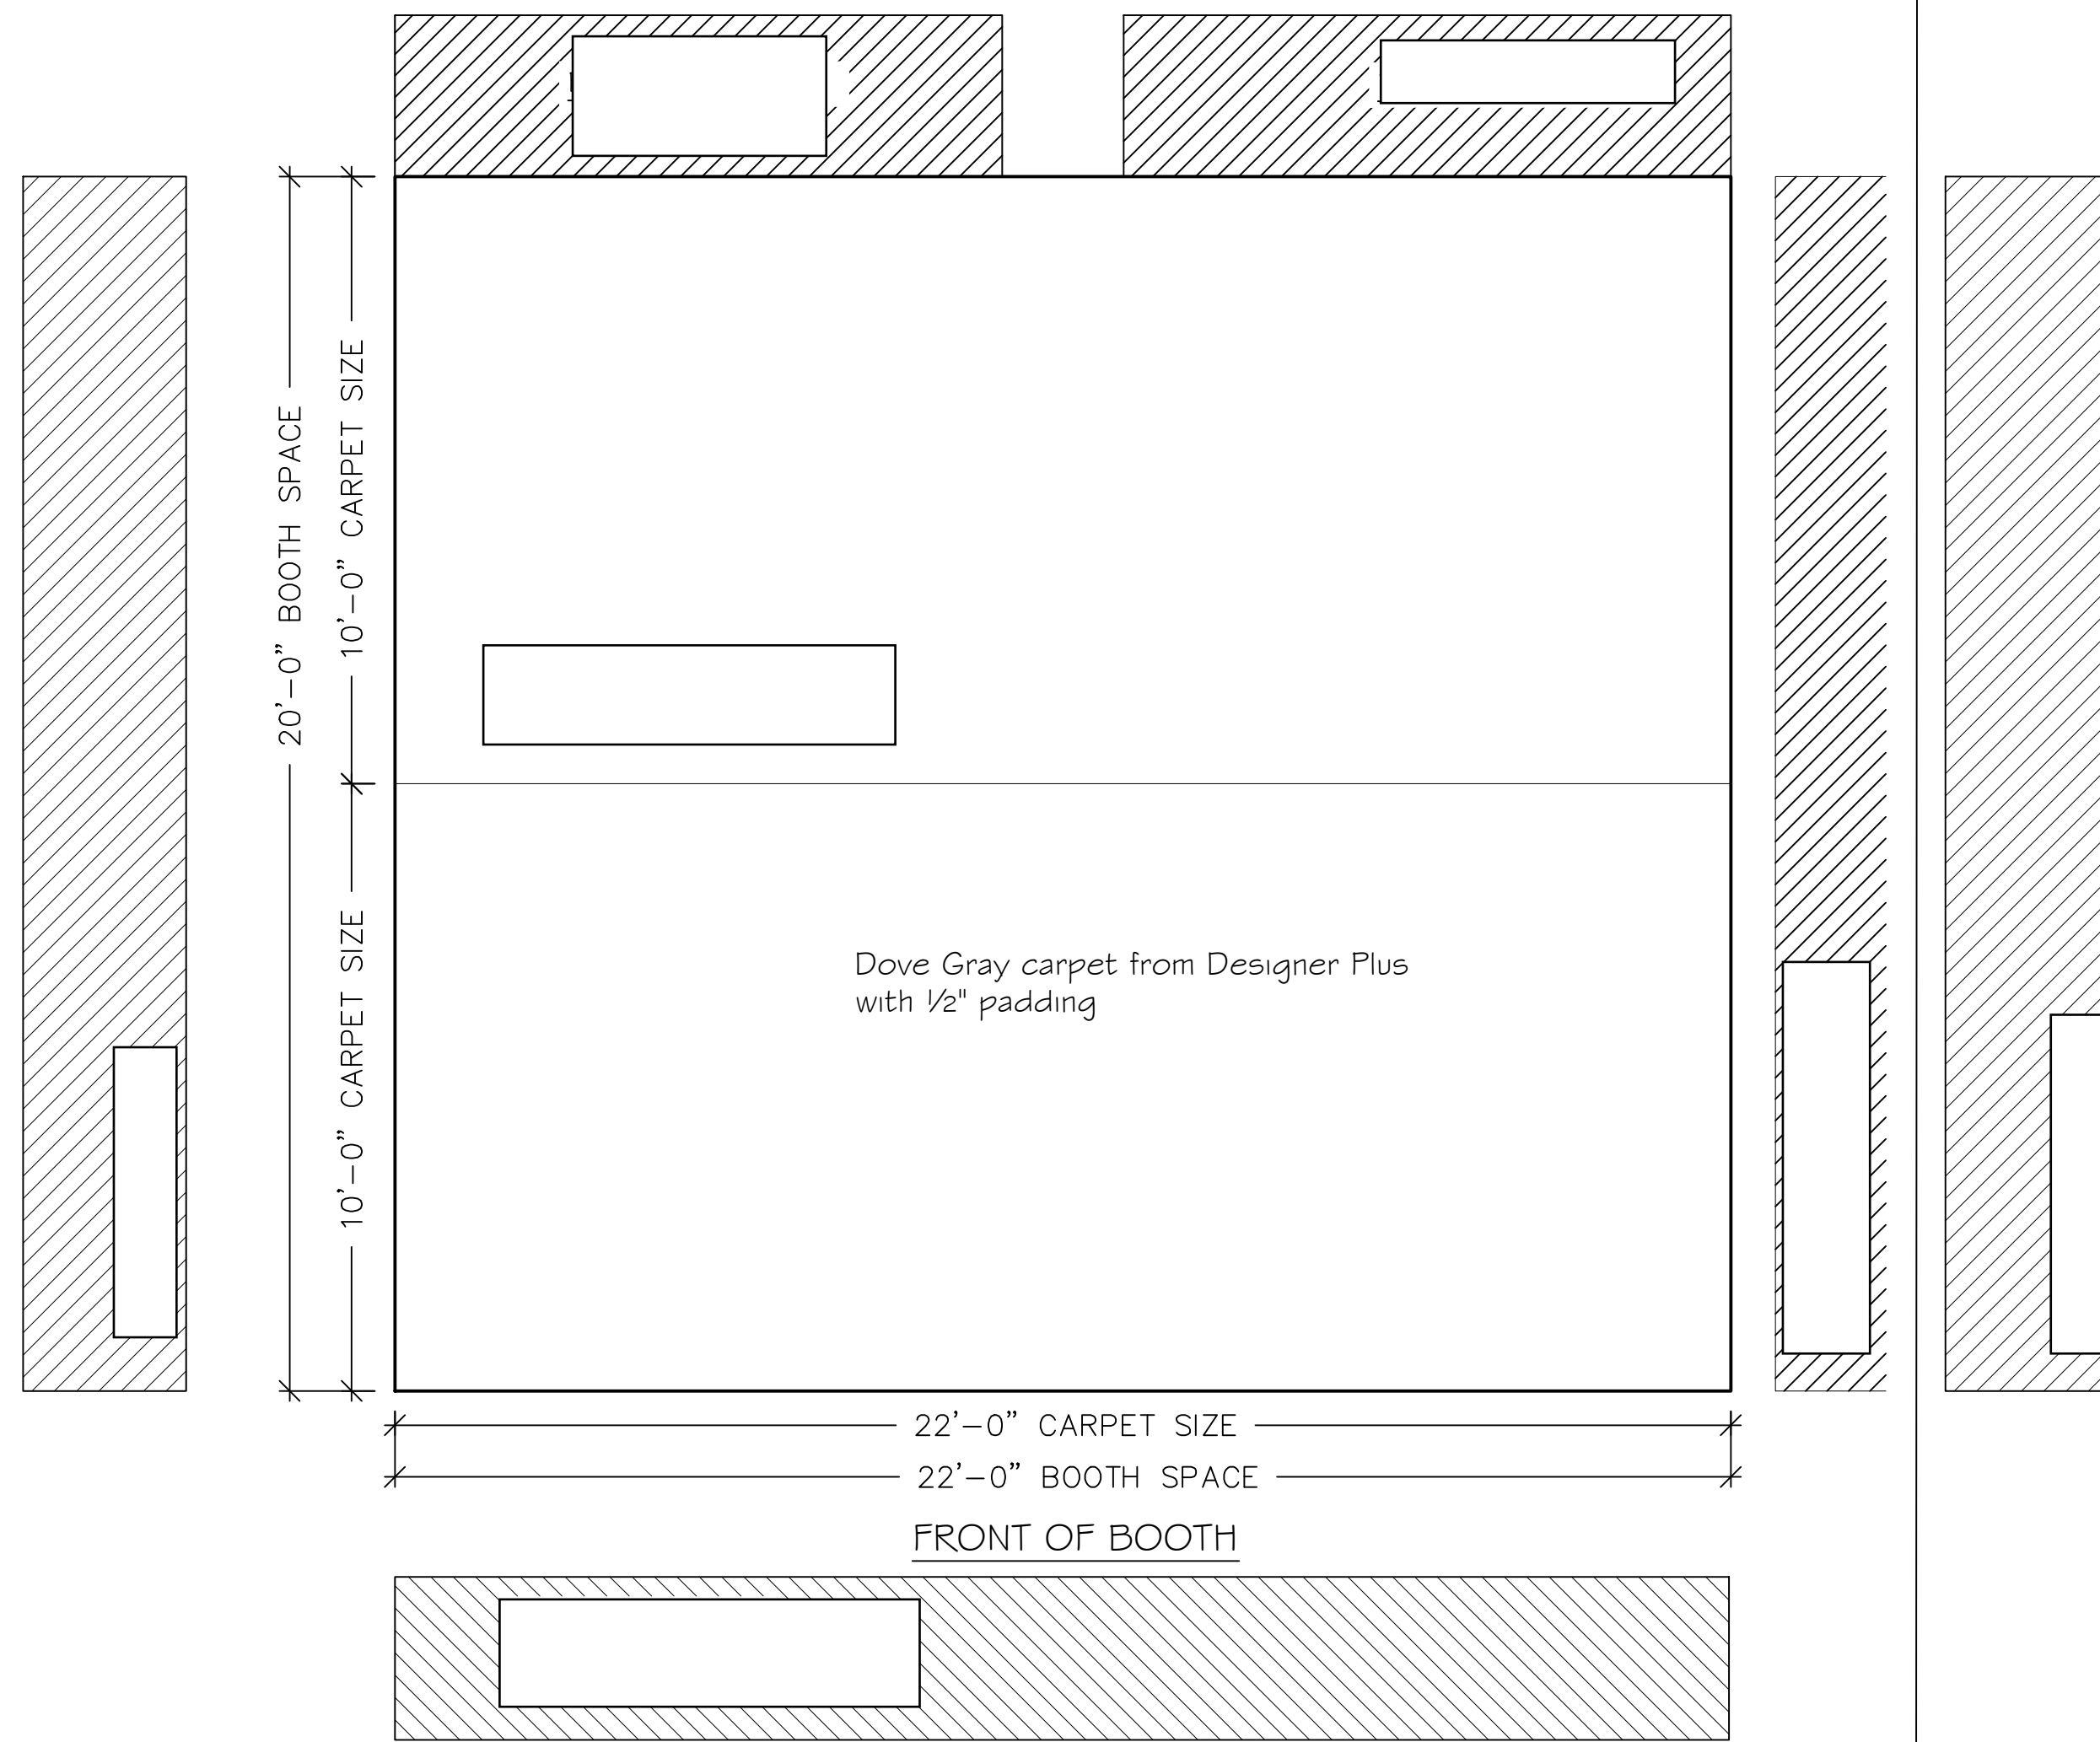

1 CARPET PLAN
SCALE: 3/8"=1'-0"

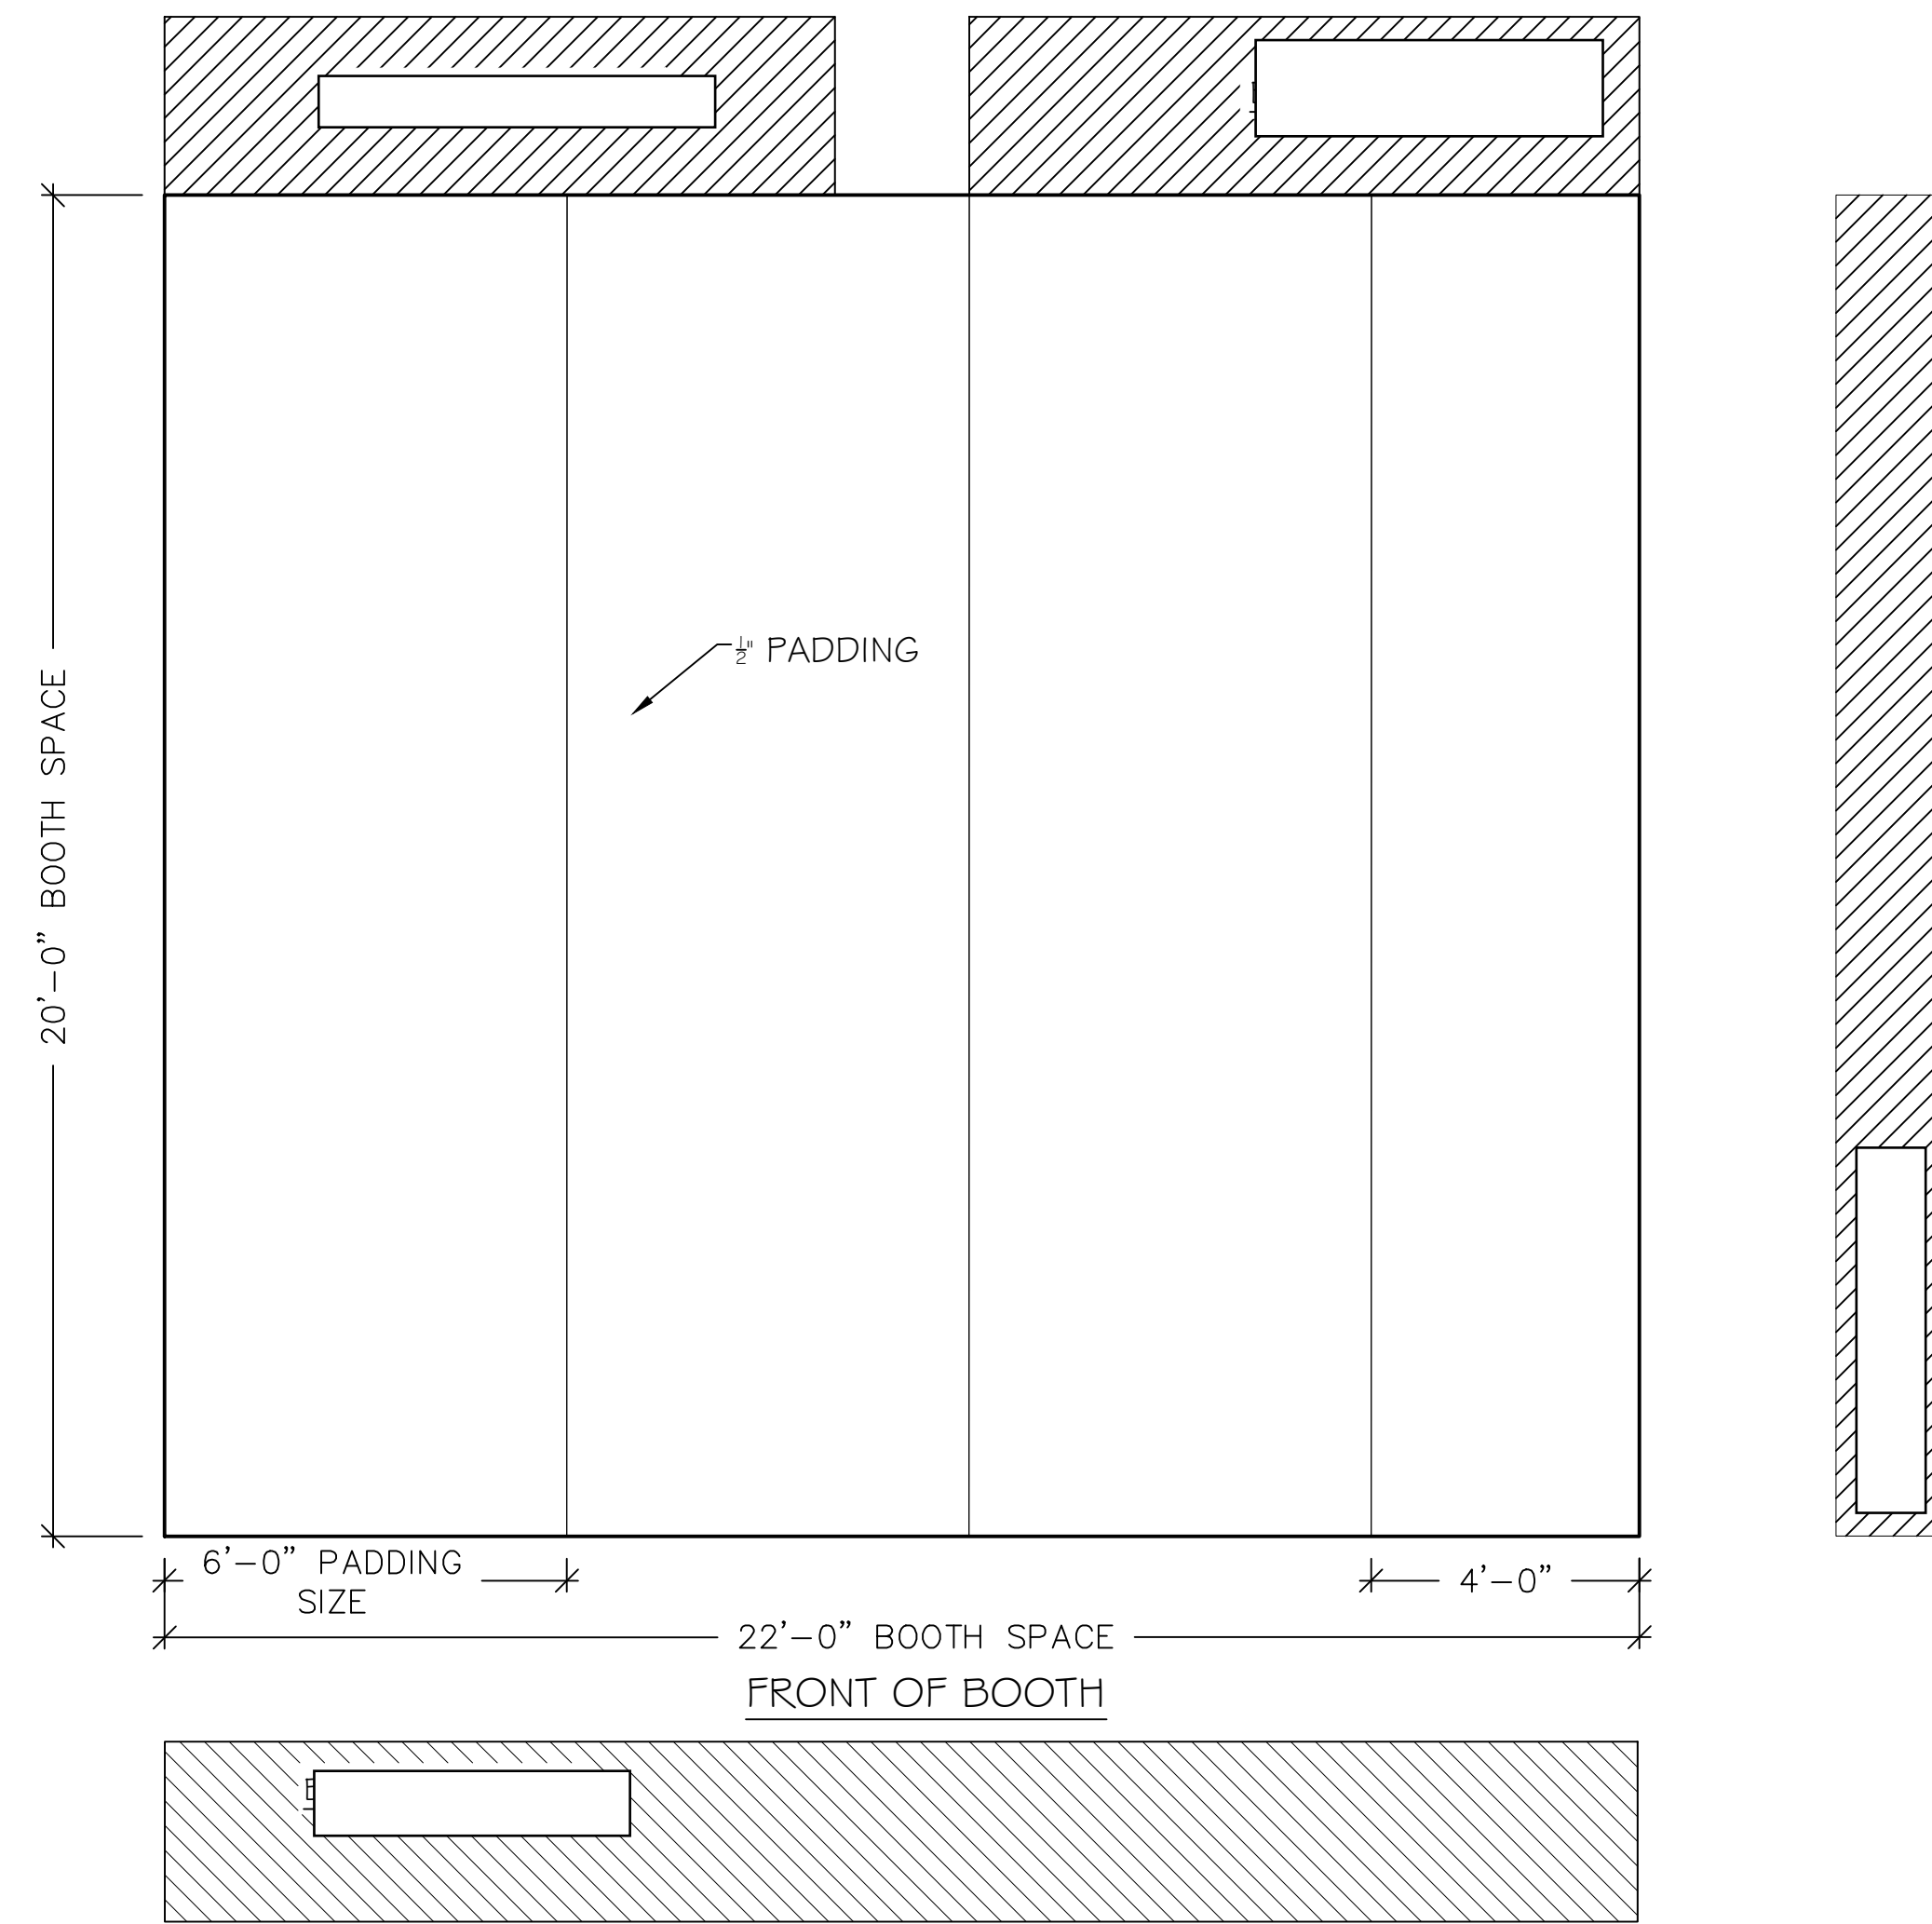

2 PADDING PLAN
SCALE: 3/8"=1'-0"

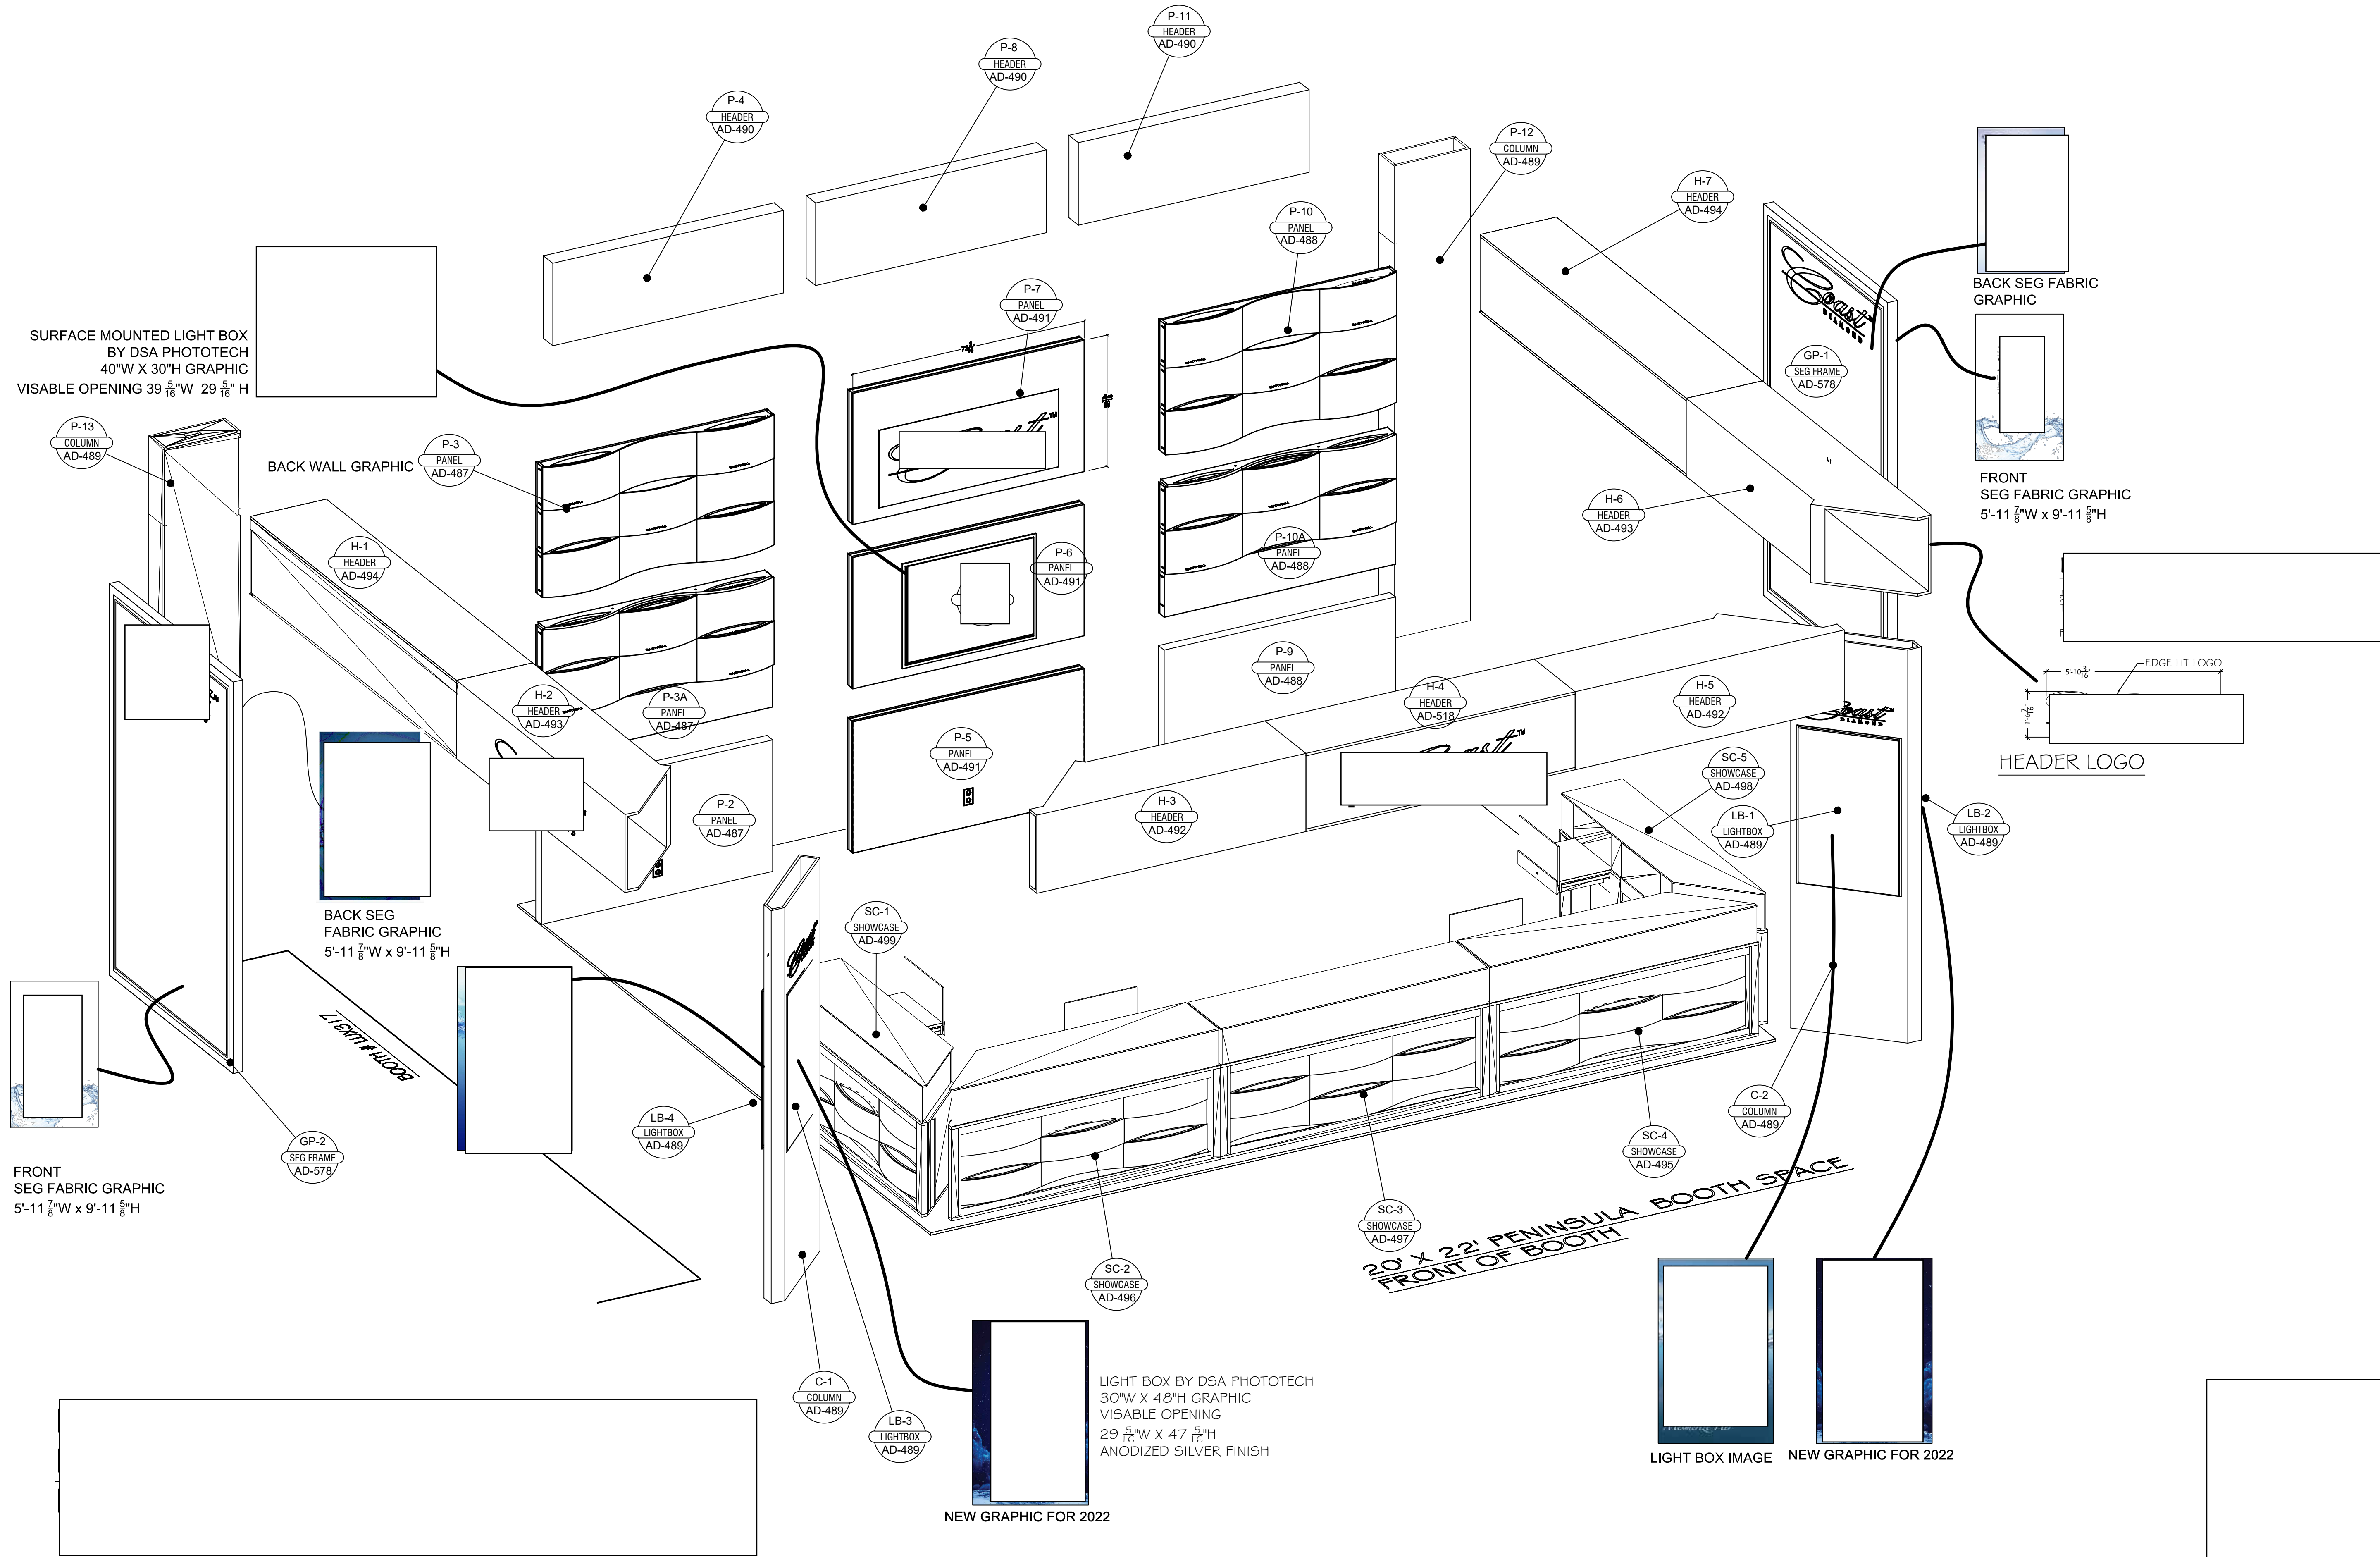

SURFACE MOUNTED LIGHT BOX
BY DSA PHOTOTECH
40"W X 30"H GRAPHIC
VISIBLE OPENING 39 ⁵/₁₆" W 29 ⁵/₁₆" H

FRONT
SEG FABRIC GRAPHIC
5'-11 ⁷/₈" W x 9'-11 ⁵/₈" H

BACK WALL GRAPHIC

BACK SEG
FABRIC GRAPHIC
5'-11 ⁷/₈" W x 9'-11 ⁵/₈" H

BACK SEG FABRIC
GRAPHIC

FRONT
SEG FABRIC GRAPHIC
5'-11 ⁷/₈" W x 9'-11 ⁵/₈" H

HEADER LOGO

LIGHT BOX BY DSA PHOTOTECH
30"W X 48"H GRAPHIC
VISIBLE OPENING
29 ⁵/₁₆" W X 47 ⁵/₁₆" H
ANODIZED SILVER FINISH

LIGHT BOX IMAGE NEW GRAPHIC FOR 2022

1 **SETUPS BACKWALL COLUMN HEADER**
SCALE: NTS




GRIP HANDLE W/ LONG STRAP # P018219701
SPORT SMITH 888-713-2880

NOTE: FOR 6-2016 SHOW, NEW GRIP HANDLES W/ STRAPS TO CONNECT TO ROLLING
CARTS FOR TRANSPORTING CARTS TO & FROM STORAGE



3/8" SPRING LINK

HOME DEPOT
89532-5

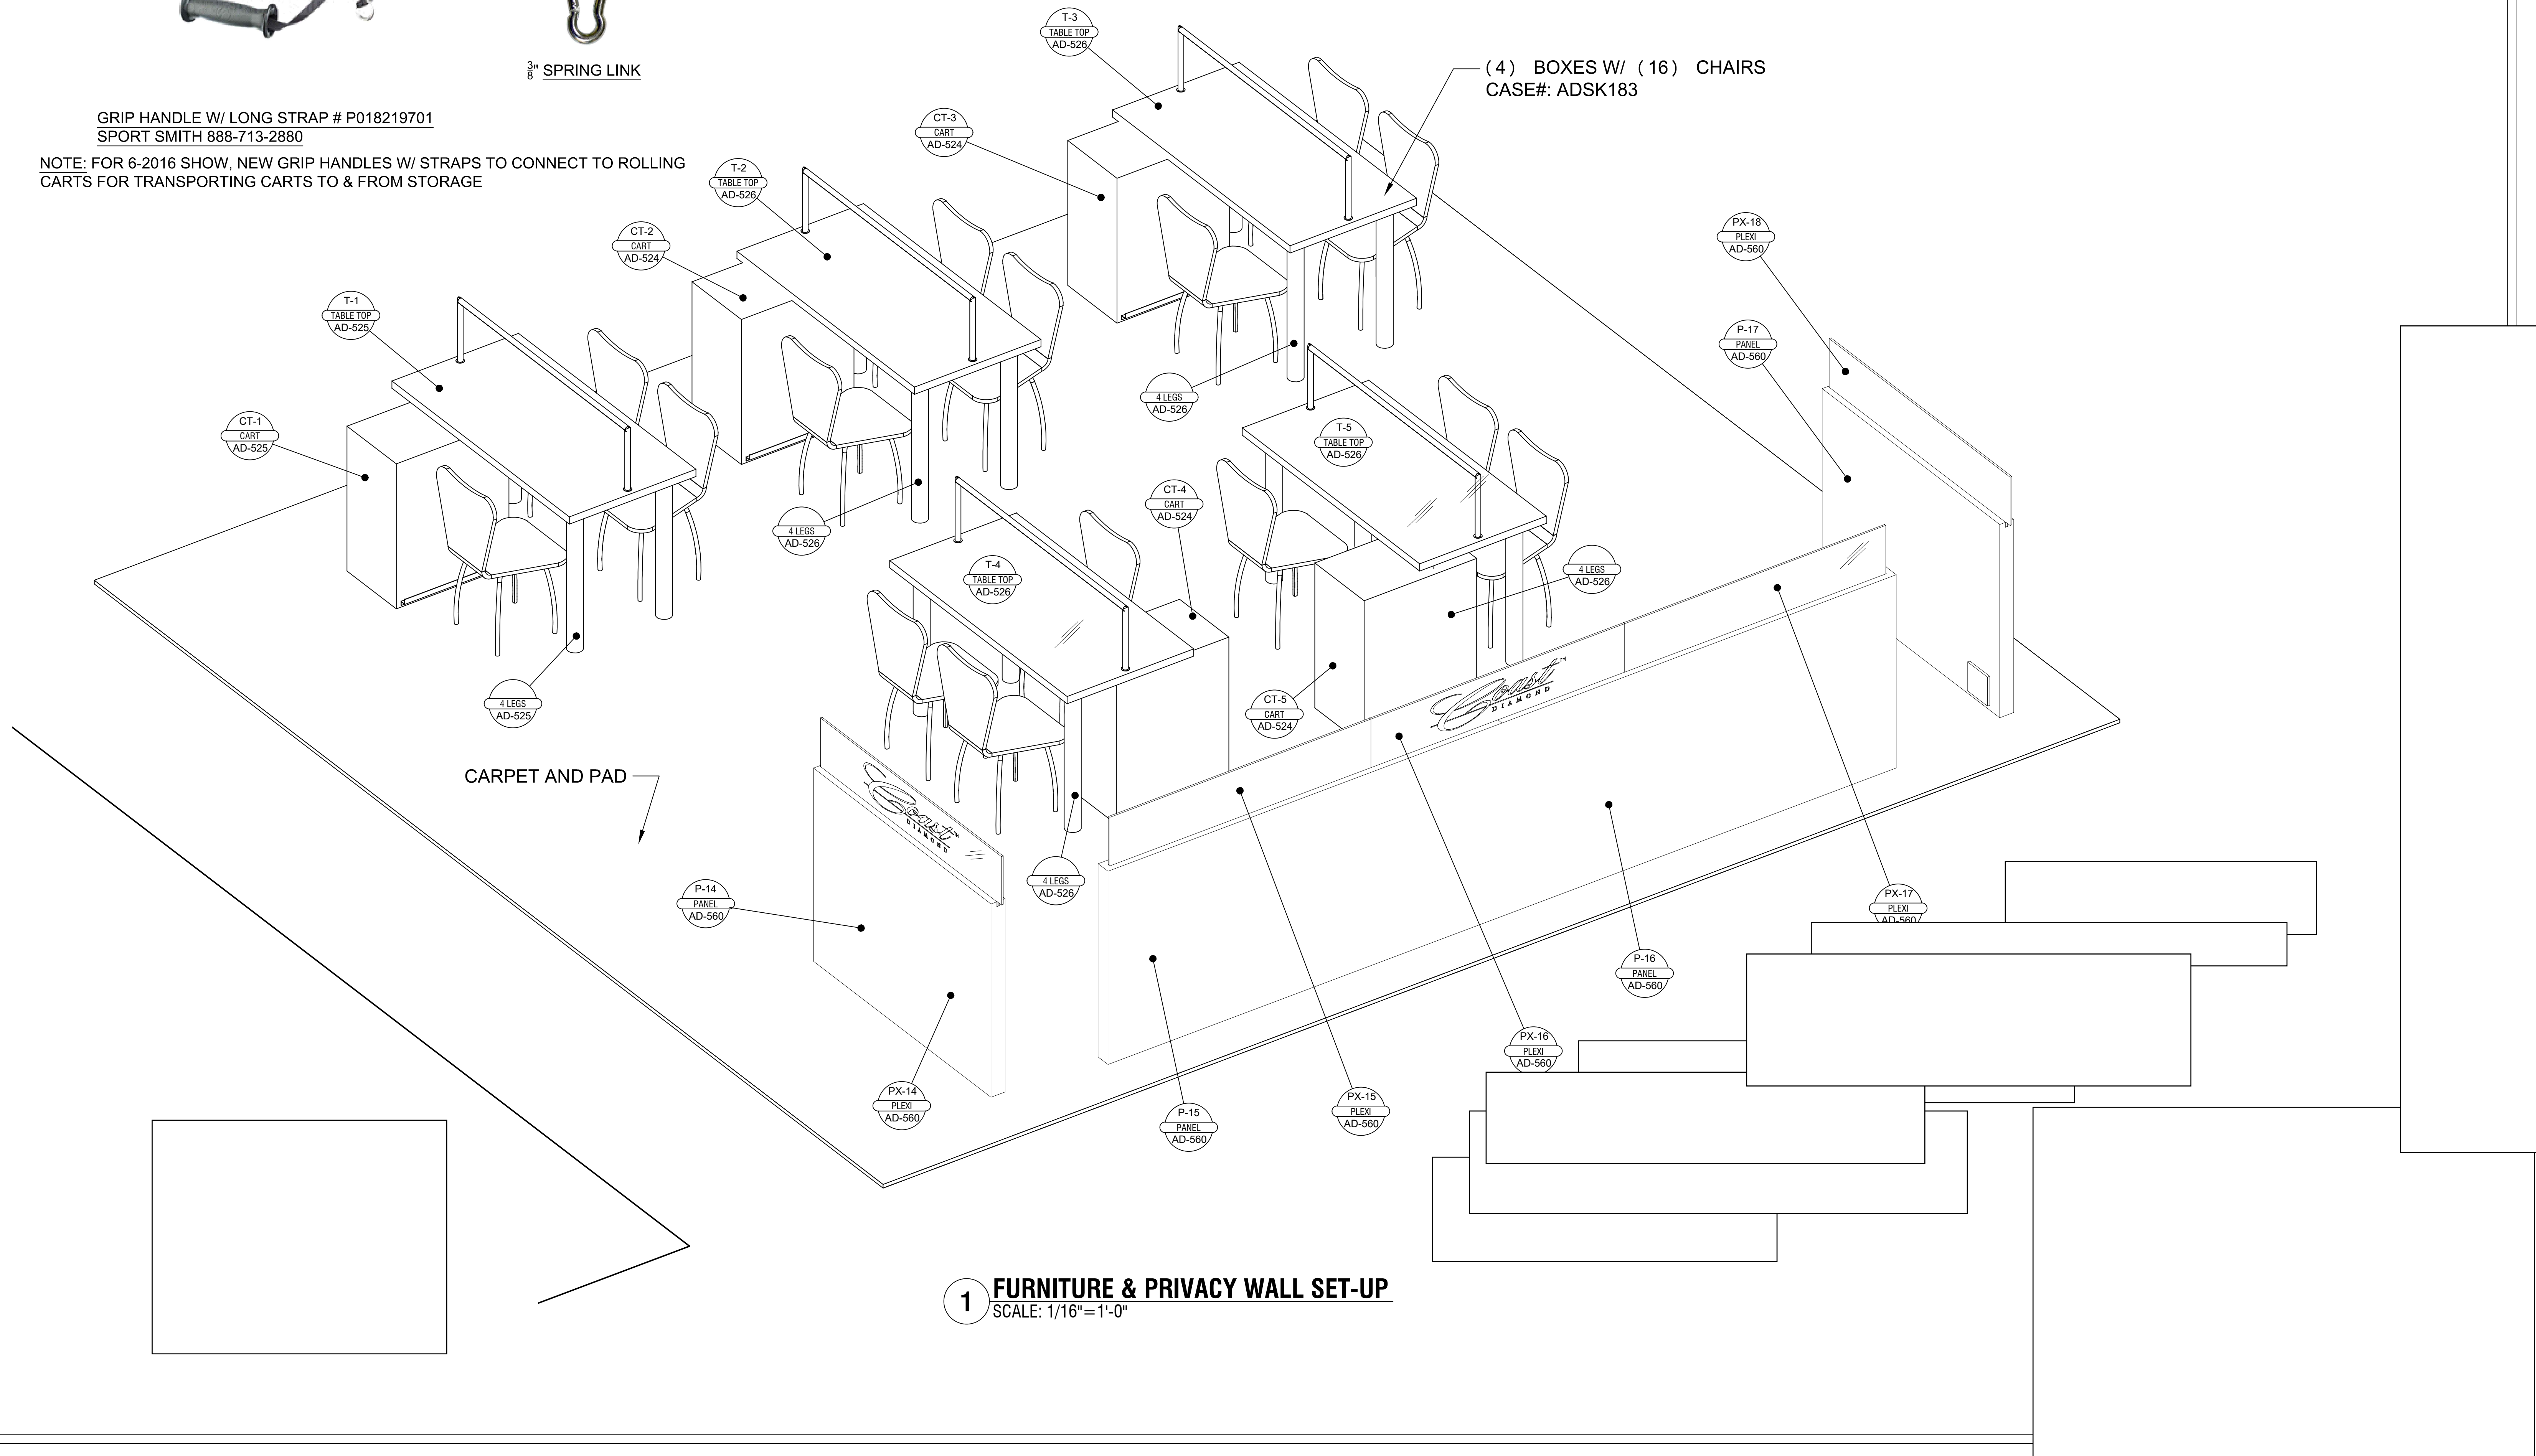

1 FURNITURE & PRIVACY WALL SET-UP
SCALE: 1/16"=1'-0"