




SET-UP PLAN

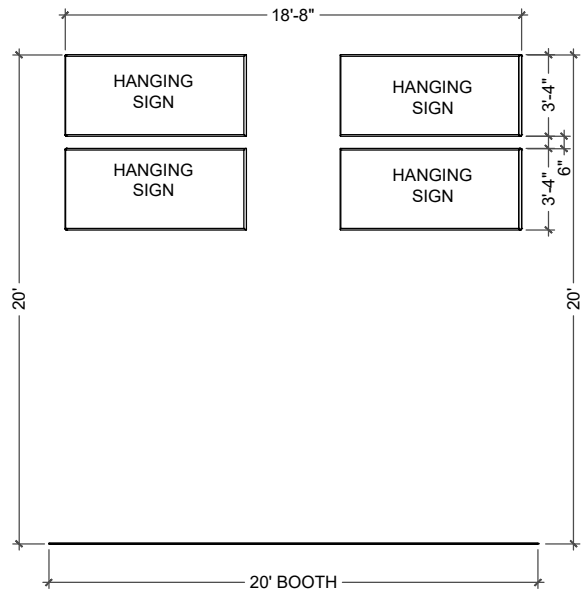

FRONT VIEW

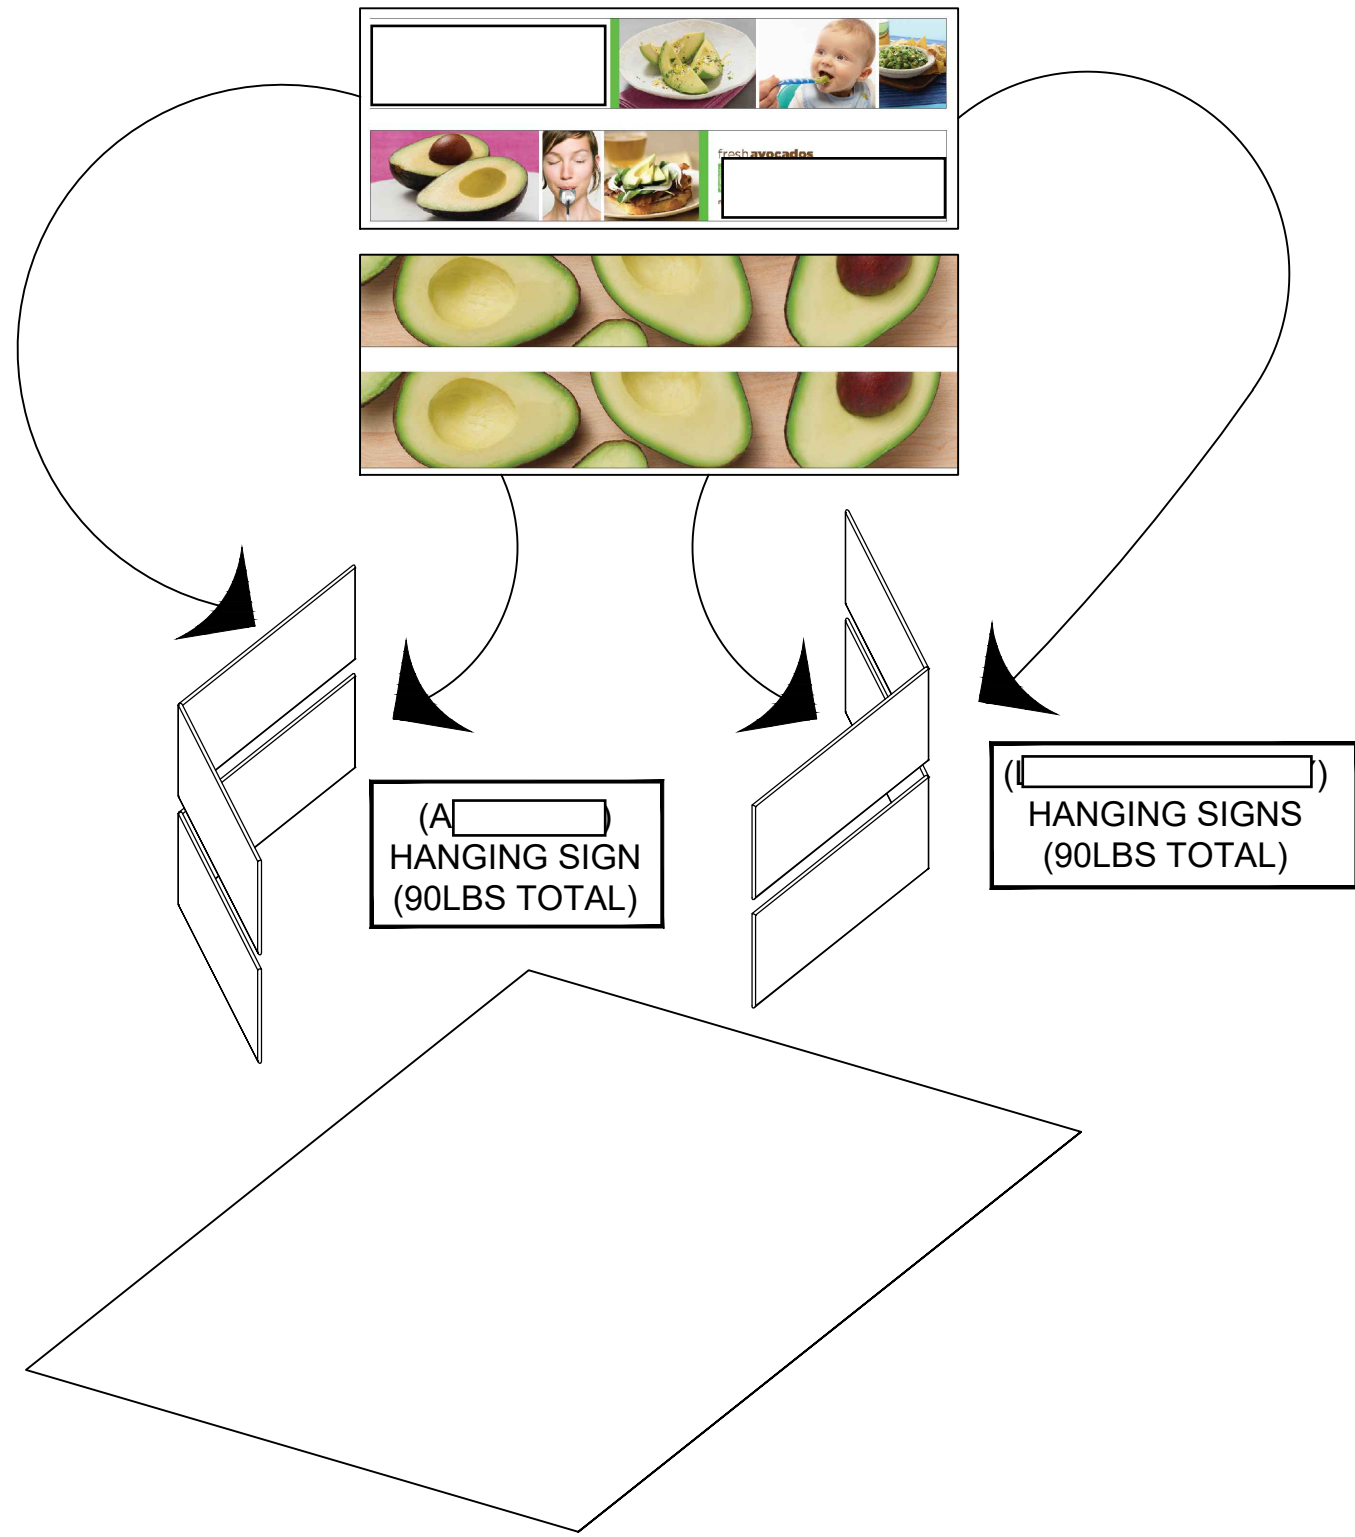

AXONOMETRIC VIEW

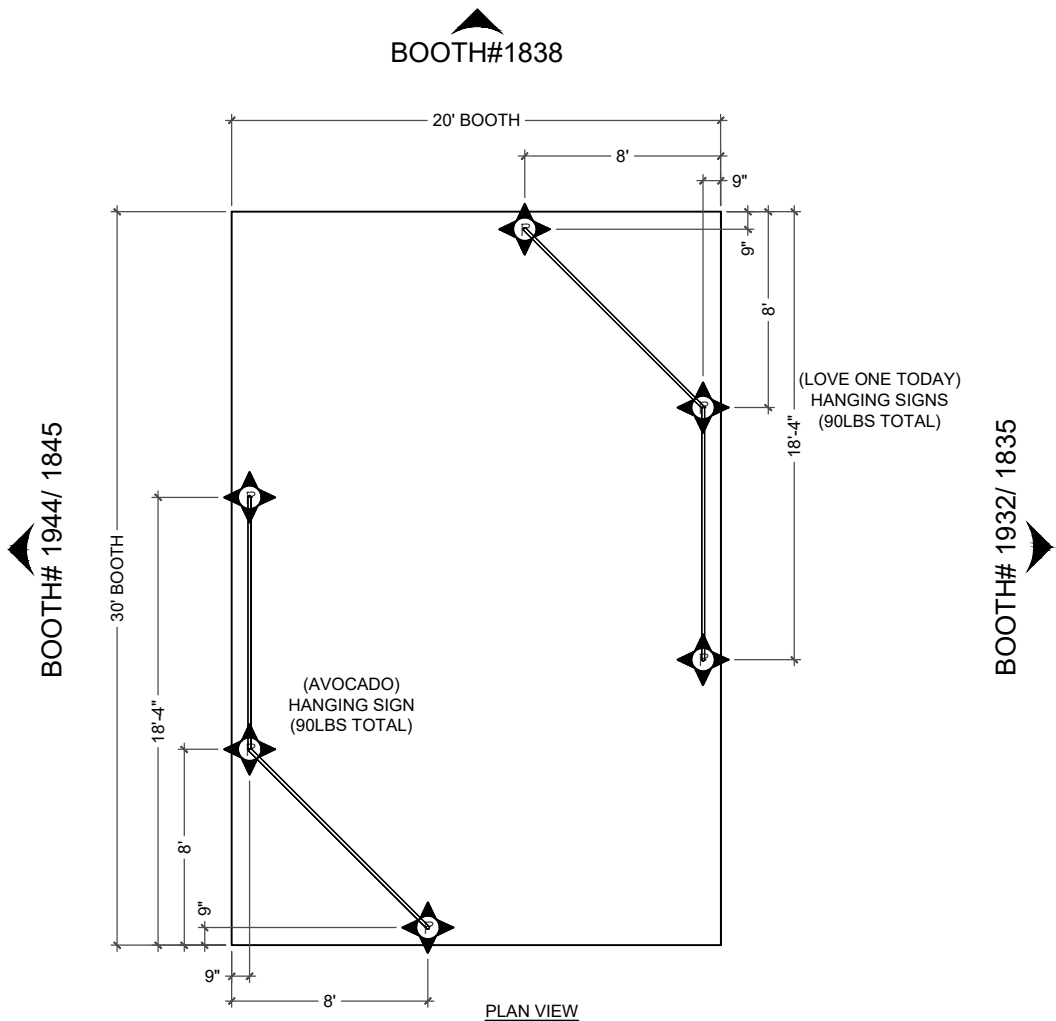


PLAN VIEW


RIGGING PLAN
SCALE: 1/4"=1'-0"

BOOTH# HALL COLUMN



 ENTRANCE

P PICK POINTS

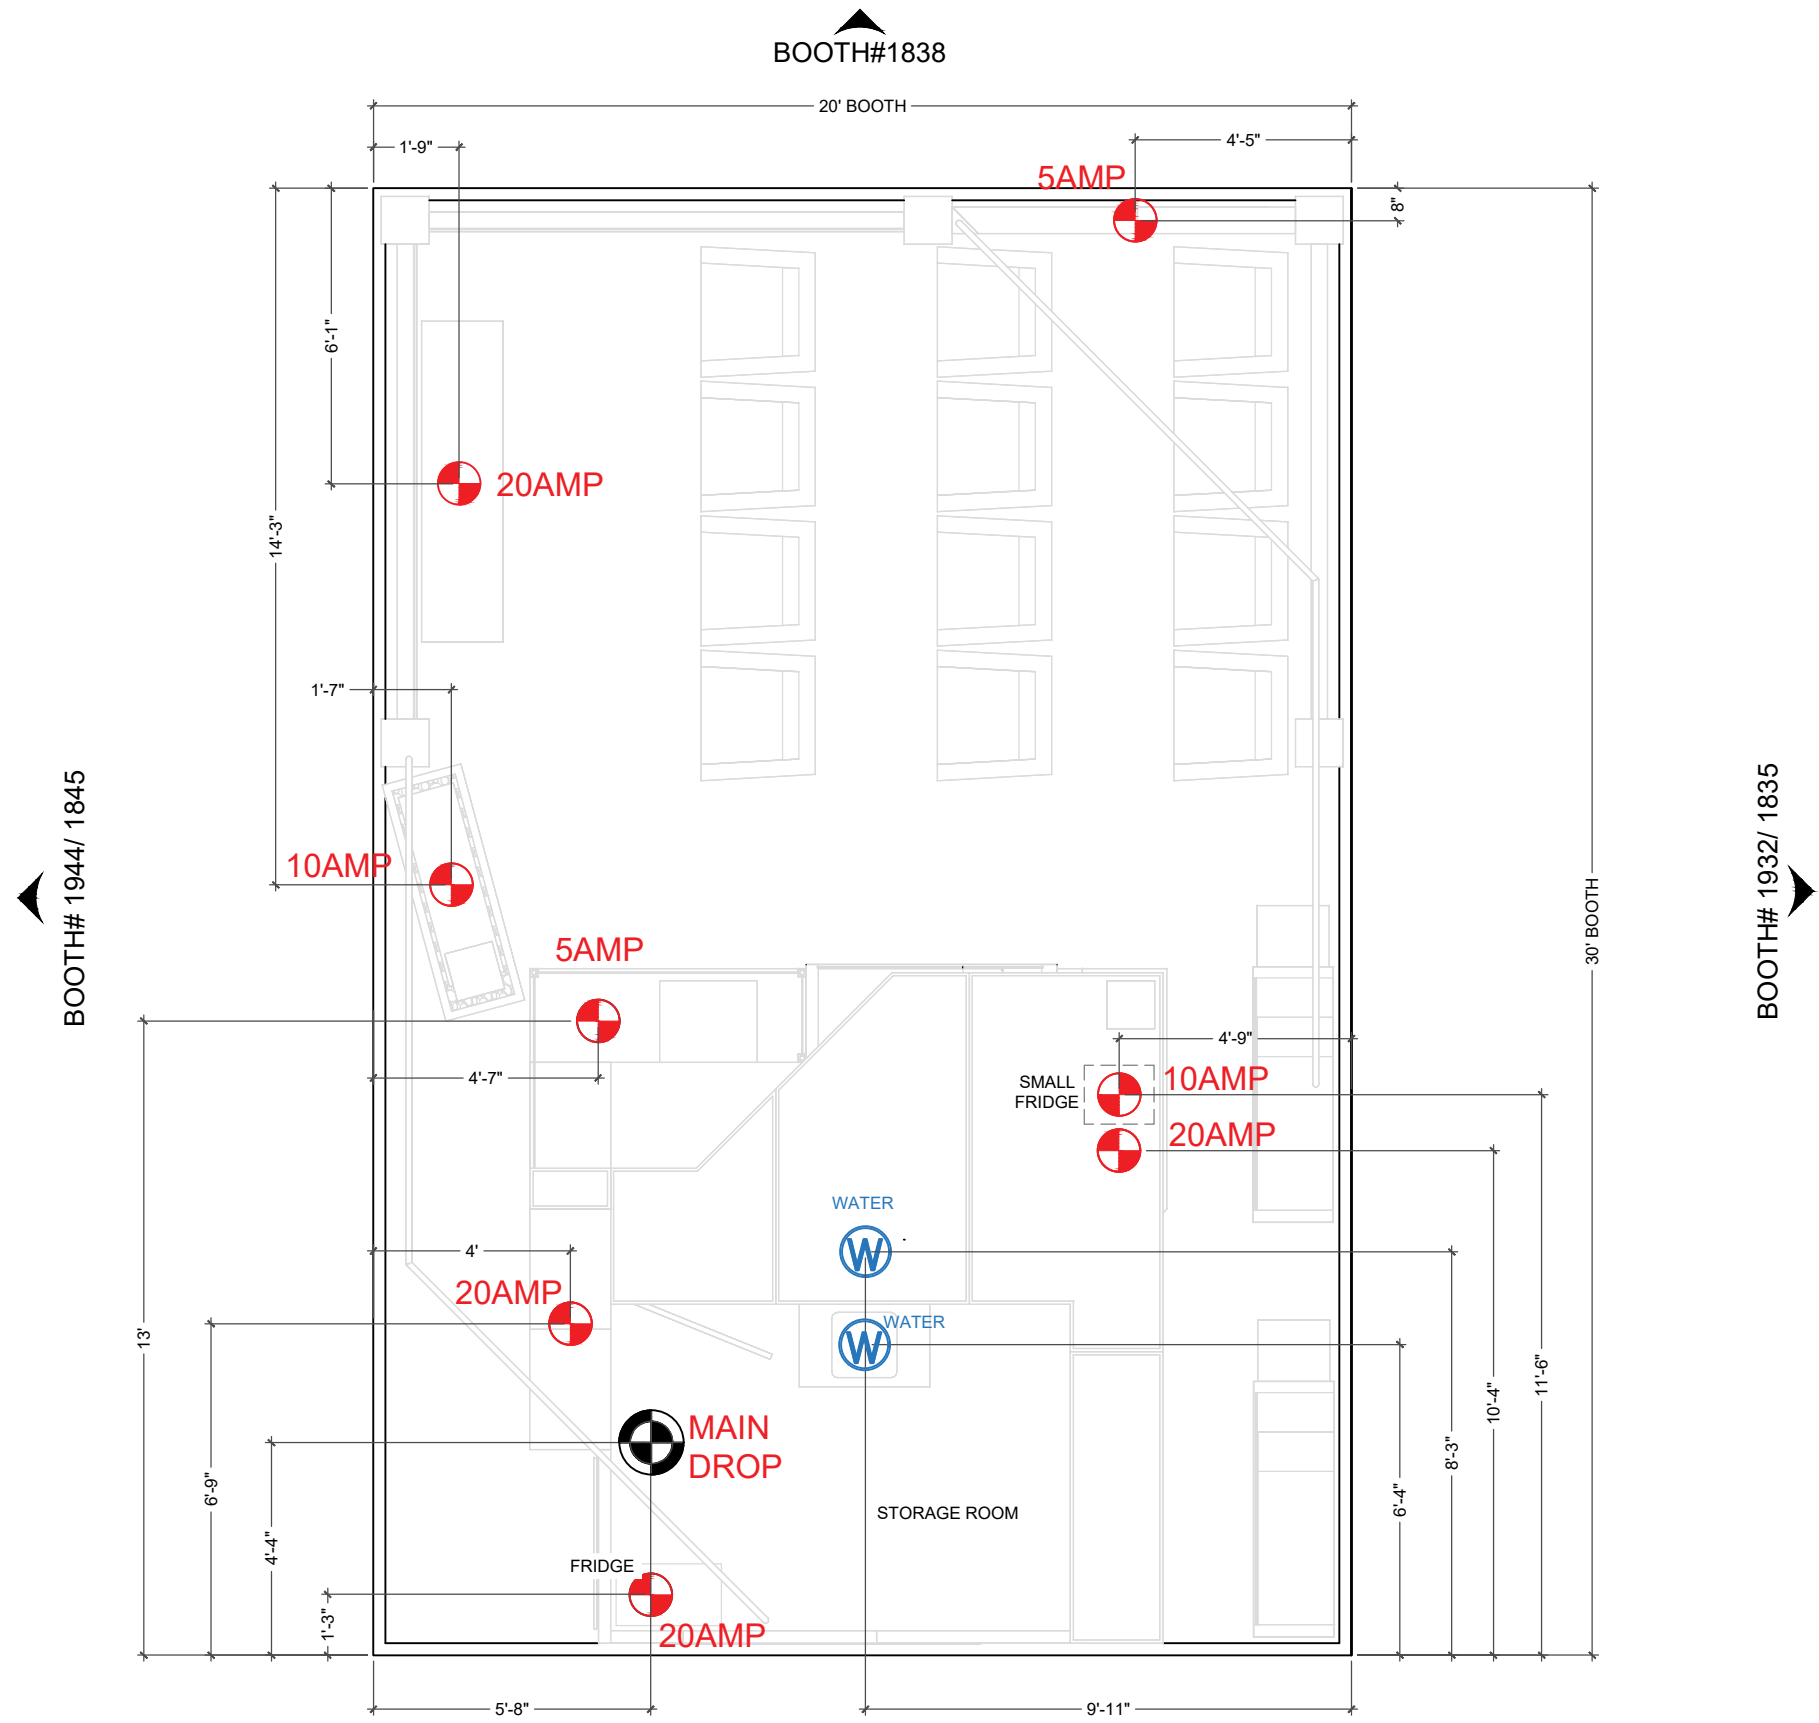






SET UP INSTRUCTIONS:

1. LAY OUT MAIN ELECTRICAL AS SHOWN 
2. SUB FEED ALL ELECTRICAL LOCATIONS UNDER CARPET TO LOCATIONS MARKED 
3. INSTALL CARPET AND PAD AS NEEDED.

ELECTRICAL REQ'MTS


-  (2) @ 5A
-  (2) @ 10A
-  (4) @ 20A

ELECTRICAL PLAN
SCALE: 1/2" = 1'-0"

BOOTH# HALL COLUMN ENTRANCE



BOOTH#1838

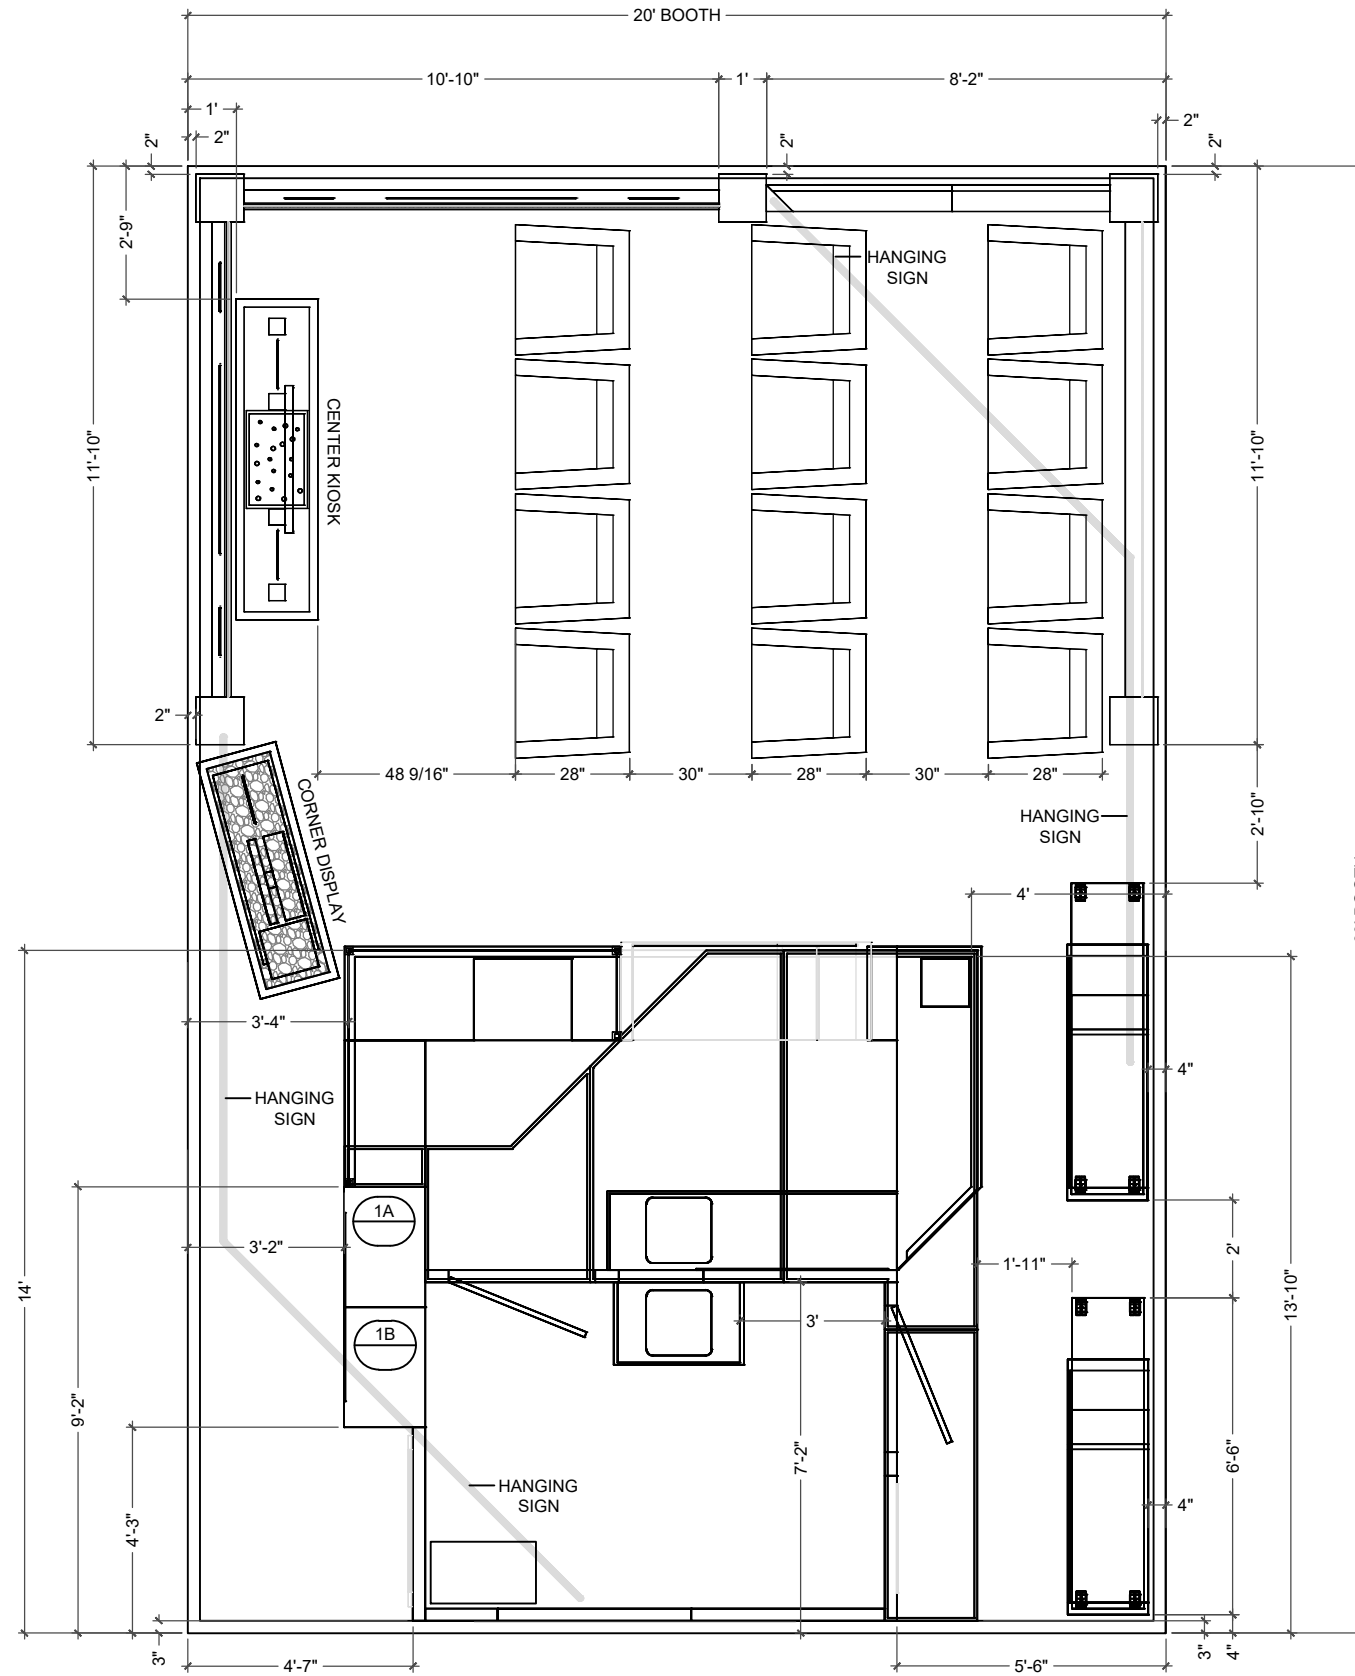





BOOTH# 1944/ 1845

BOOTH# 1932/ 1835


BOOTH# HALL COLUMN


ENTRANCE

FLOOR PLAN
SCALE: 1/2"=1'-0"

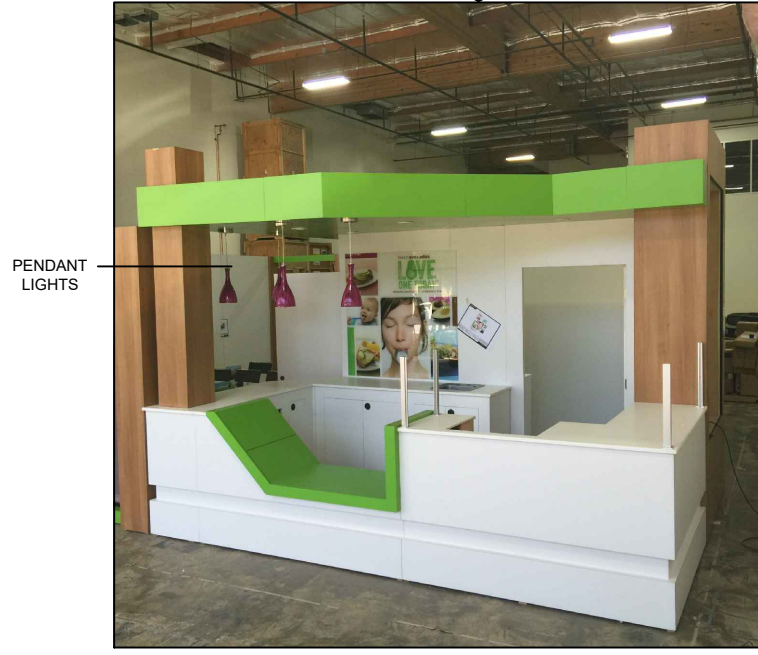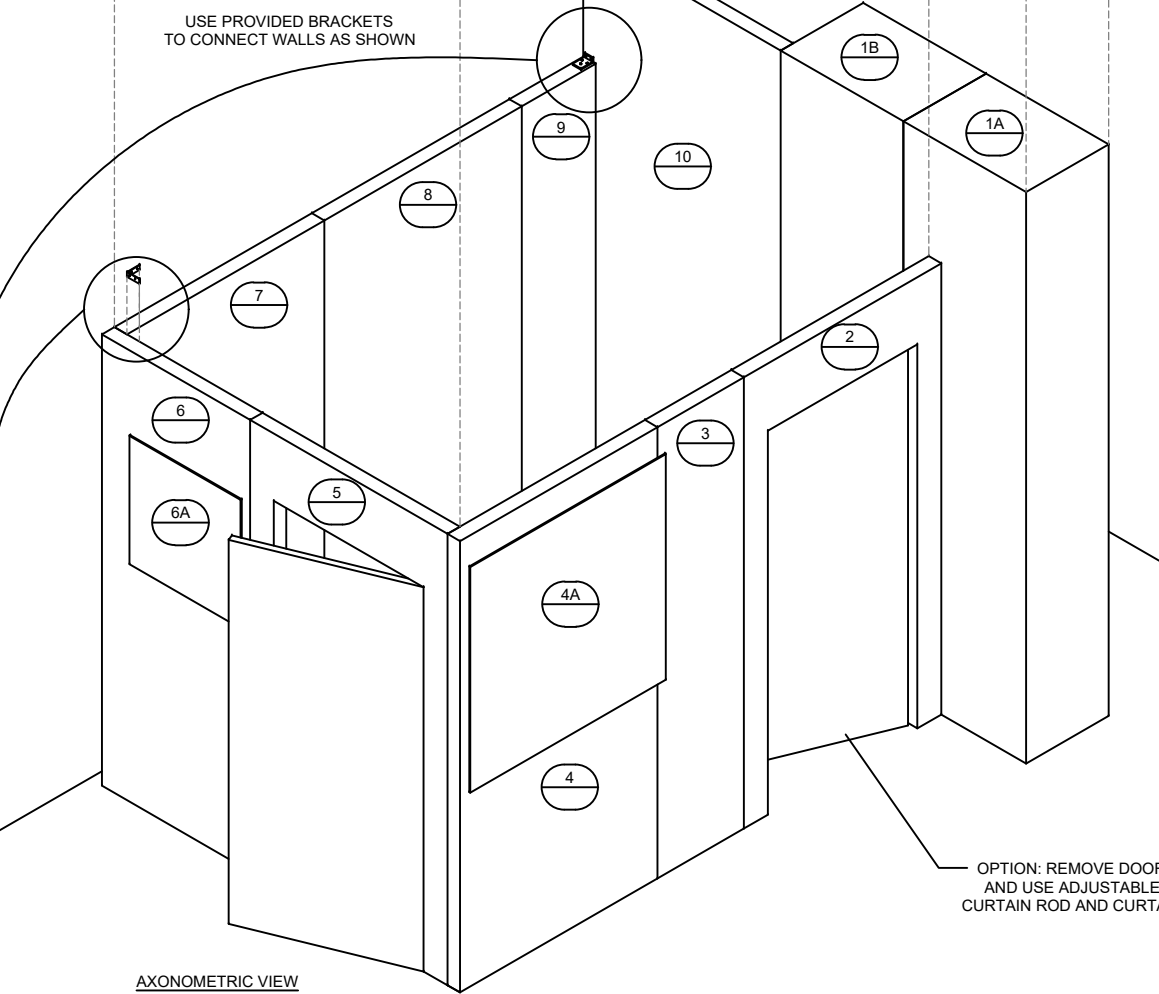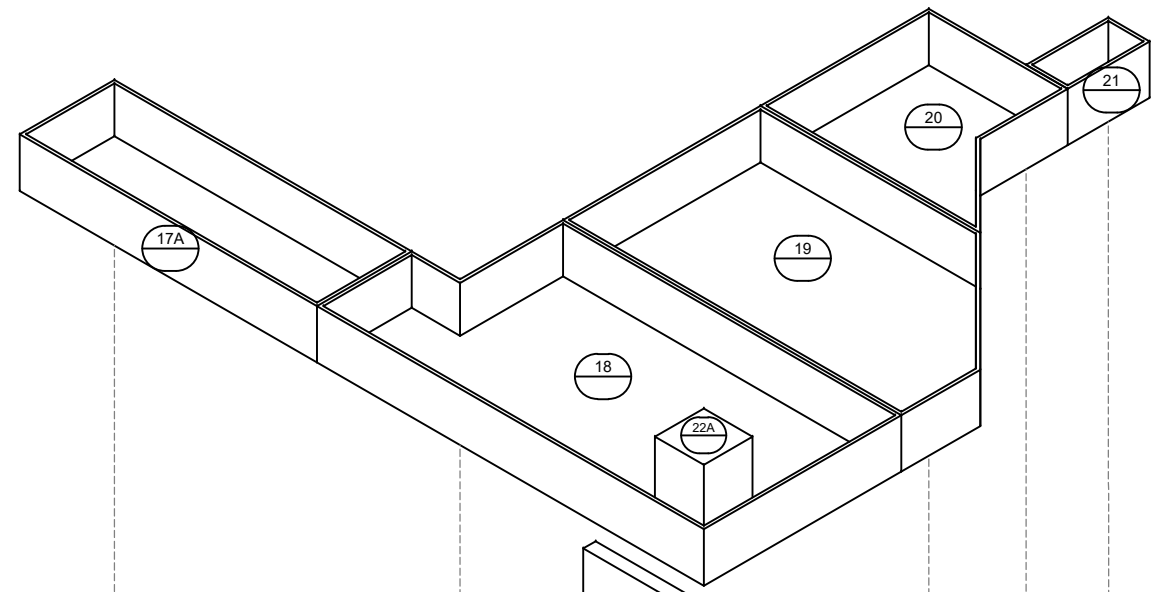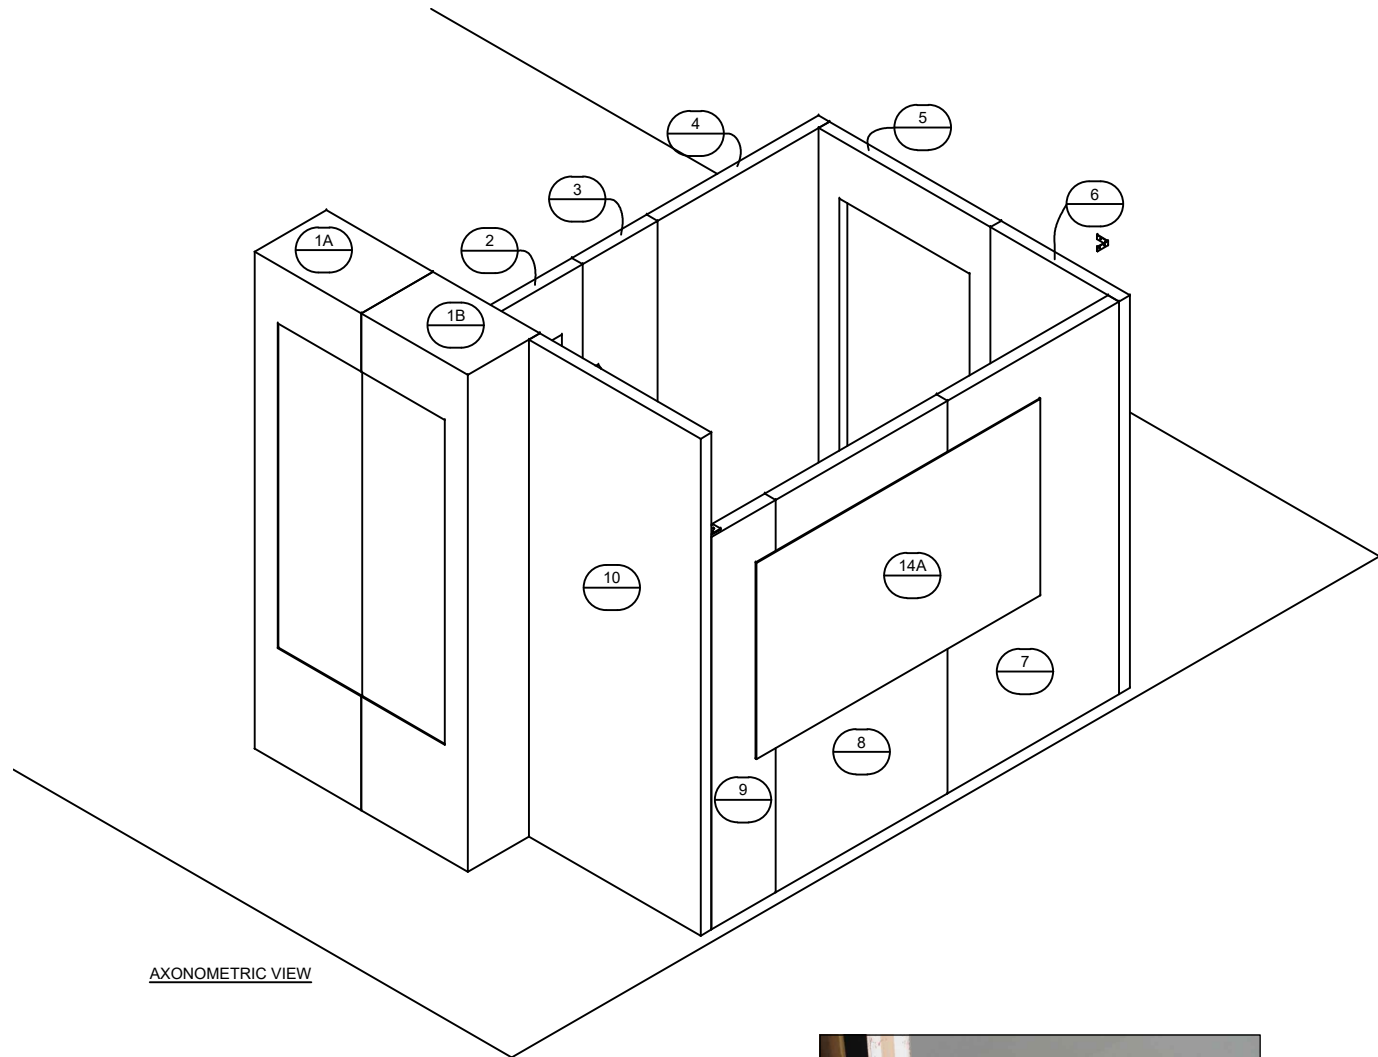




WALLS AND GRAPHICS
SCALE:NTS

 

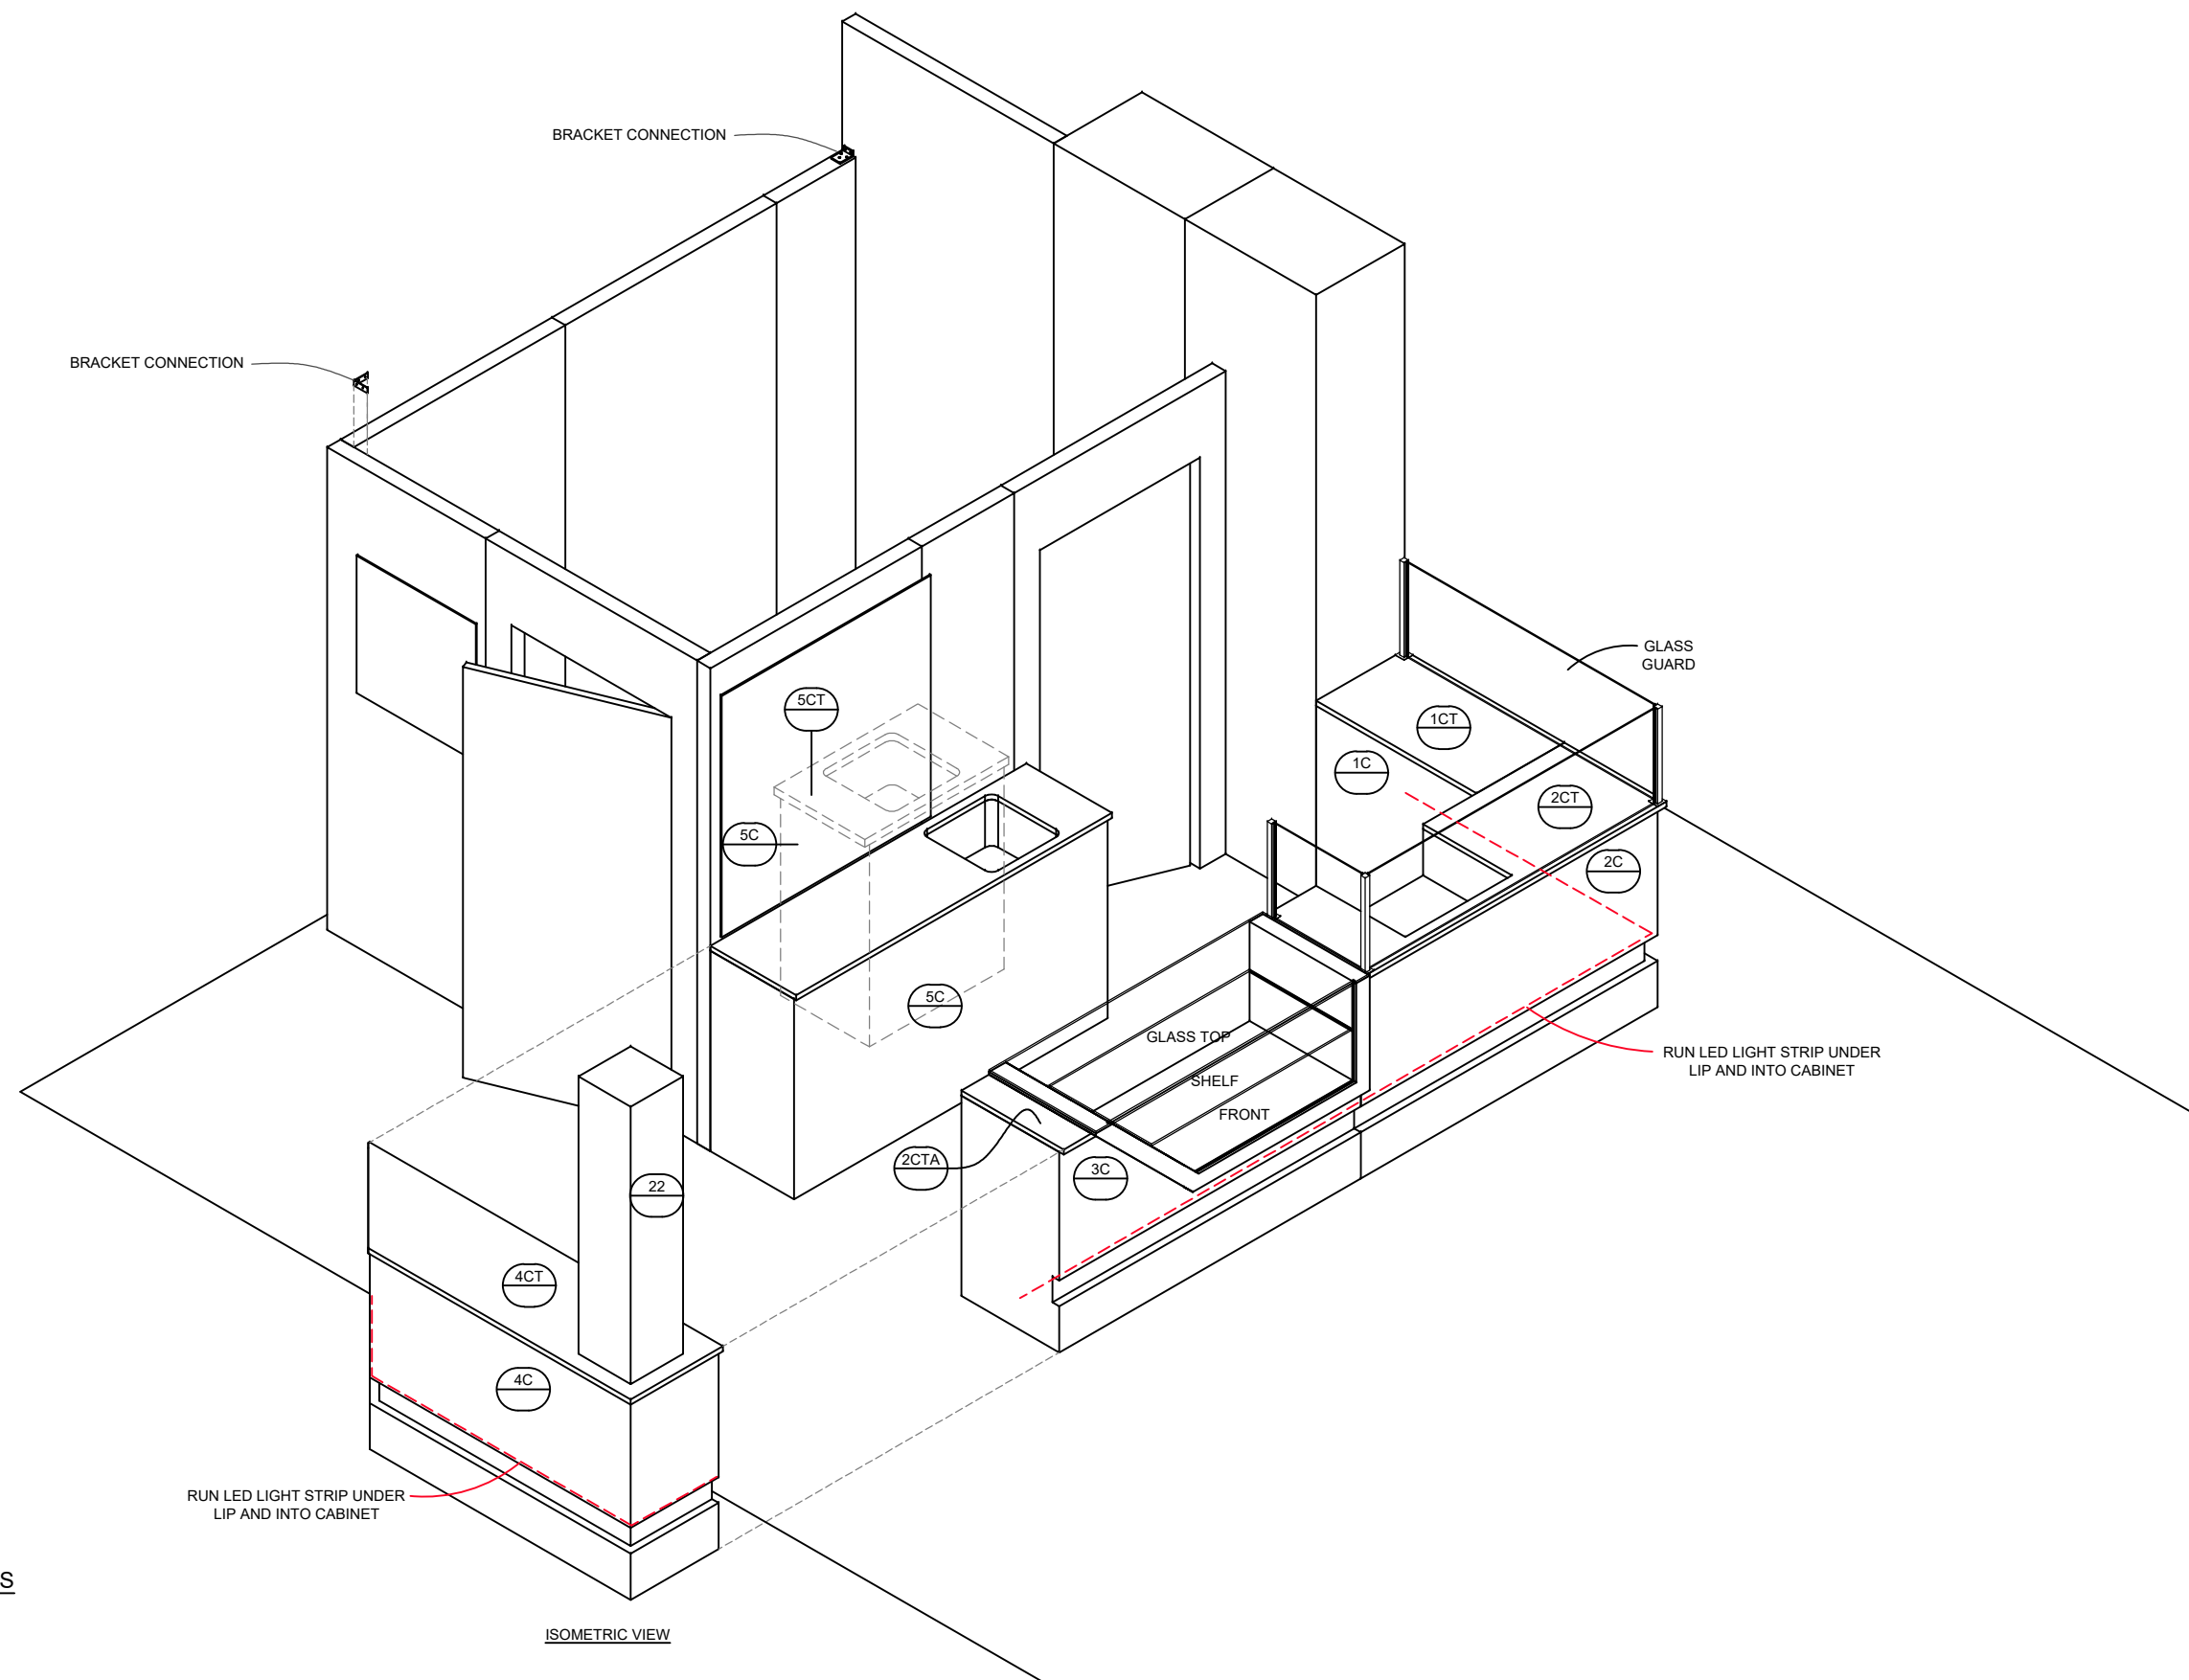



ISOMETRIC VIEW

 

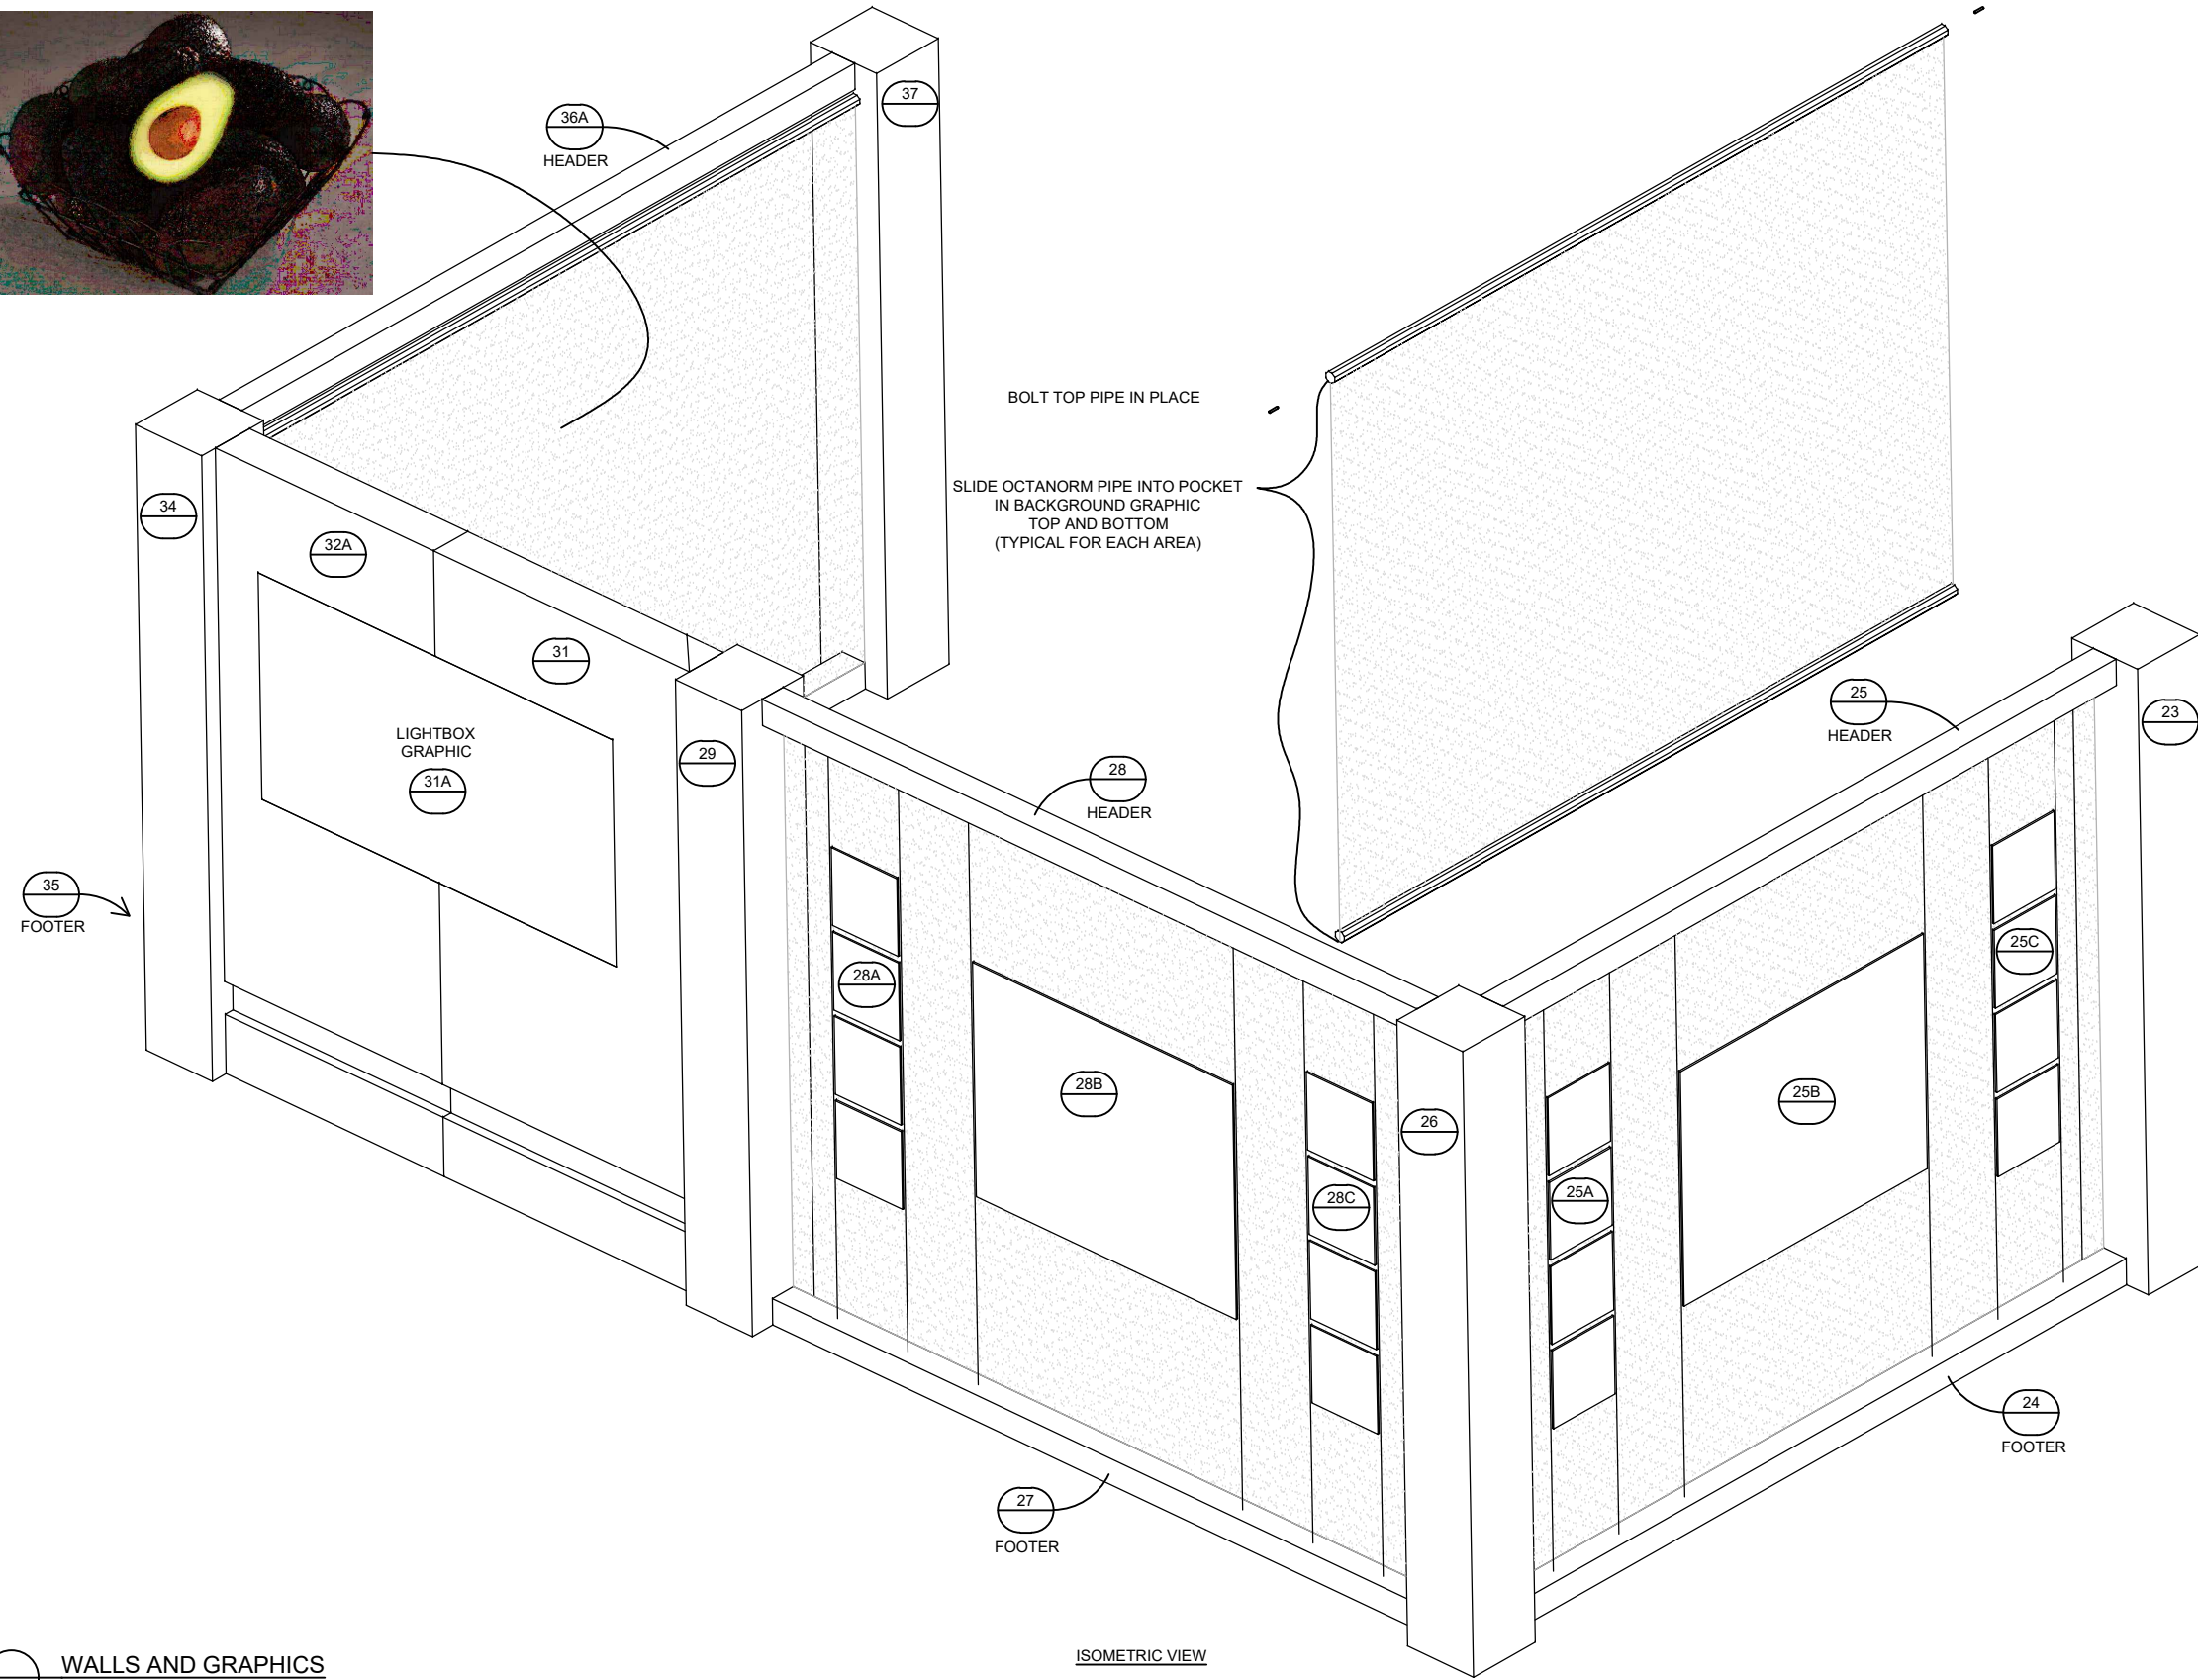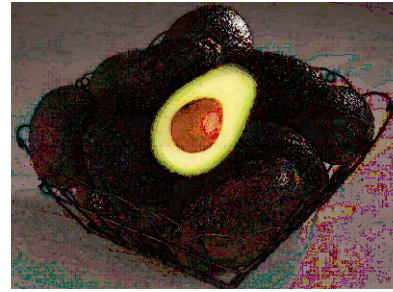

TYPICAL GRAPHIC WITH CABLES

 


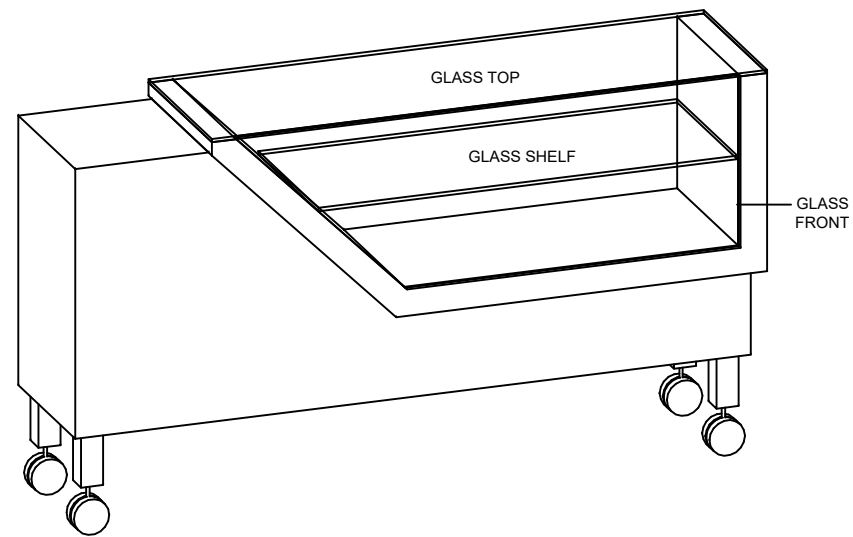


ROLLING DISPLAY (QTY 2)



TYPICAL GRAPHIC WITH CABLES

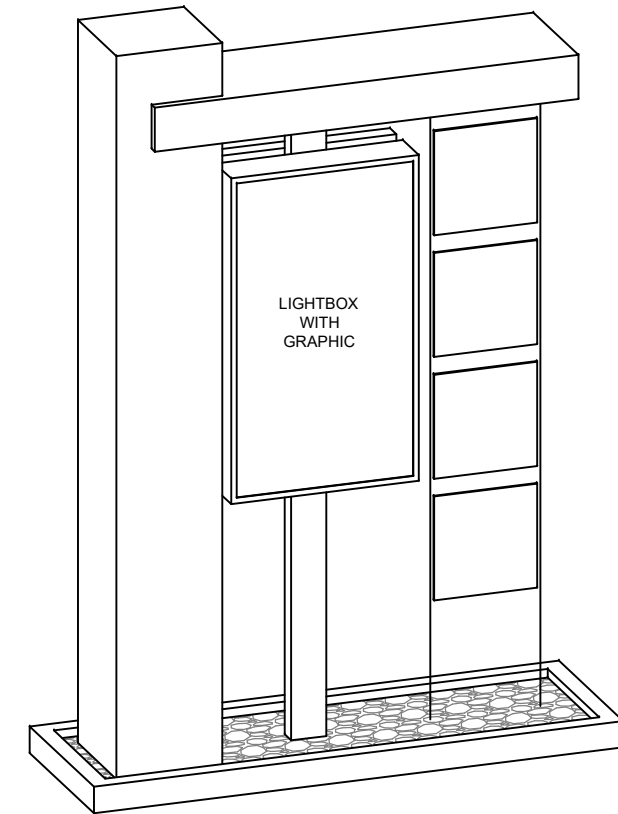

BACKVIEW

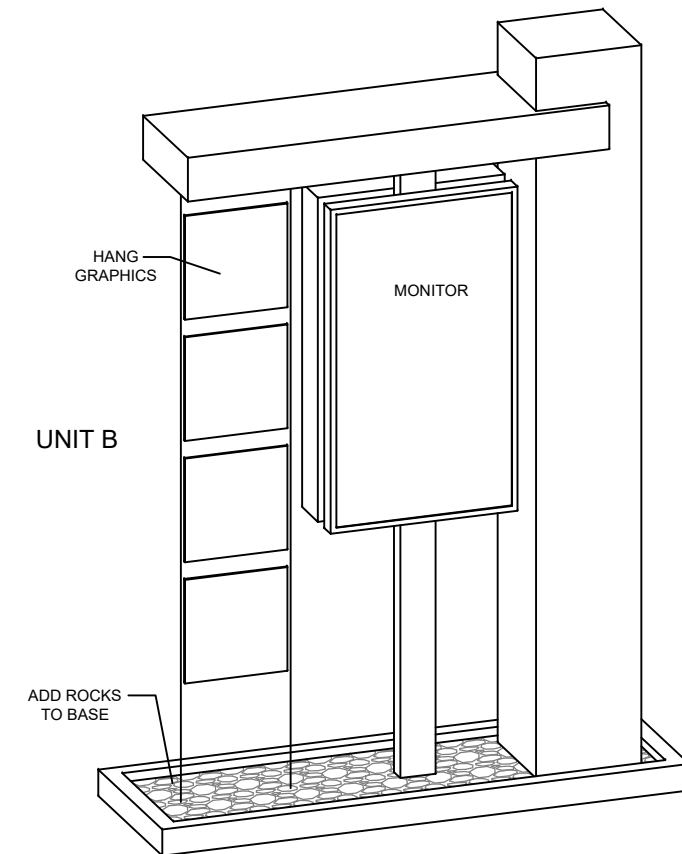

FRONT VIEW
CORNER DISPLAY

